



SERVER 102
1/4" = 1'-0"

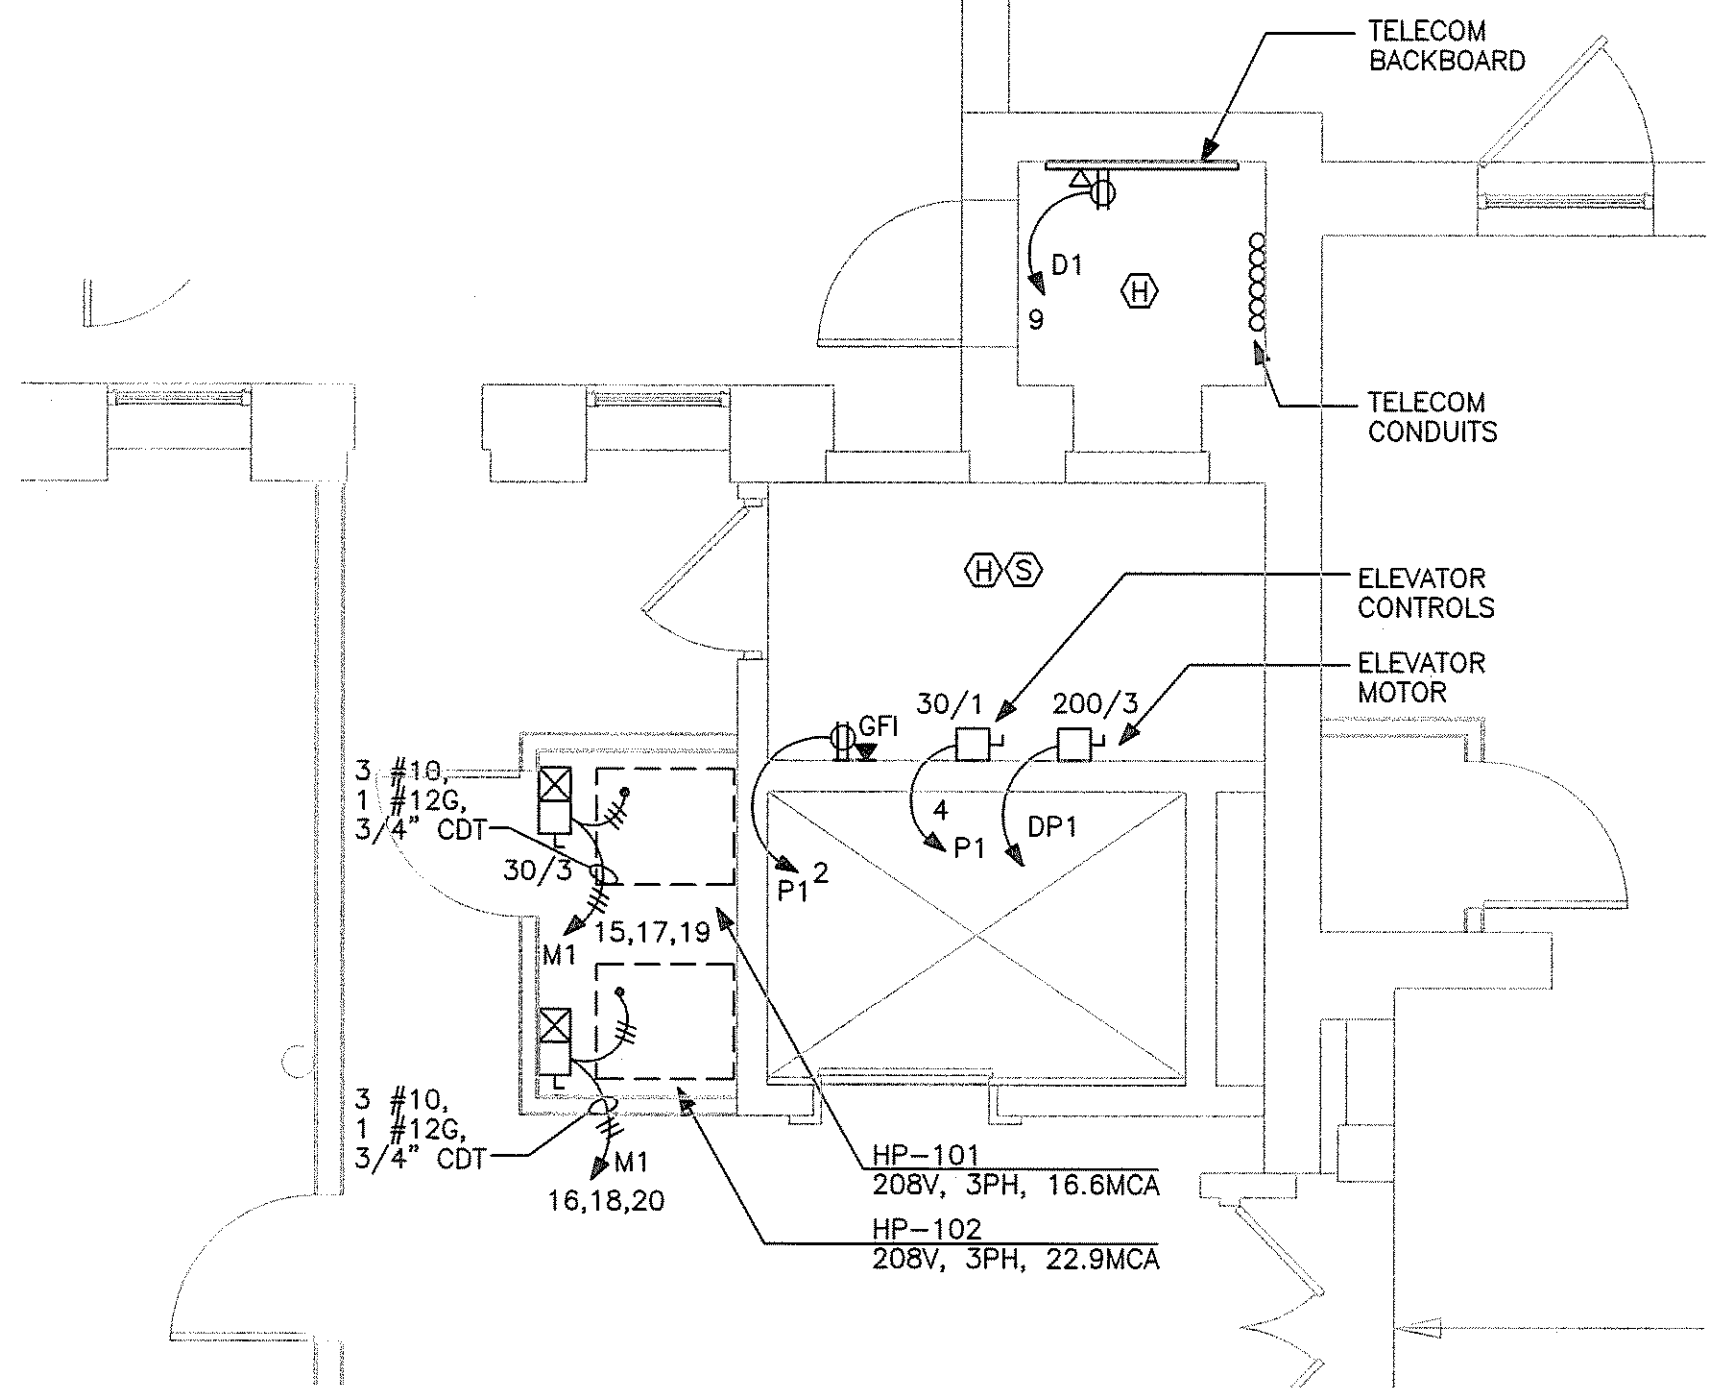


TELE/DATA 103A & EMR 104 & TECH 105
1/4" = 1'-0"


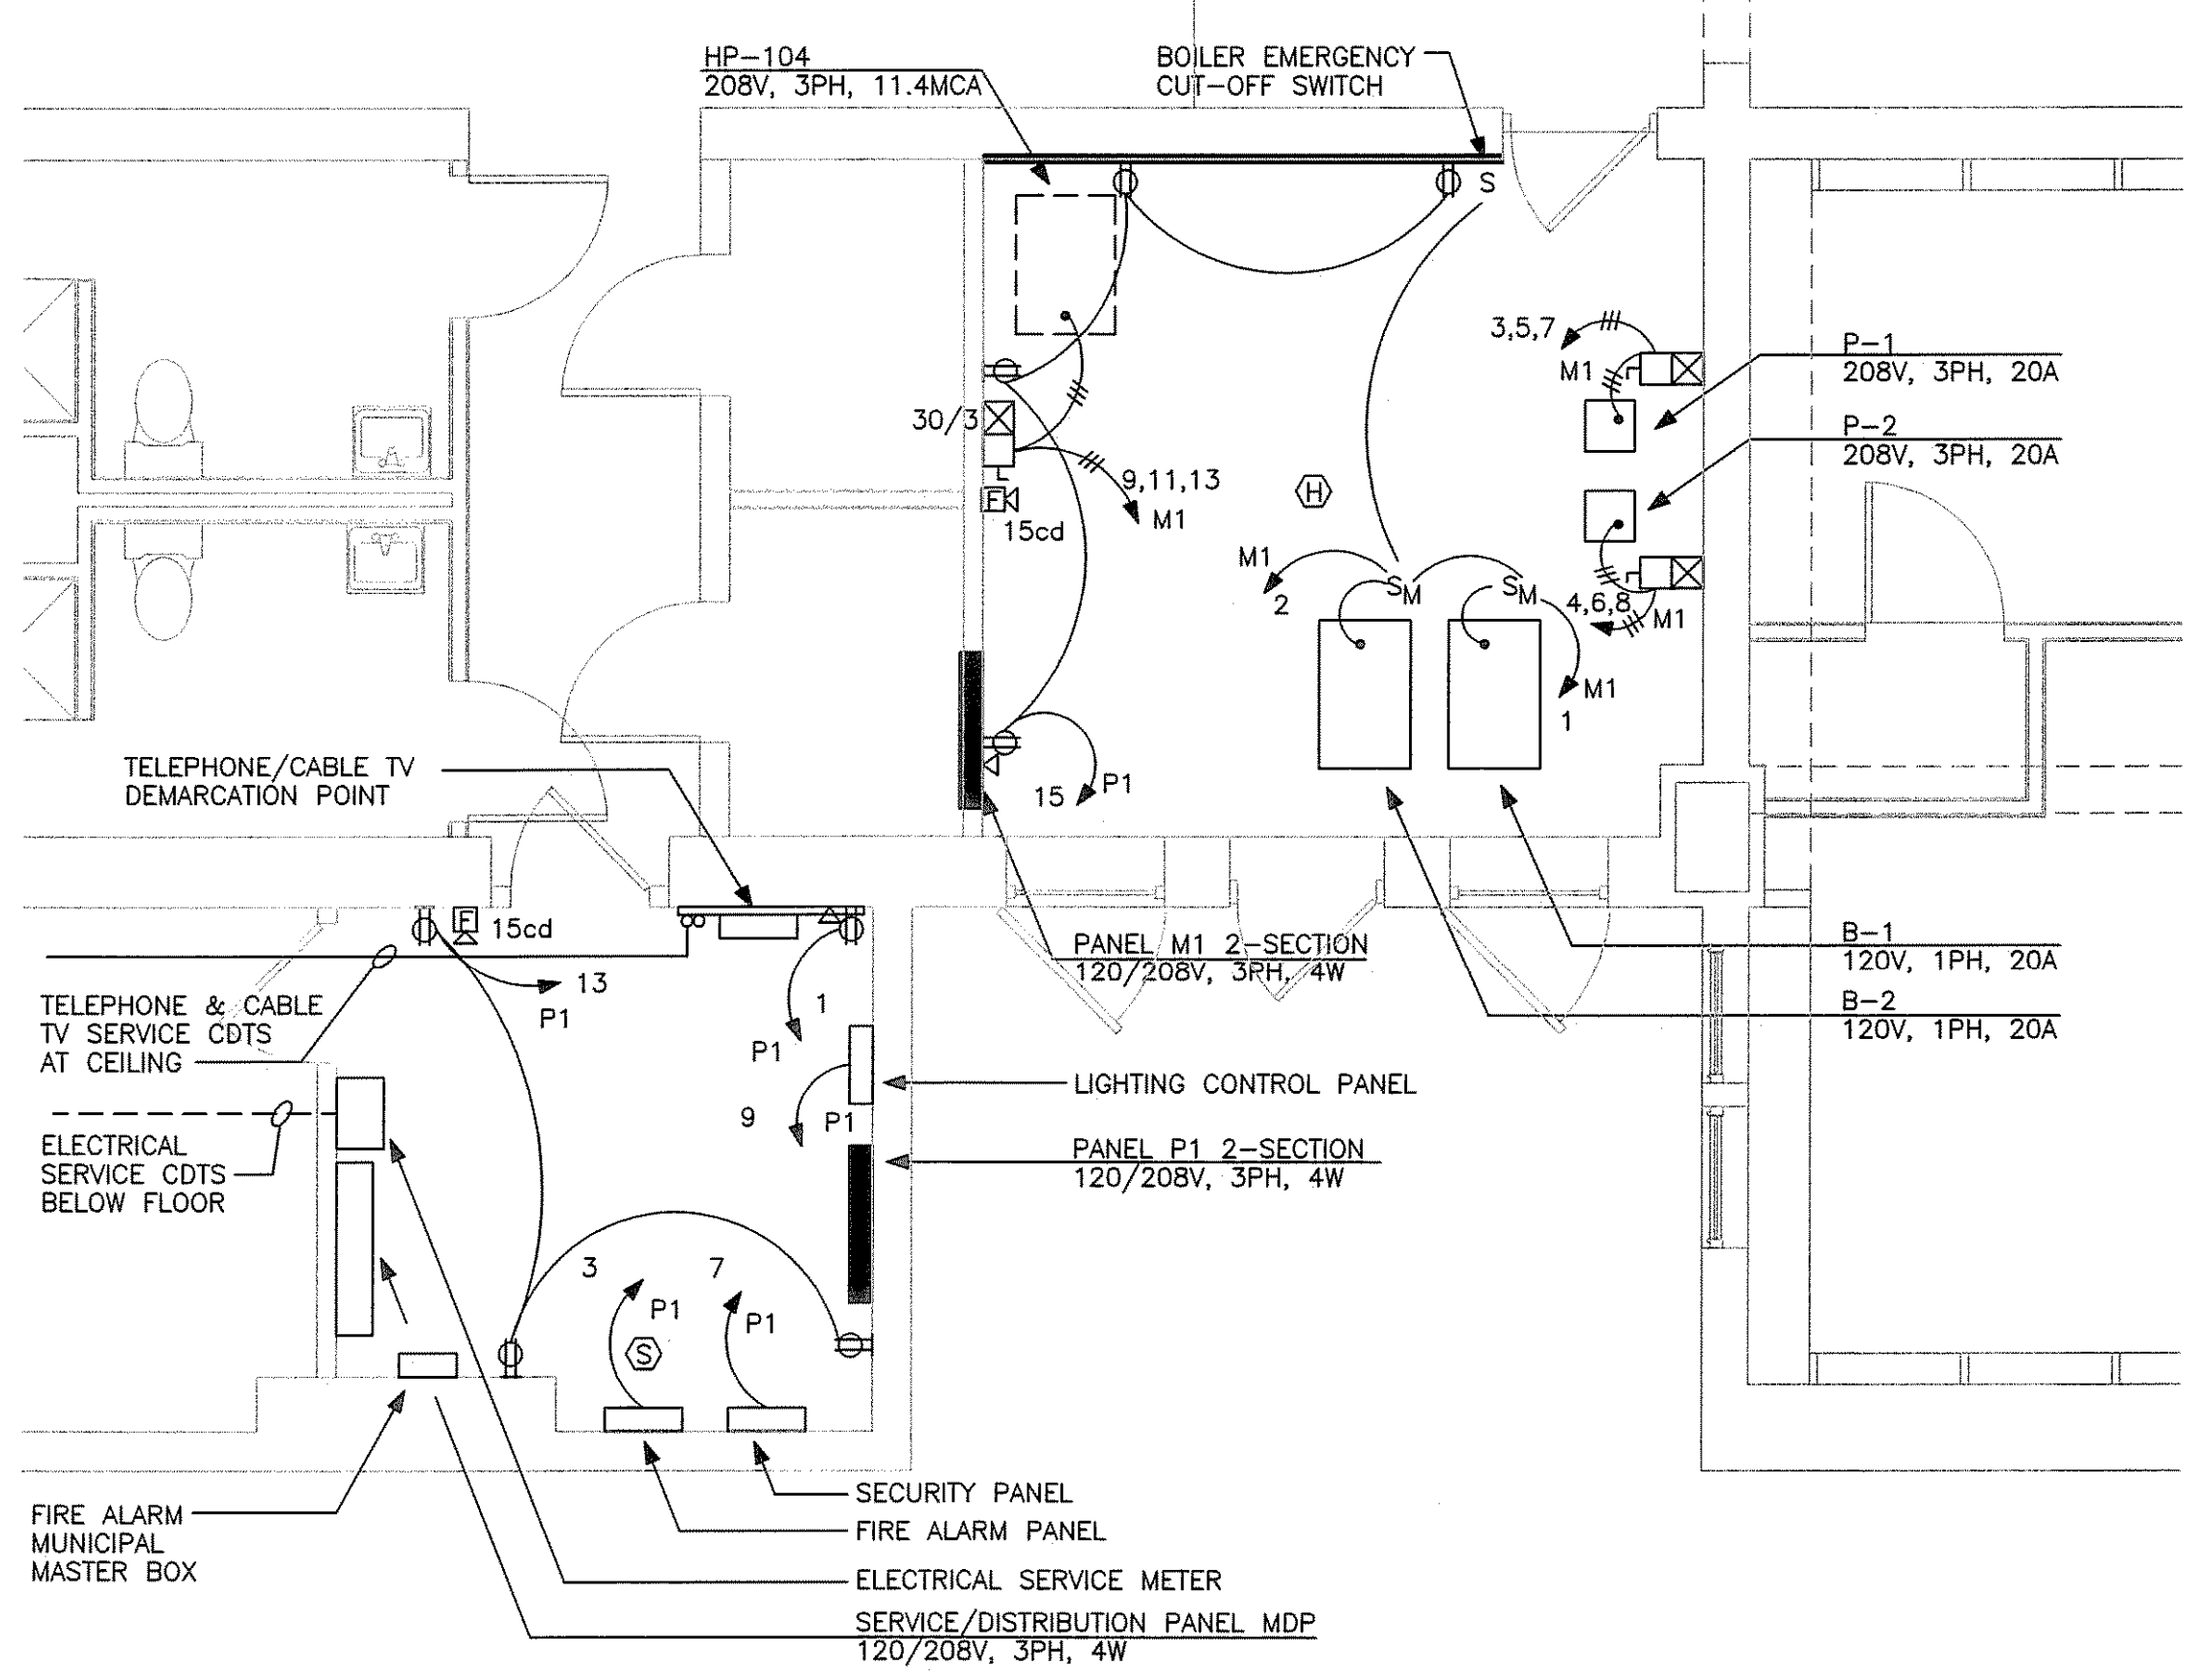


MECHANICAL 122 & ELECTRICAL 126
1/4" = 1'-0"

- NOTES:
1. WHERE NECESSARY, INSTALL SURFACE METAL RACEWAY AT THE BASE OF MILLWORK.
2. VERIFY THE EXACT LOCATION OF ALL MECHANICAL EQUIPMENT PRIOR TO ROUGH-IN.

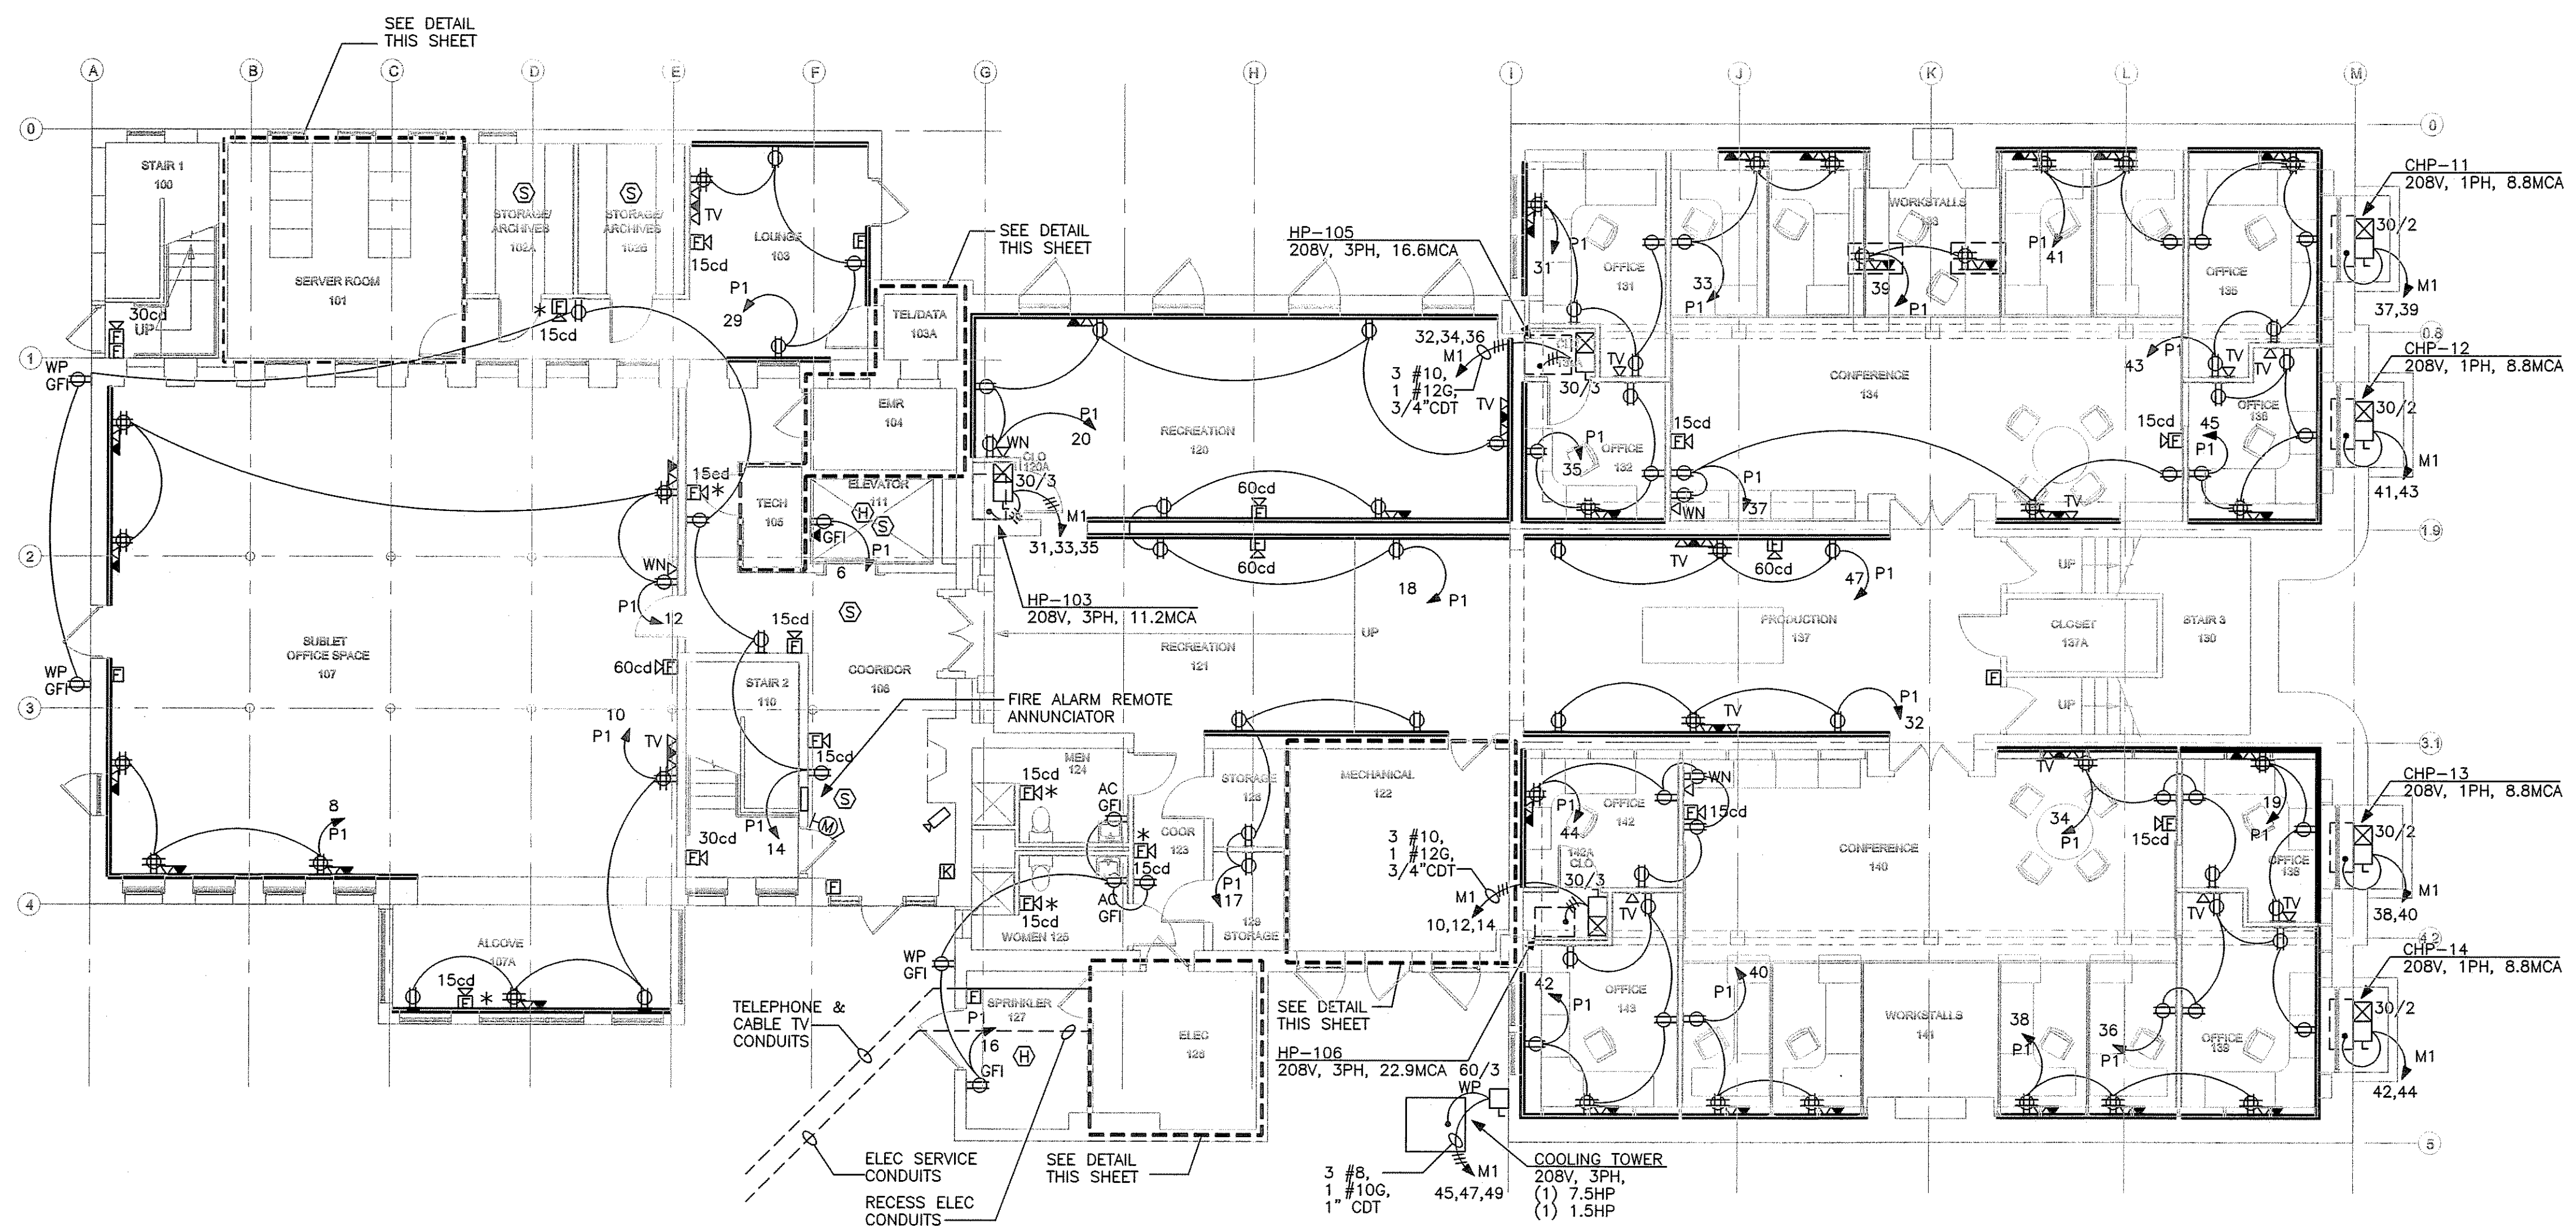

FIRST FLOOR
1/8" = 1'-0"

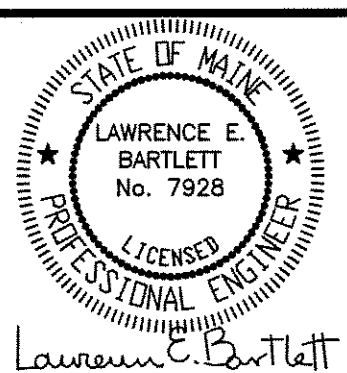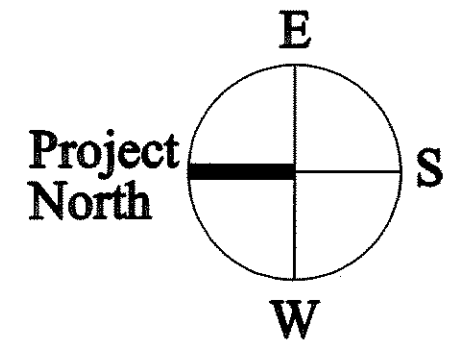

Prepared For:
NORTHLAND ENTERPRISES, LLC
ONE CITY CENTER - 4TH FLOOR
PORTLAND, ME 04101

Consulting Engineer:
ARCHETYPE architects
48 Union Wharf Portland, Maine 04101
(207) 772-6022 Fax (207) 772-4056

Architect:
The BAXTER LIBRARY
619 CONGRESS STREET
PORTLAND, MAINE

Date: 4 Sept. 2009
Scale: As Noted
FIRST FLOOR POWER PLAN

E1.01