

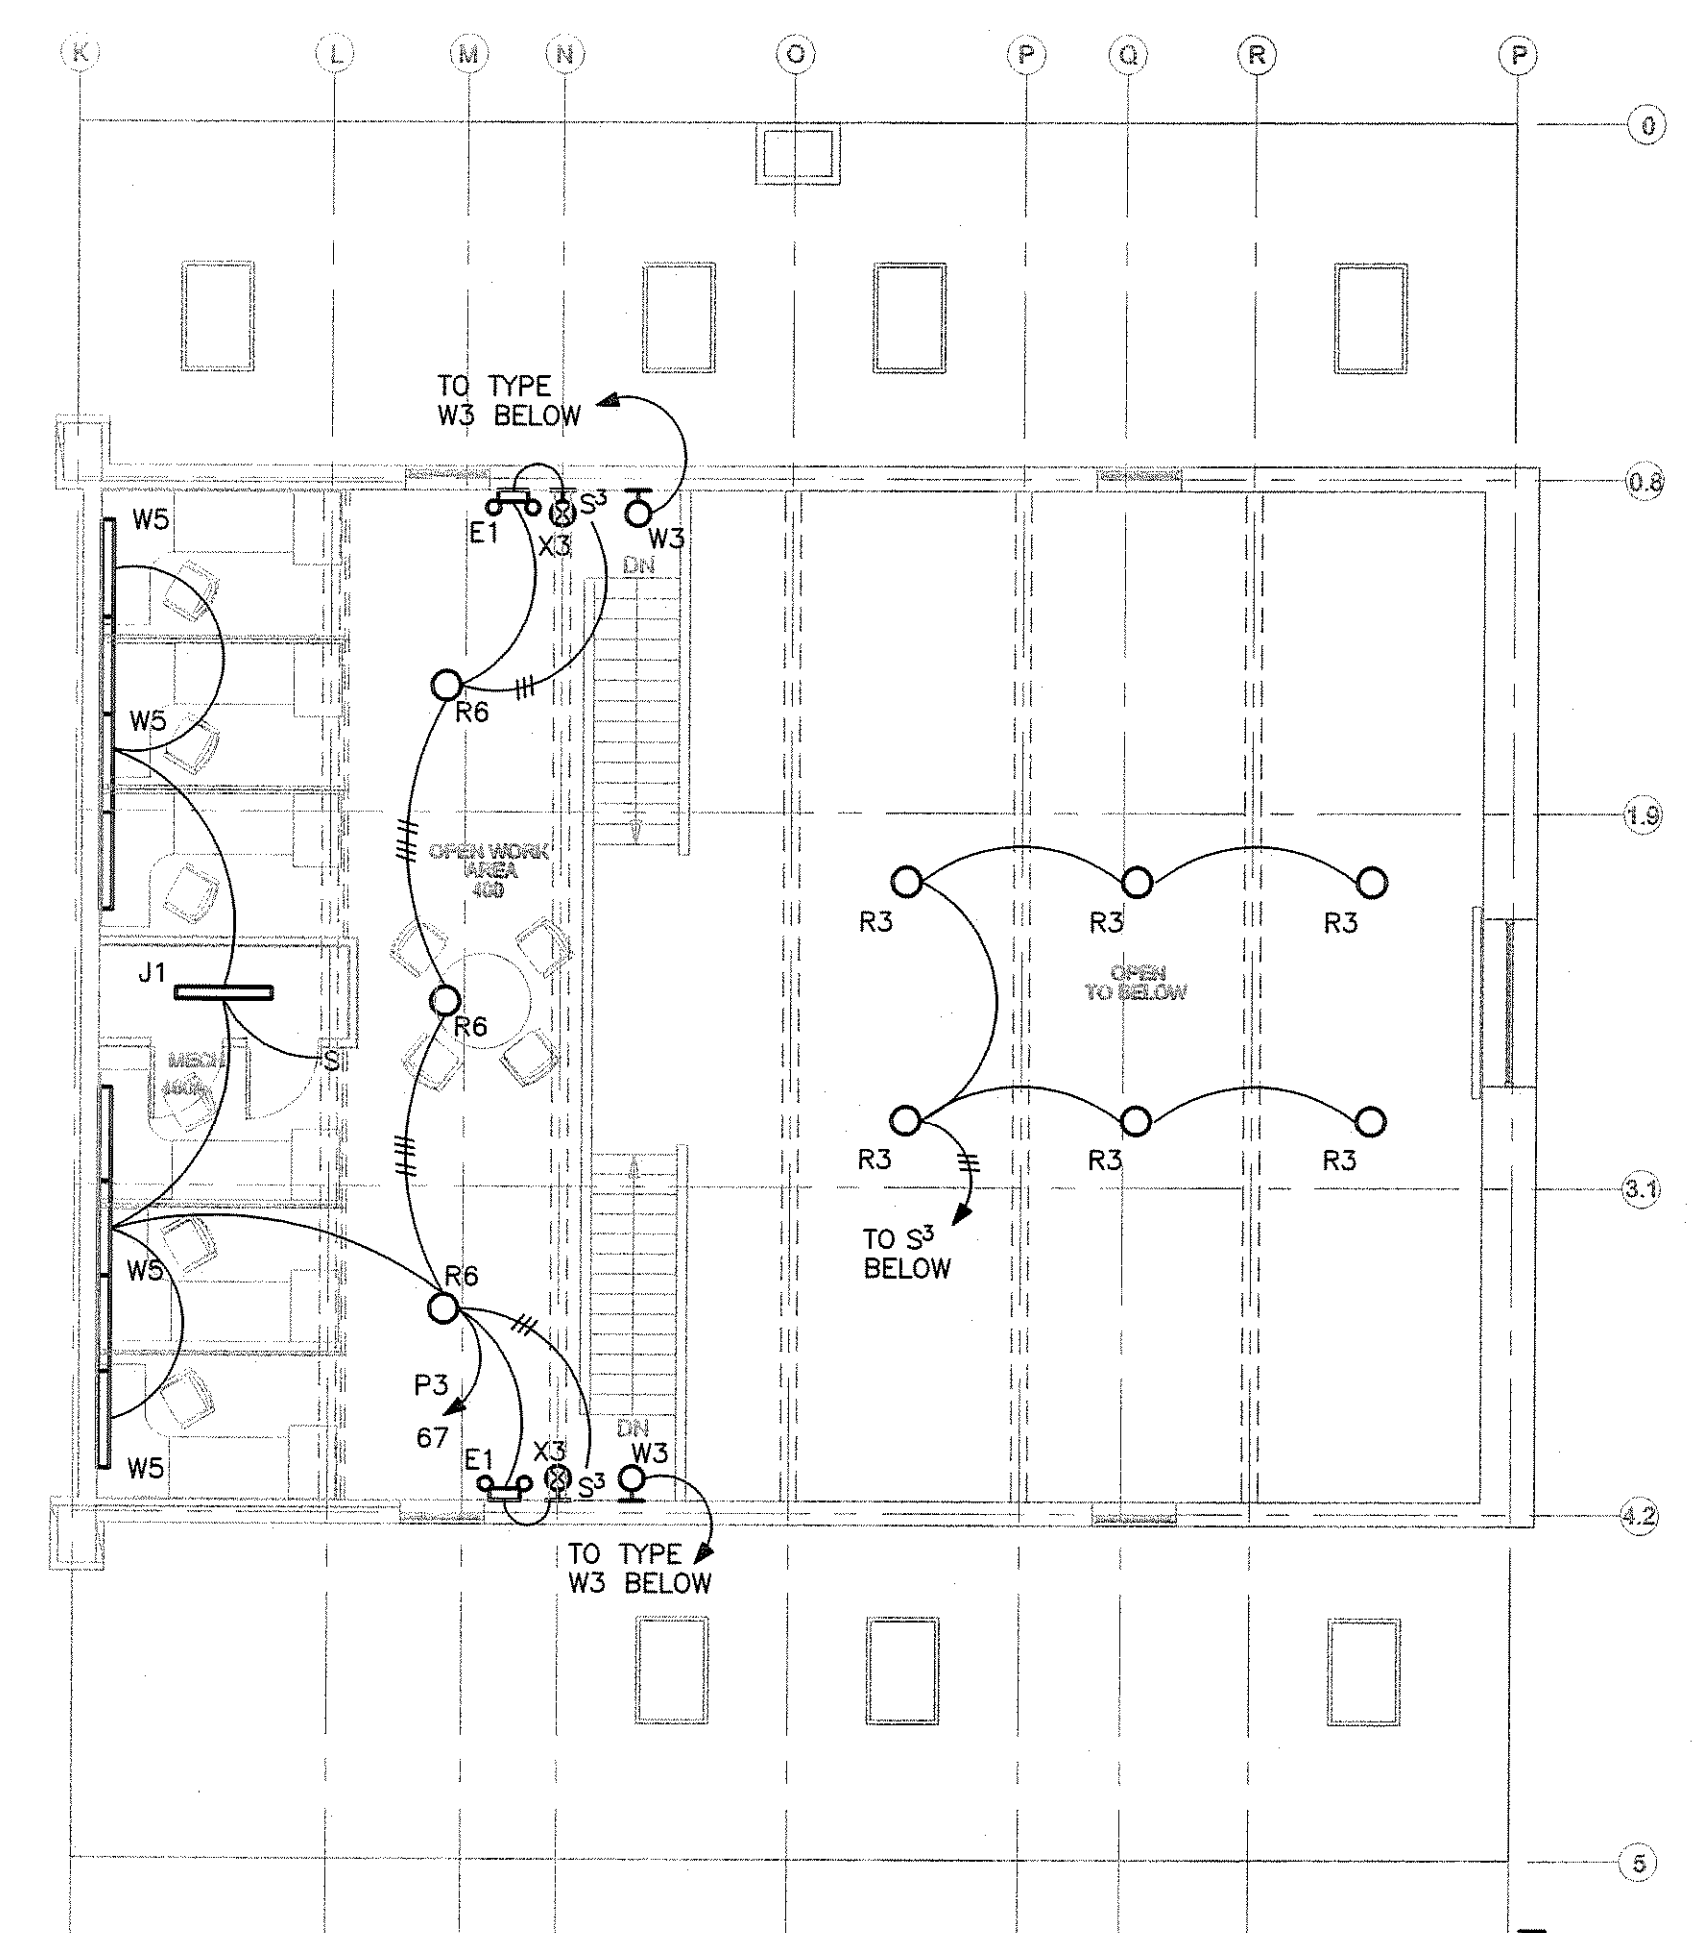


THIRD FLOOR
1/8" = 1'-0"

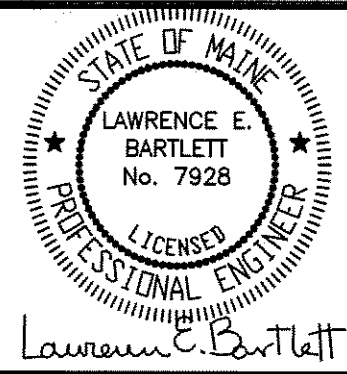

MEZZANINE
1/8" = 1'-0"

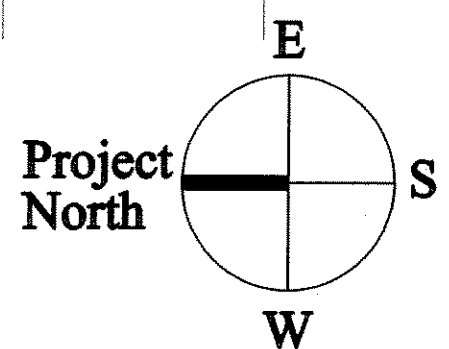

Prepared For:
NORTHLAND ENTERPRISES, LLC
ONE CITY CENTER - 4TH FLOOR
PORTLAND, ME 04101

Consulting Engineer:
ARCHETYPE architects
48 Union Wharf Portland, Maine 04101
(207) 772-6022 Fax (207) 772-4056

Project:
The BAXTER LIBRARY
619 CONGRESS STREET
PORTLAND, MAINE

Revisions:

Date: 4 Sept. 2009
Scale: 1/8" = 1'-0"
THIRD FL & MEZZANINE LIGHTING PLAN

E2.03