
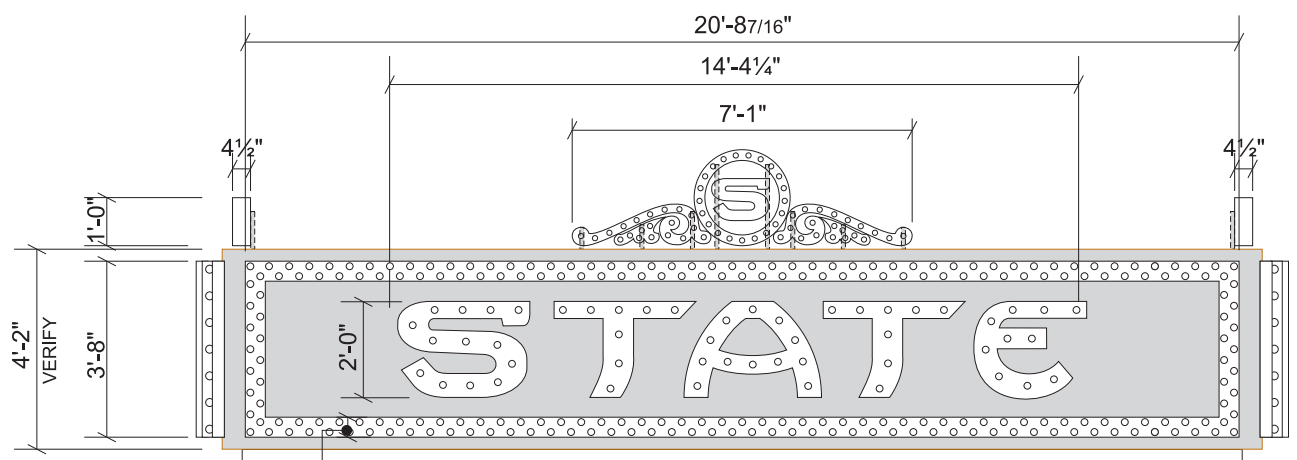


4 PLAN
SCALE: 1/4" = 1'-0"

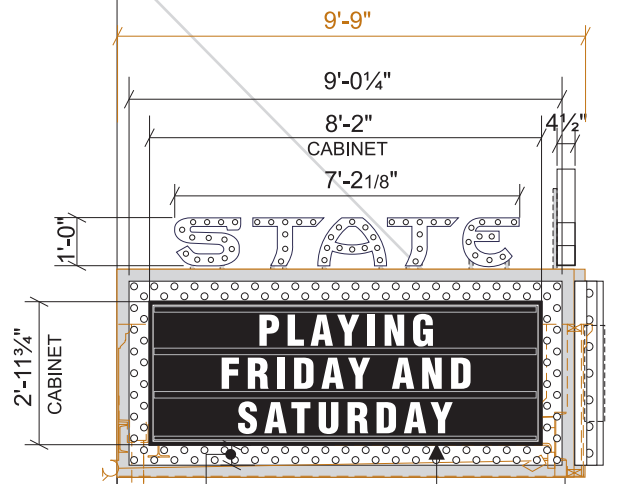

PERIMETER DOWN-LIGHTING WITH-IN FABRICATED CHANNEL SEE REFLECTED CEILING PLAN

FABRICATED LETTERS (4 1/2" DEEP) TOP ENDS AND TOP SCROLL, FABRICATED LETTERS ON FACE (5" DEEP) (PROUD OF BORDERS), ILLUMINATED WITH BULBS, ALL PAINTED BLACK (OUTSIDE) - WHITE (INSIDE),

FACE BORDERS (4 1/2" DEEP), DOWN-LIGHTING BORDER (3 1/2" DEEP), ALL PAINTED BLACK (OUTSIDE) - WHITE (INSIDE), ILLUMINATED WITH BULBS, WIRED TO ALLOW 'CHASING' IN FUTURE,

(2) CHANGEABLE MESSAGE SIGNS - 5" DEEP B/F ALUM. CABINET RECESSED INTO MARQUEE BKG., 1 1/4" INSIDE RETAINERS, WHITE 'LED' ILLUMINATION, 3/16" WHITE ACRYLIC FACES, BLACK (ZIP-LIGHT TRACK AND LETTERS) FOR (3) ROWS 8" TEXT,

MOUNTED TO EXISTING MARQUEE (VERIFY ALL FINISHED MARQUEE DIMENSIONS)
SEE DETAIL PAGES

ILLUMINATED GRAPHICS FOR MARQUEE - DETAILS
SCALE: 1/4" = 1'-0"

END VIEW - SAME DETAIL ON RIGHT END

PERMIT DRAWING

STATE THEATER
3184.2

LOCATION:	609 CONGRESS STREET
	PORTLAND, MAINE
DRAWING NO.:	2 OF 5
DRAWN BY:	PFAT/BK REP:PB
DATE:	06.19.2017
QUOTE:	@1824
GEN REF.:	



NEOKRAFT SIGNS INC. NEOKRAFT.COM
686 MAIN STREET T:207.782.9654 F:782.0009
LEWISTON, MAINE 04240 1.800.339.2258

© COPYRIGHT 2016, BY NEOKRAFT SIGNS, INC.