







EXISTING CONDITION PHOTOGRAPHS  
SCALE: NTS

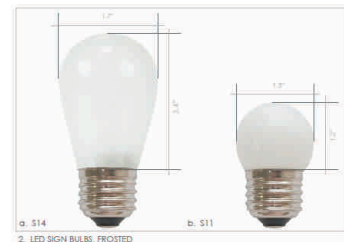


1. S14  
2. LED SIGN BULB, FROSTED

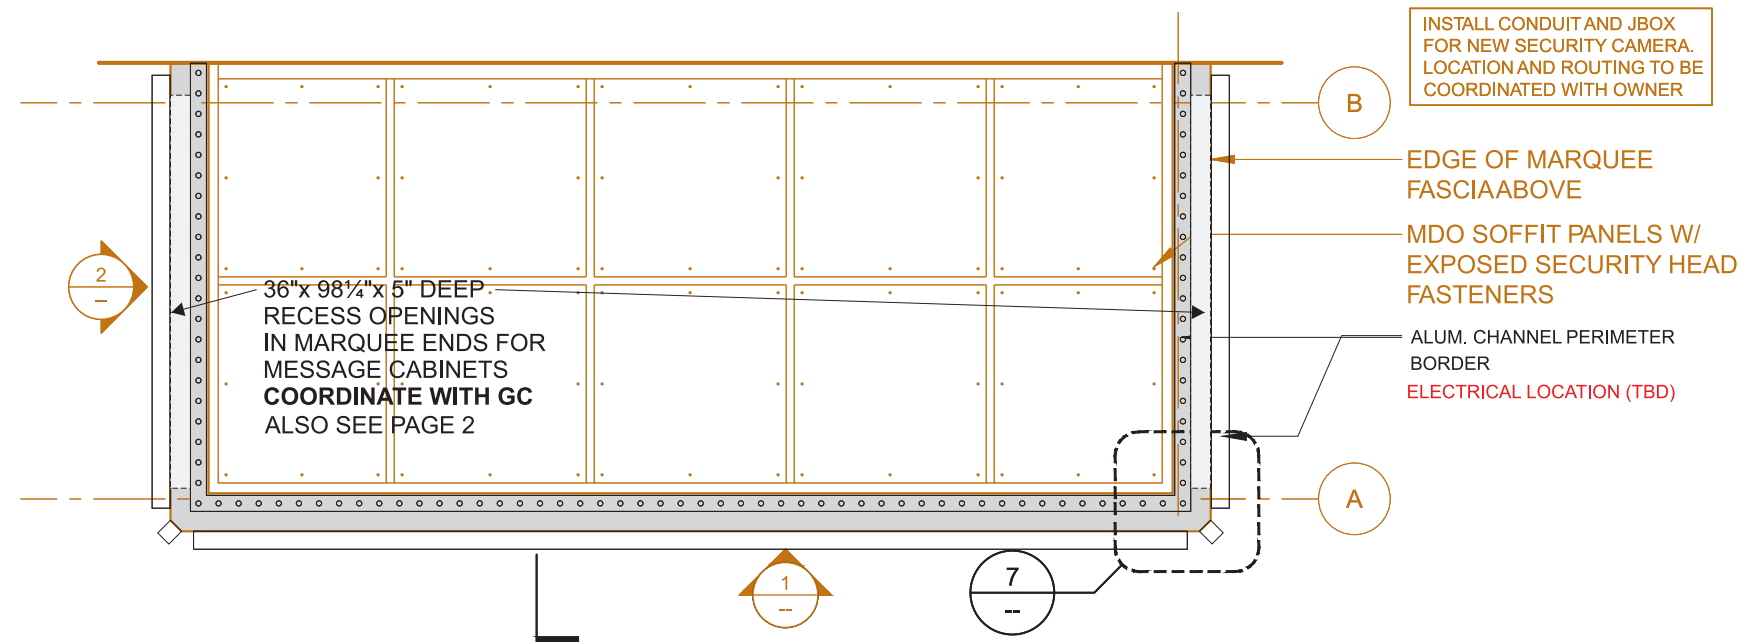

6 REFLECTED CEILING PLAN  
SCALE: 1/4" = 1'-0"

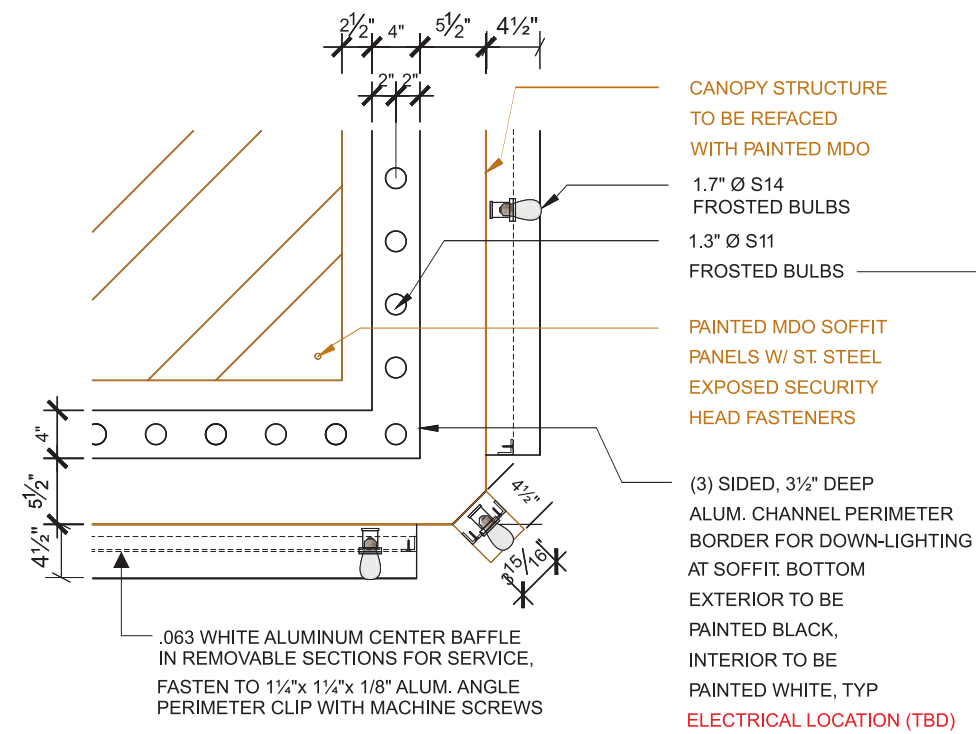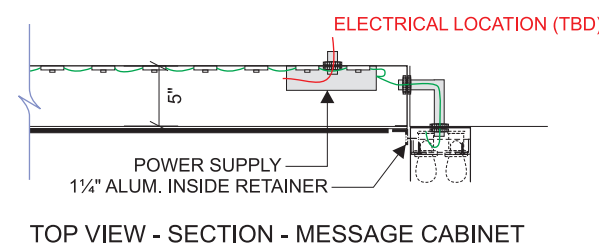

7 REFLECTED CEILING PLAN DETAIL  
SCALE: 3/4" = 1'-0"

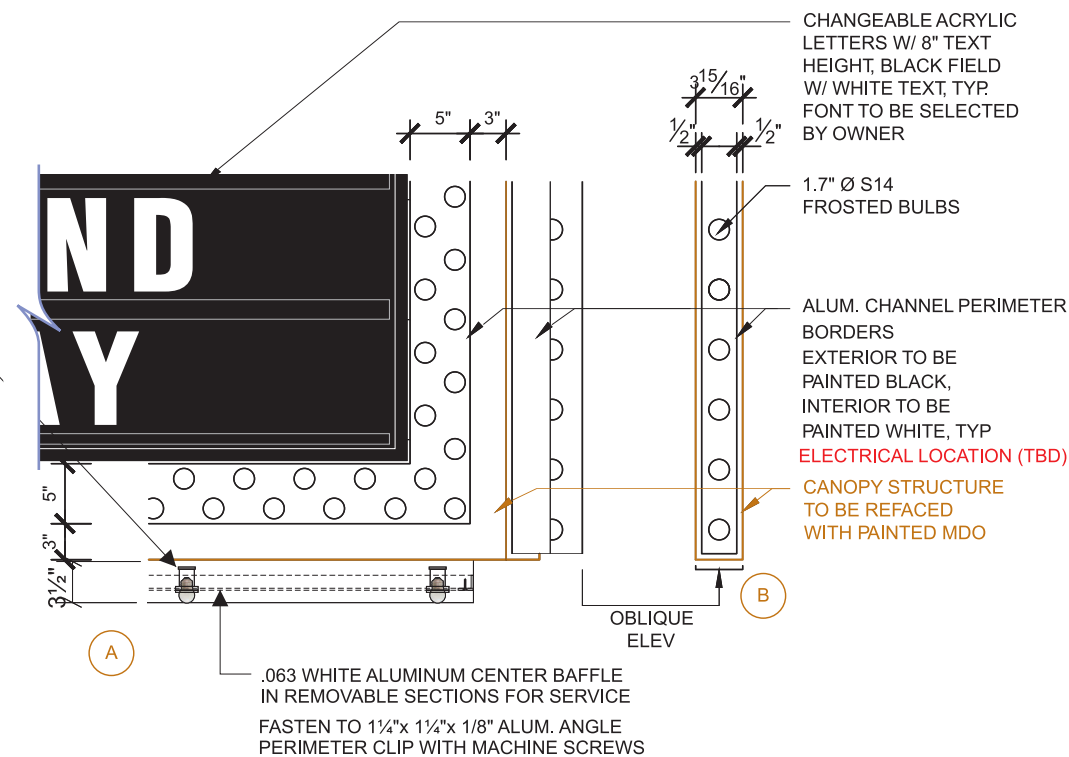

5 ELEVATION DETAIL  
SCALE: 3/4" = 1'-0"

PERMIT DRAWING

STATE THEATER  
3184.2

LOCATION:	609 CONGRESS STREET
	PORTLAND, MAINE
DRAWING NO.:	3 OF 5
DRAWN BY:	PFAT/BK REP:PB
DATE:	06.19.2017
QUOTE:	@1824
GEN REF.:	



NEOKRAFT SIGNS INC. NEOKRAFT.COM  
686 MAIN STREET T:207.782.9654 F:782.0009  
LEWISTON, MAINE 04240 1.800.339.2258

© COPYRIGHT 2016, BY NEOKRAFT SIGNS, INC.