


PROGRESS PRINT
NOT FOR CONSTRUCTION



Prepared For:
**747 CONGRESS
LLC**

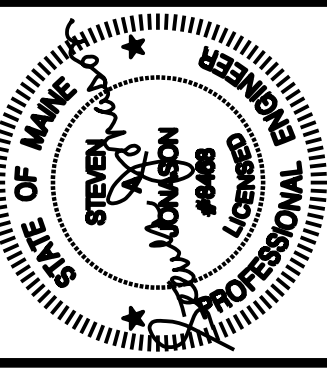

Consulting Engineer:
**ARCHETYPE
architects**
48 Union Wharf Portland, Maine 04101
(207) 772-6022 Fax (207) 772-4056


Architect:
FRANCIS INN
749 CONGRESS ST
PORTLAND, ME 04102

Revisions:	07/06/16 PRICING
	07/18/16 PERMIT SET

Date:	07/18/2016
Scale:	As Noted

**THIRD FLOOR
LIGHTING PLAN**

E1.3

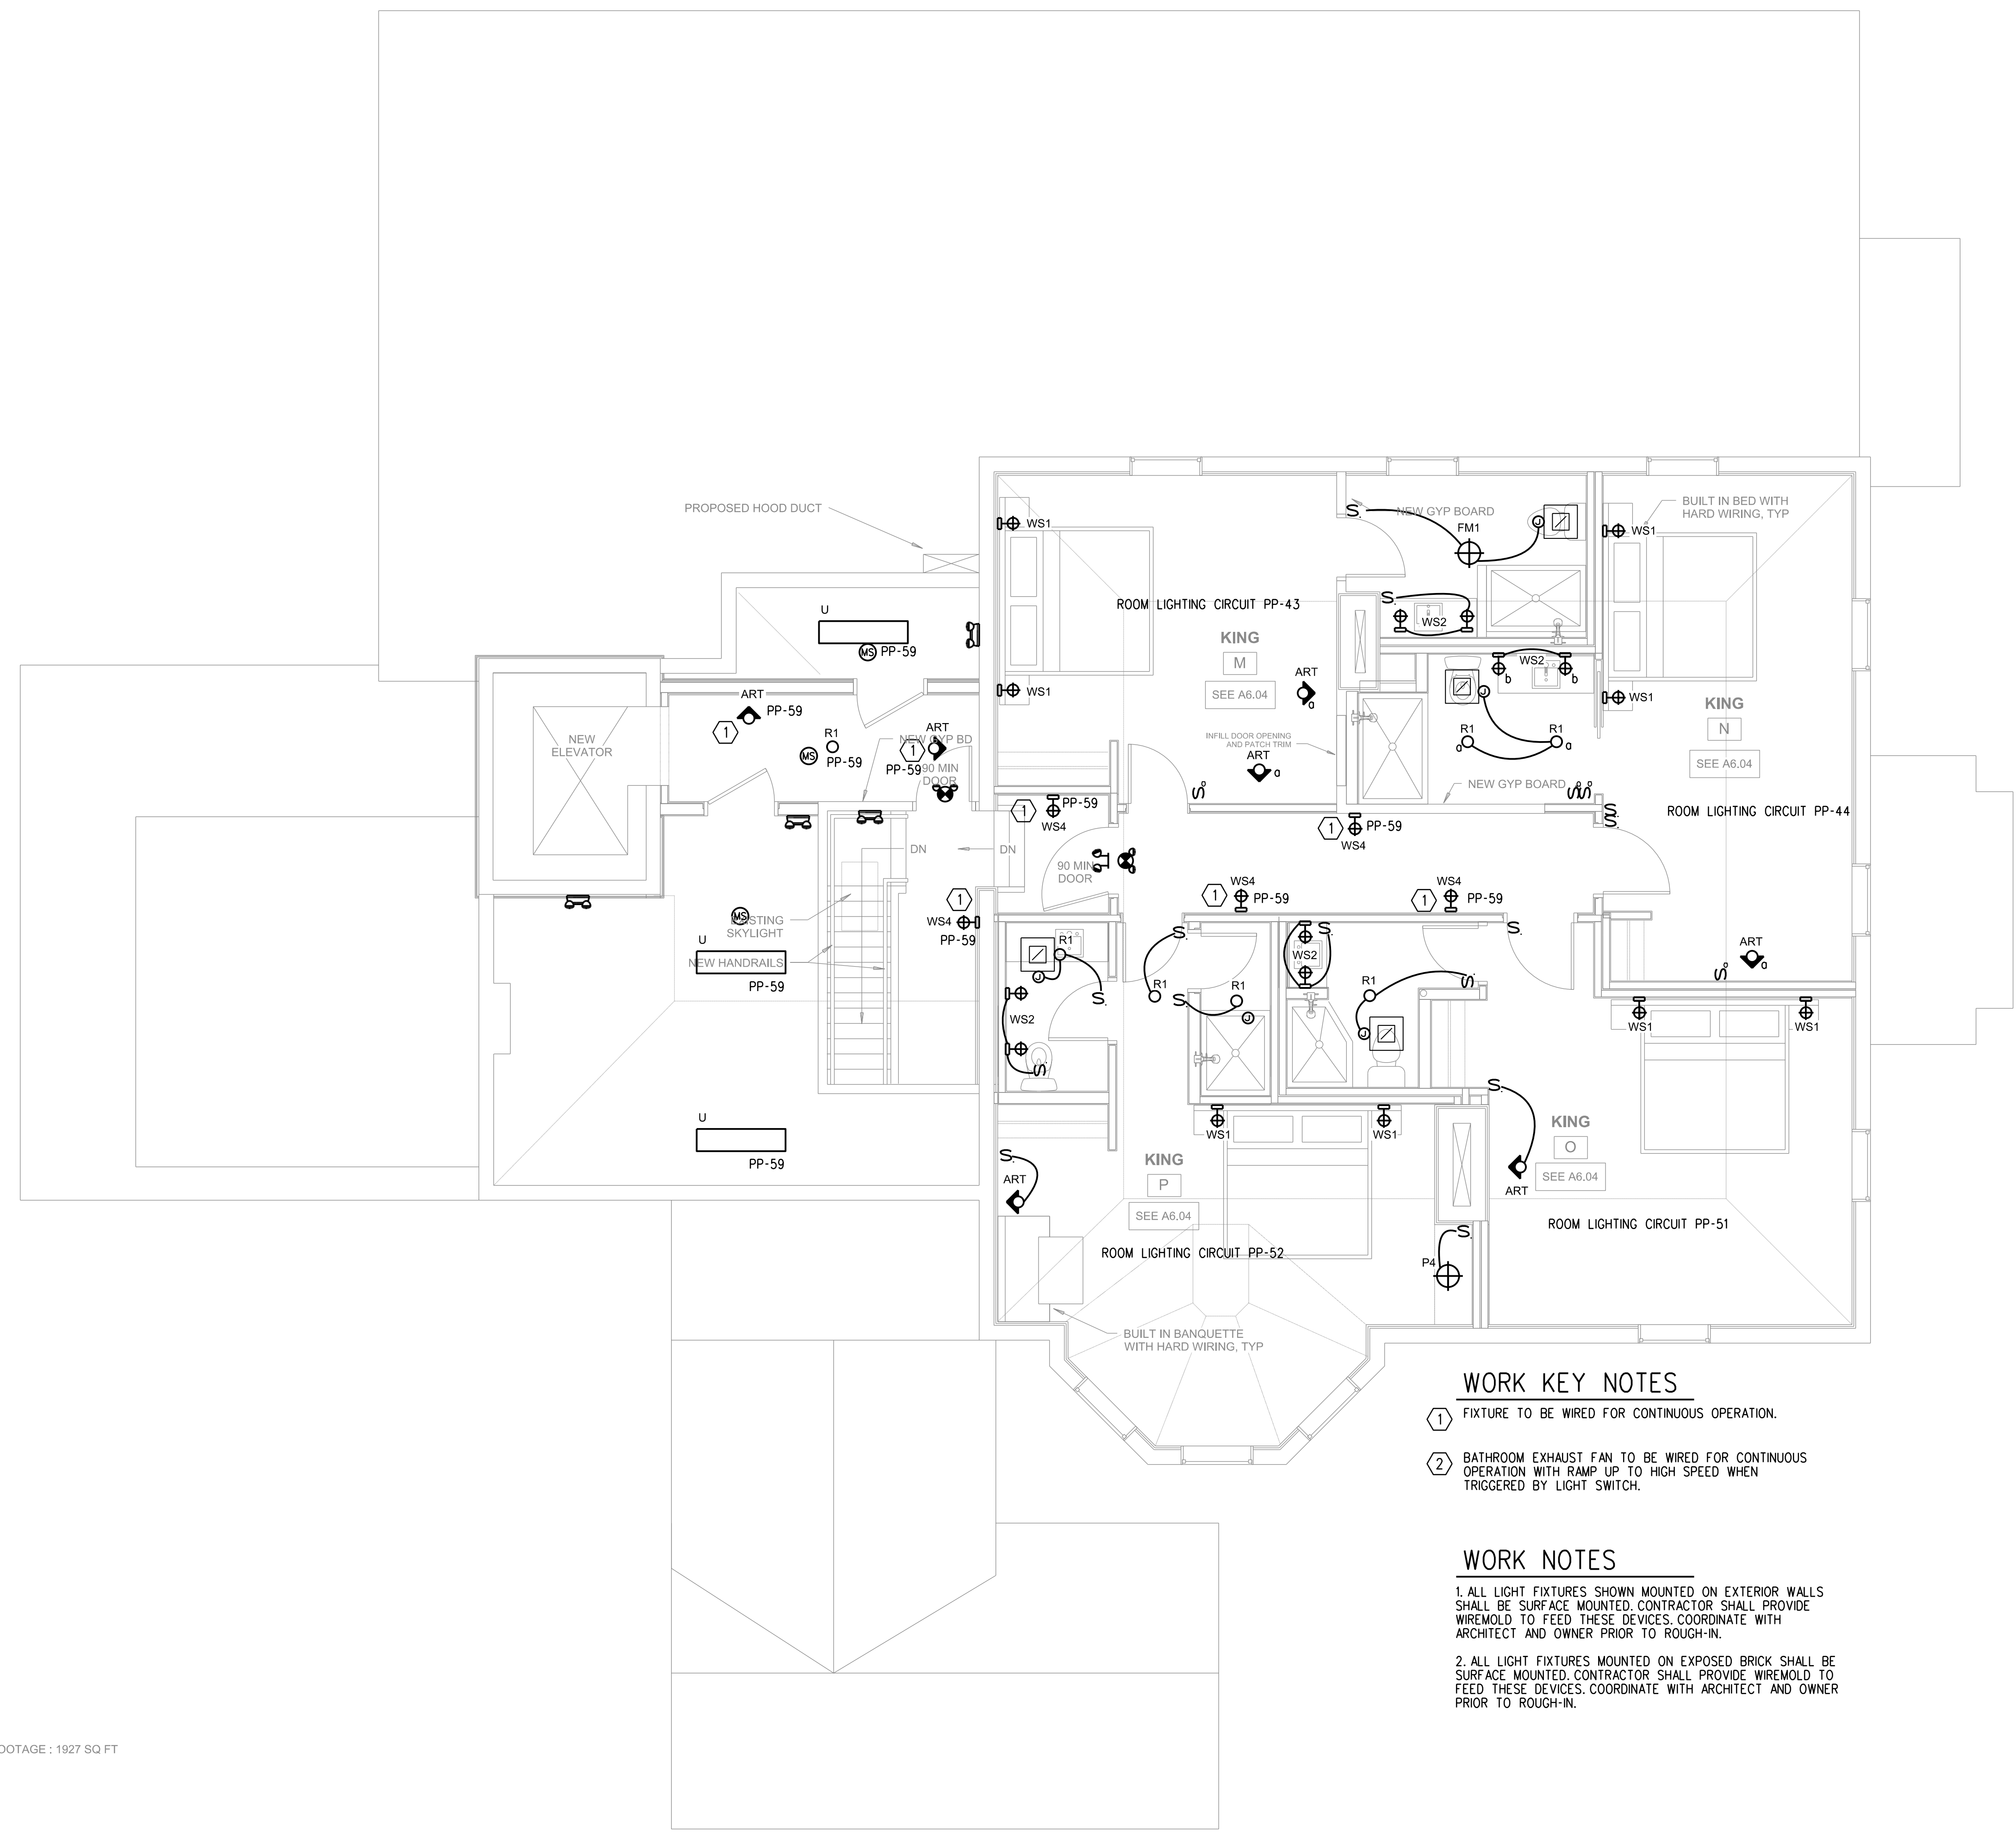

30 FOOTAGE : 1927 SQ FT

THIRD FLOOR PLAN
SCALE: 1/4"=1'-0"