


COMMERCIAL HOOD WIRING DETAIL

SCALE: NONE

NOTE: OUTLETS UNDER HOOD SHALL BE SUPPLIED BY SHUNT TRIP CIRCUIT BREAKERS

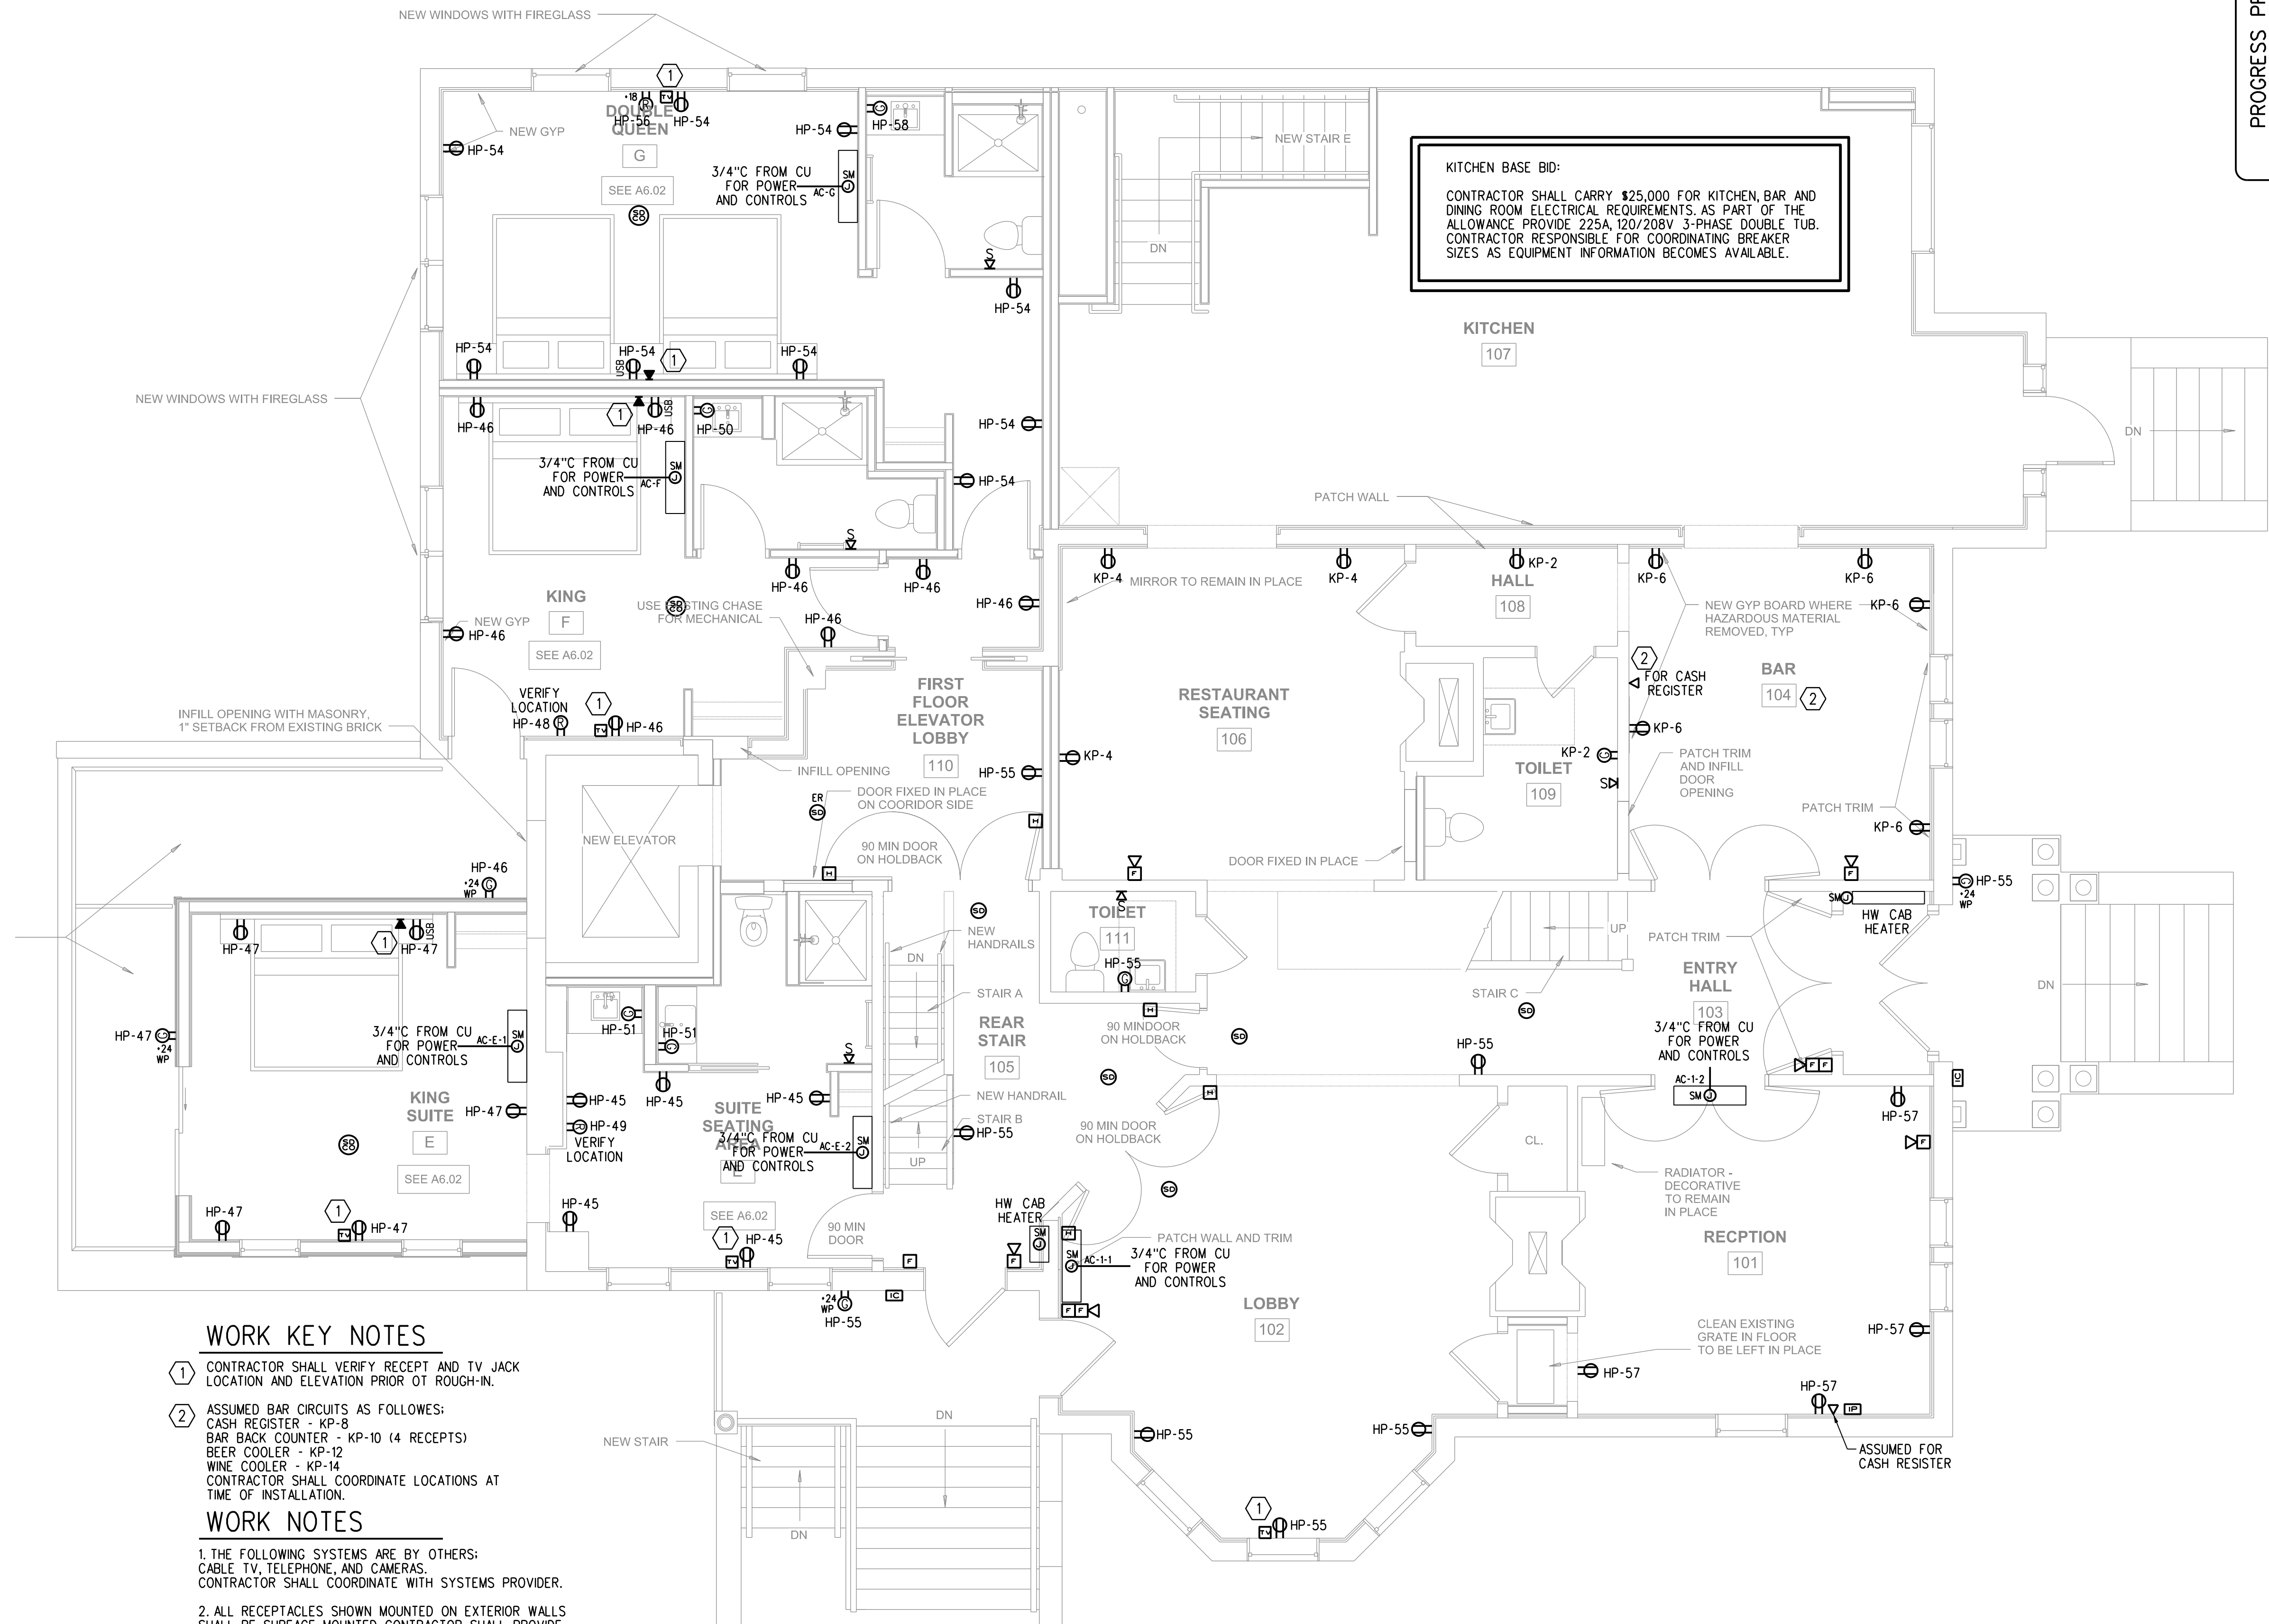

WORK KEY NOTES

- ① CONTRACTOR SHALL VERIFY RECEPT AND TV JACK LOCATION AND ELEVATION PRIOR TO ROUGH-IN.
- ② ASSUMED BAR CIRCUITS AS FOLLOWS:
CASH REGISTER - KP-8
BAR BACK COUNTER - KP-10 (4 RECEPTS)
BEER COOLER - KP-12
WINE COOLER - KP-14
CONTRACTOR SHALL COORDINATE LOCATIONS AT TIME OF INSTALLATION.

WORK NOTES


- 1. THE FOLLOWING SYSTEMS ARE BY OTHERS: CABLE TV, TELEPHONE, AND CAMERAS. CONTRACTOR SHALL COORDINATE WITH SYSTEMS PROVIDER.
- 2. ALL RECEPTACLES SHOWN MOUNTED ON EXTERIOR WALLS SHALL BE SURFACE MOUNTED. CONTRACTOR SHALL PROVIDE WIREMOLD TO FEED THESE DEVICES. COORDINATE WITH ARCHITECT AND OWNER PRIOR TO ROUGH-IN.
- 3. ALL RECEPTACLES SHOWN MOUNTED ON EXPOSED BRICK SHALL BE SURFACE MOUNTED. CONTRACTOR SHALL PROVIDE WIREMOLD TO FEED THESE DEVICES. COORDINATE WITH ARCHITECT AND OWNER PRIOR TO ROUGH-IN.

3Q FOOTAGE : 4080 SQ FT
OOTAGE - 2435 SQ FT
OOTAGE - 1645 SQ FT


FIRST FLOOR PLAN

SCALE: 1/4"=1'-0"

PROGRESS PRINT
NOT FOR CONSTRUCTION

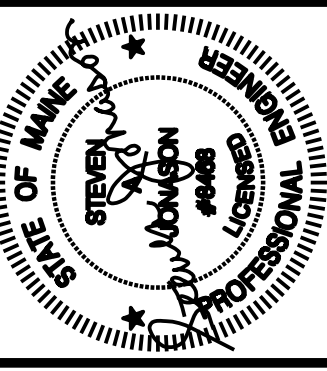

Prepared For:
747 CONGRESS LLC

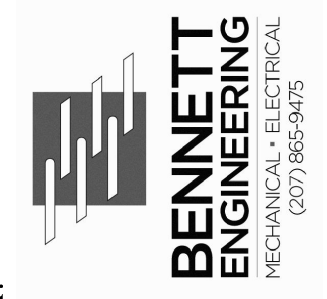

Consulting Engineer:



Architect:
FRANCIS INN
749 CONGRESS ST
PORTLAND, ME 04102

Project:

Revisions:	07/06/16 PRICING
	07/18/16 PERMIT SET

Date: 07/18/2016

Scale: As Noted

FIRST FLOOR
POWER PLAN

E2.1