


**COMMERCIAL HOOD WIRING DETAIL**

SCALE: NONE

NOTE: OUTLETS UNDER HOOD SHALL BE SUPPLIED BY SHUNT TRIP CIRCUIT BREAKERS

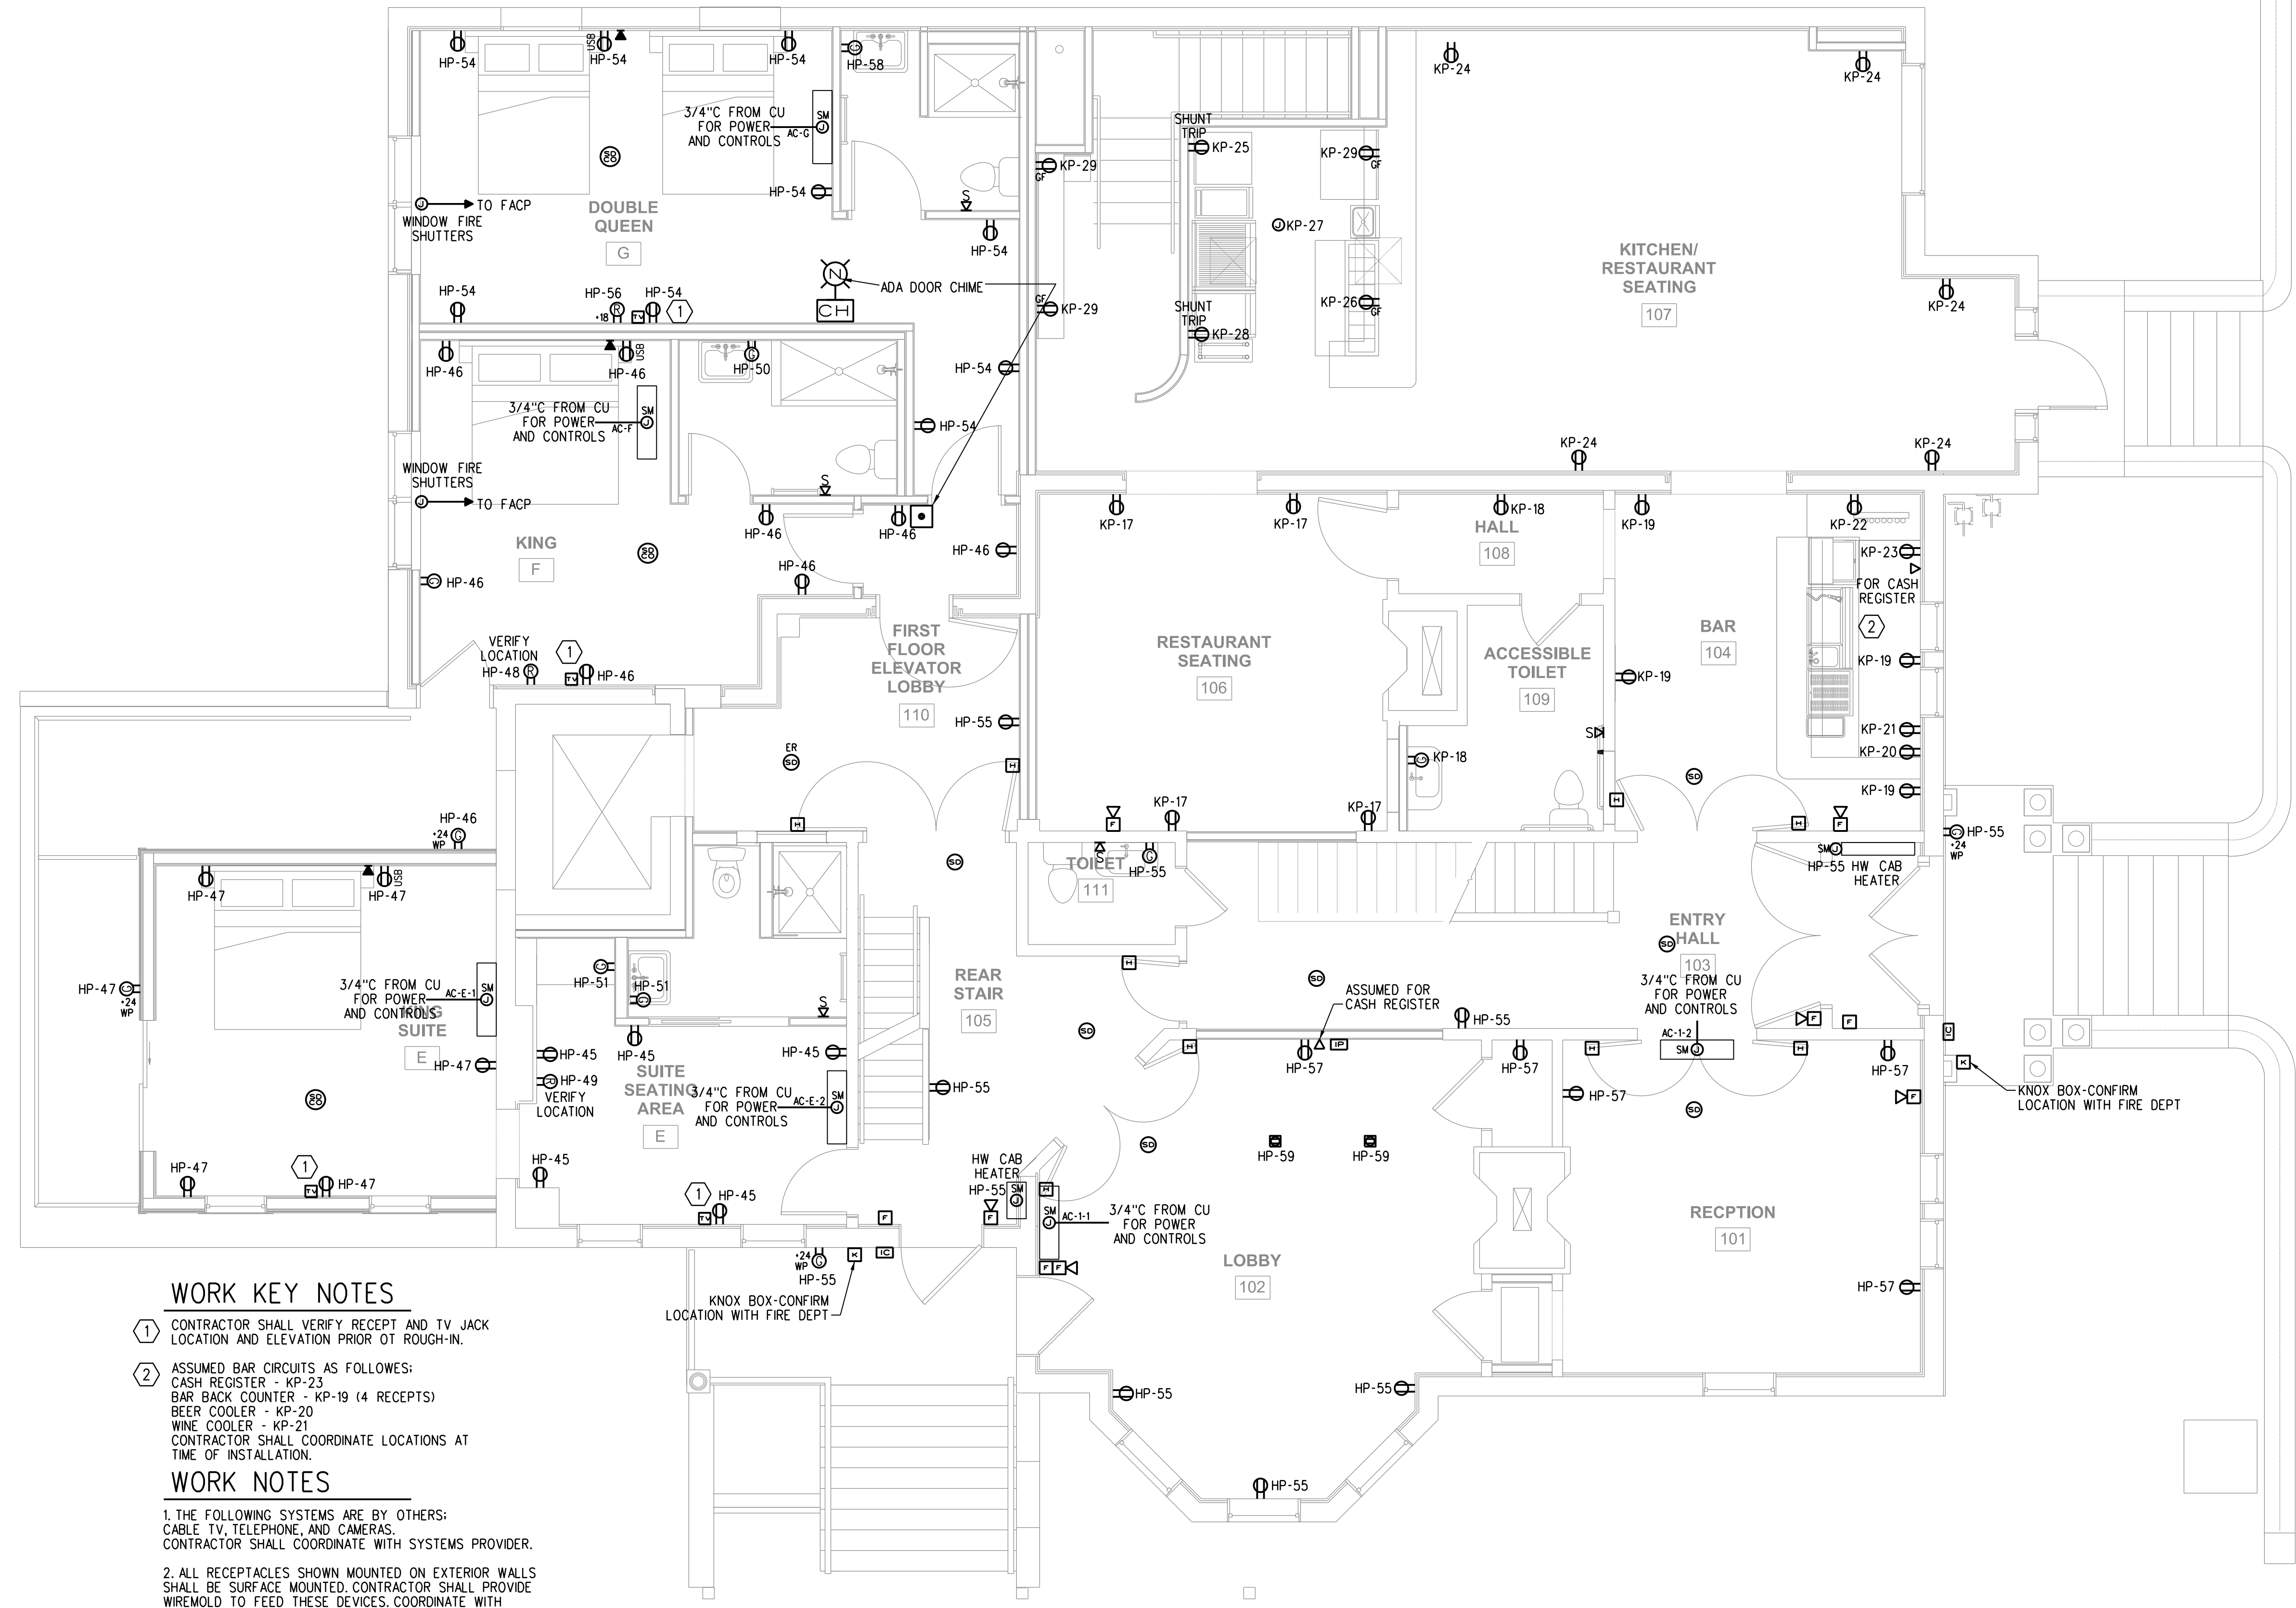

**WORK KEY NOTES**


- ① CONTRACTOR SHALL VERIFY RECEPT AND TV JACK LOCATION AND ELEVATION PRIOR TO ROUGH-IN.
- ② ASSUMED BAR CIRCUITS AS FOLLOWS:  
CASH REGISTER - KP-23  
BAR BACK COUNTER - KP-19 (4 RECEIPTS)  
BEER COOLER - KP-20  
WINE COOLER - KP-21  
CONTRACTOR SHALL COORDINATE LOCATIONS AT TIME OF INSTALLATION.

**WORK NOTES**

- 1. THE FOLLOWING SYSTEMS ARE BY OTHERS:  
CABLE TV, TELEPHONE, AND CAMERAS.  
CONTRACTOR SHALL COORDINATE WITH SYSTEMS PROVIDER.
- 2. ALL RECEPTACLES SHOWN MOUNTED ON EXTERIOR WALLS SHALL BE SURFACE MOUNTED. CONTRACTOR SHALL PROVIDE WIREMOLD TO FEED THESE DEVICES. COORDINATE WITH ARCHITECT AND OWNER PRIOR TO ROUGH-IN.
- 3. ALL RECEPTACLES SHOWN MOUNTED ON EXPOSED BRICK SHALL BE SURFACE MOUNTED. CONTRACTOR SHALL PROVIDE WIREMOLD TO FEED THESE DEVICES. COORDINATE WITH ARCHITECT AND OWNER PRIOR TO ROUGH-IN.

**FIRST FLOOR PLAN**

SCALE: 1/4"=1'-0"

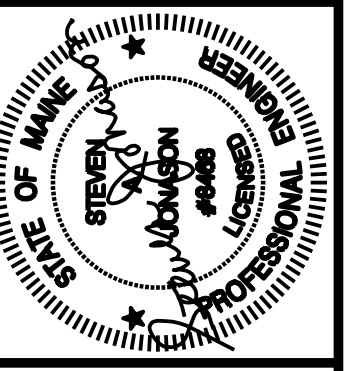

Prepared For:  
**747 CONGRESS LLC**



Consulting Engineer:  
**ARCHETYPE architects**  
Portland, Maine 04101  
(207) 772-6022 Fax (207) 772-4056

Architect:  
**FRANCIS INN**  
749 CONGRESS ST  
PORTLAND, ME 04102

Project:  
4/06/17-FINAL REVISIONS

Revisions:

Date:  
04/10/2017

Scale: As Noted  
**FIRST FLOOR POWER PLAN**

**E2.1**