

Prepared For:
747 CONGRESS LLC



Consulting Engineer:
ARCHETYPE architects
 48 Union Wharf Portland, Maine 04101
 (207) 772-6022 Fax (207) 772-4056


Architect:
FRANCIS INN
 749 CONGRESS ST
 PORTLAND, ME 04102

Project:	FRANCIS INN
Revisions:	4/06/17-FINAL REVISIONS

Date:	04/10/2017
Scale:	As Noted

THIRD FLOOR POWER PLAN

E2.3

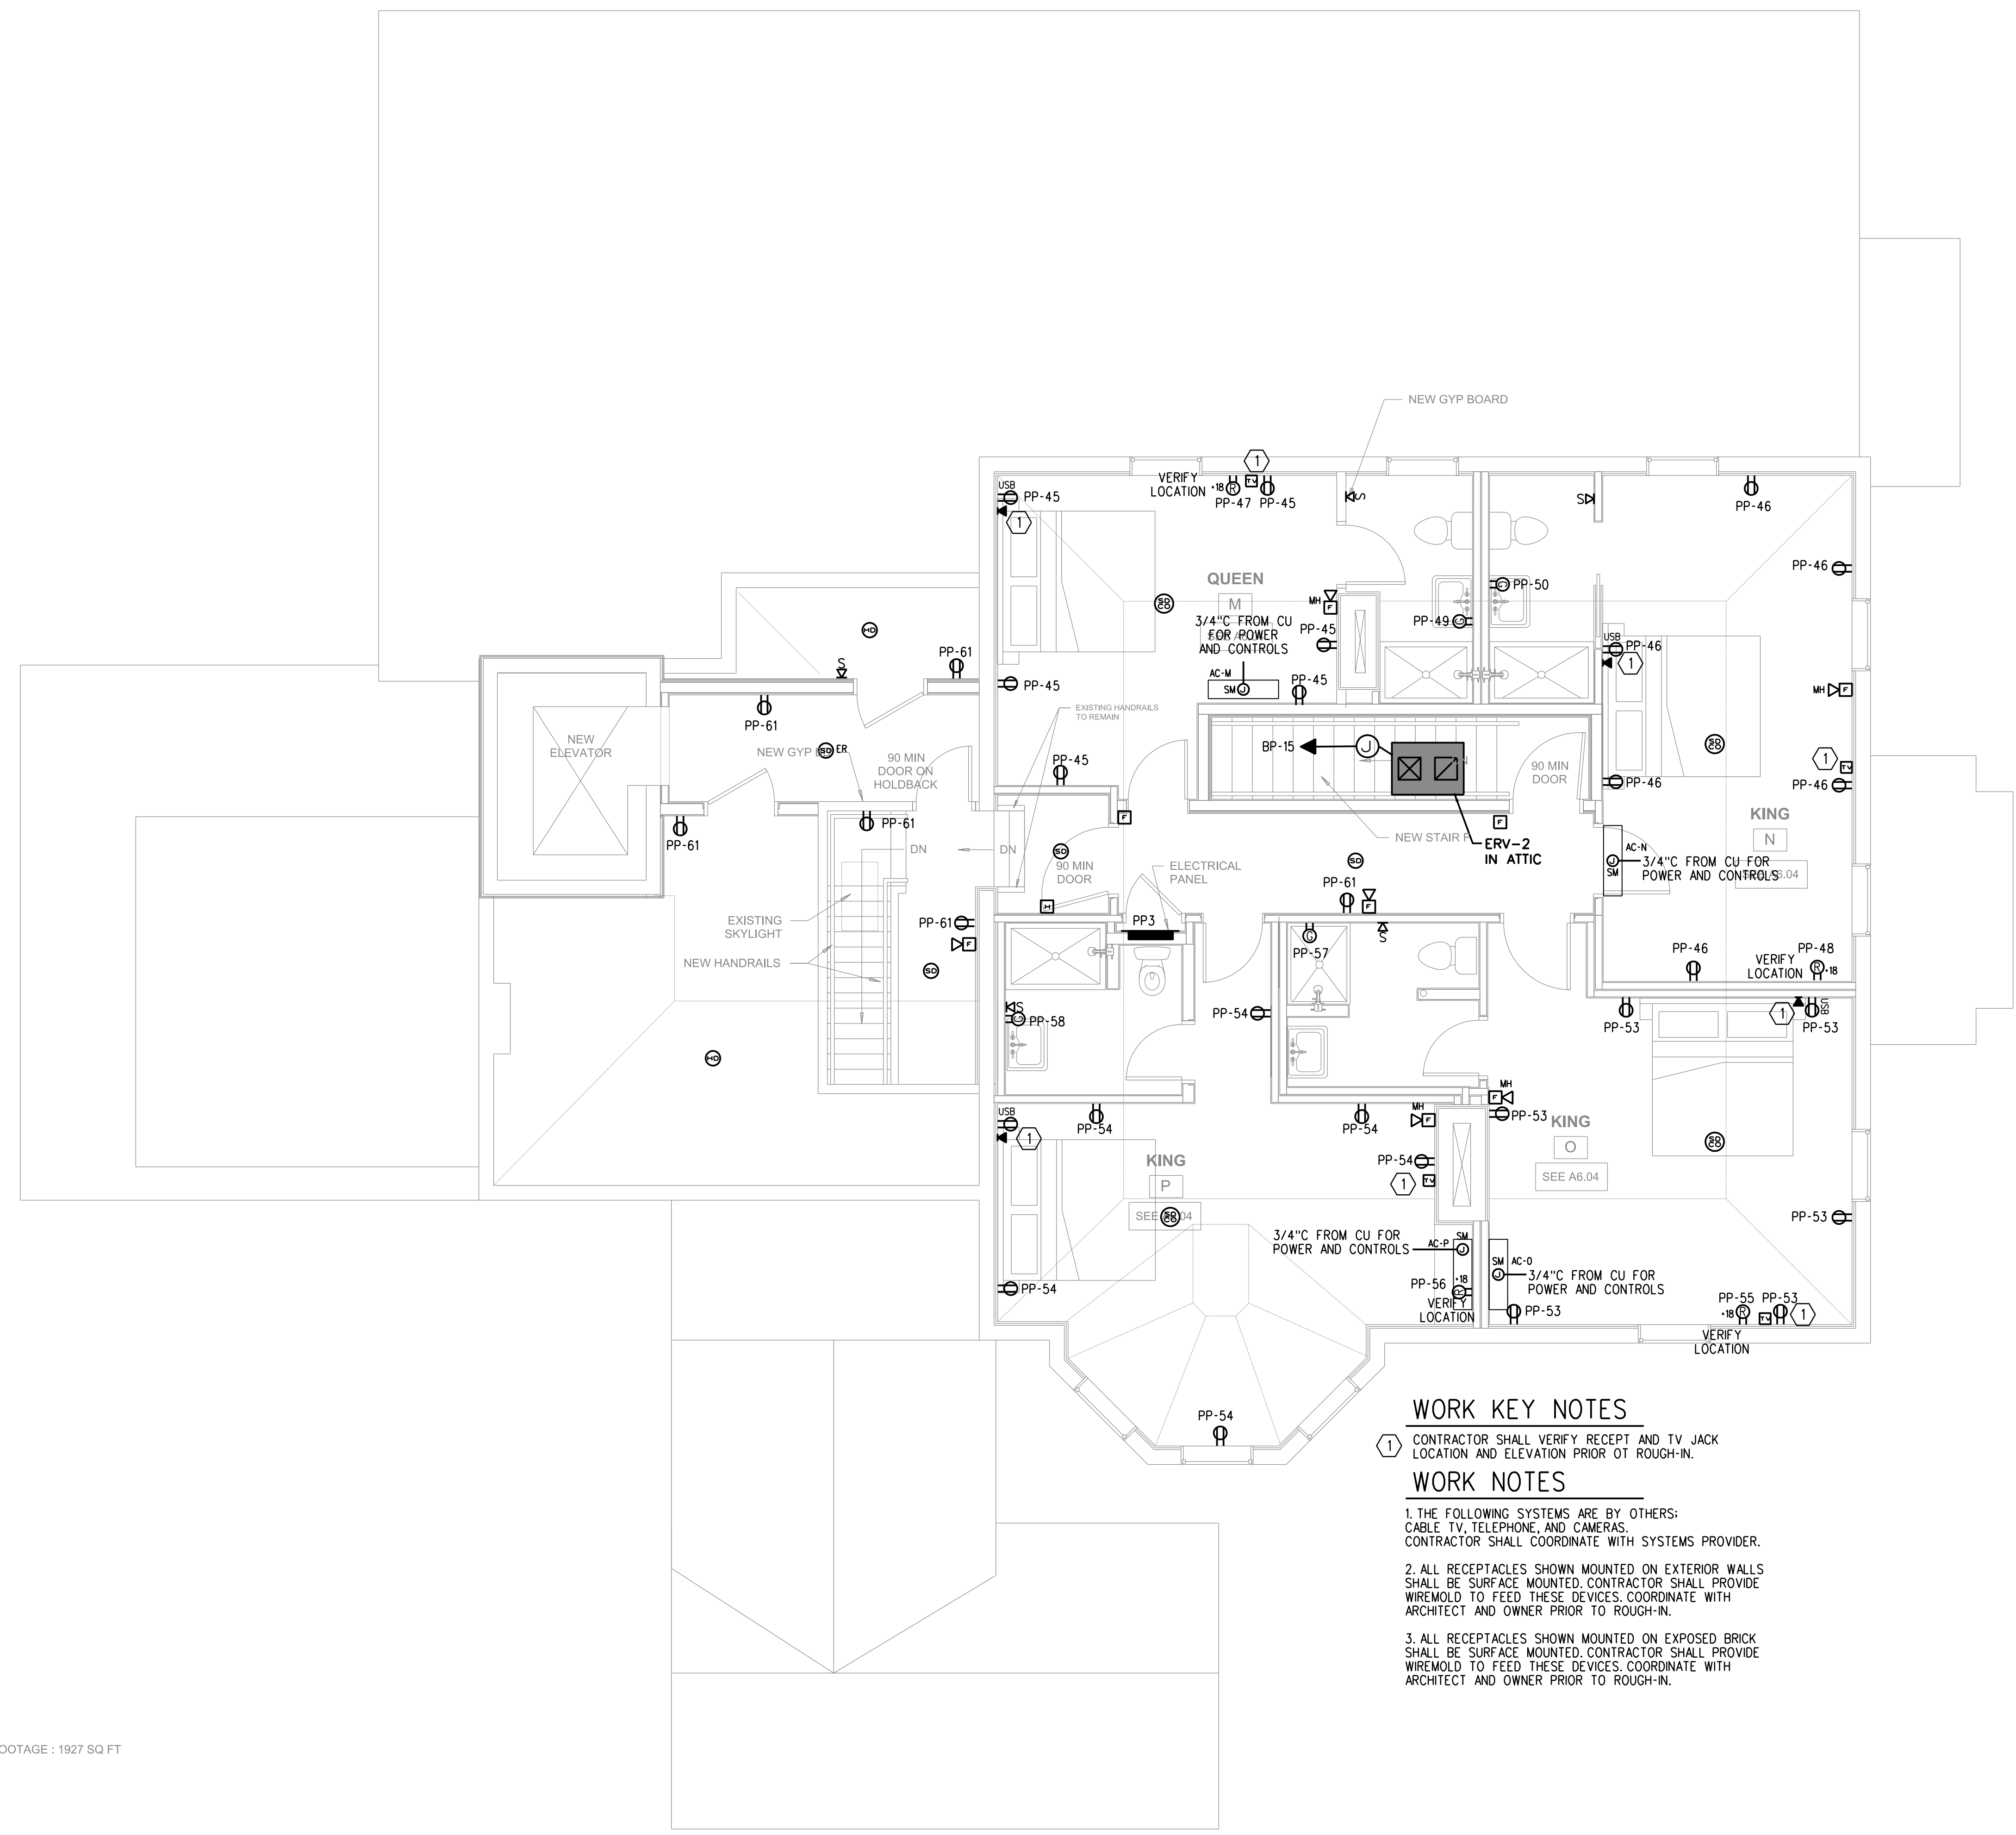

- WORK KEY NOTES**
- ① CONTRACTOR SHALL VERIFY RECEPT AND TV JACK LOCATION AND ELEVATION PRIOR TO ROUGH-IN.
- WORK NOTES**
1. THE FOLLOWING SYSTEMS ARE BY OTHERS: CABLE TV, TELEPHONE, AND CAMERAS. CONTRACTOR SHALL COORDINATE WITH SYSTEMS PROVIDER.
 2. ALL RECEPTACLES SHOWN MOUNTED ON EXTERIOR WALLS SHALL BE SURFACE MOUNTED. CONTRACTOR SHALL PROVIDE WIREMOLD TO FEED THESE DEVICES. COORDINATE WITH ARCHITECT AND OWNER PRIOR TO ROUGH-IN.
 3. ALL RECEPTACLES SHOWN MOUNTED ON EXPOSED BRICK SHALL BE SURFACE MOUNTED. CONTRACTOR SHALL PROVIDE WIREMOLD TO FEED THESE DEVICES. COORDINATE WITH ARCHITECT AND OWNER PRIOR TO ROUGH-IN.

SQ FOOTAGE : 1927 SQ FT

THIRD FLOOR PLAN
 SCALE: 1/4"=1'-0"