


project name

**Butler Payson**  
pine st.  
state st.  
portland, me

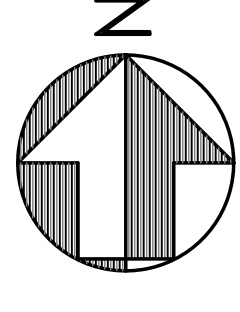

avesta housing


goduti/thomas architects  
44 oak st.  
portland, maine 04101  
ph. 207-775-3184  
fax 207-774-0486

PERMIT SET


revisions  
date January 13, 2015  
sheet title

payson  
first floor  
plumbing plan

scale 1/4" = 1'-0"  
drawn by ejp  
project number  
butpay

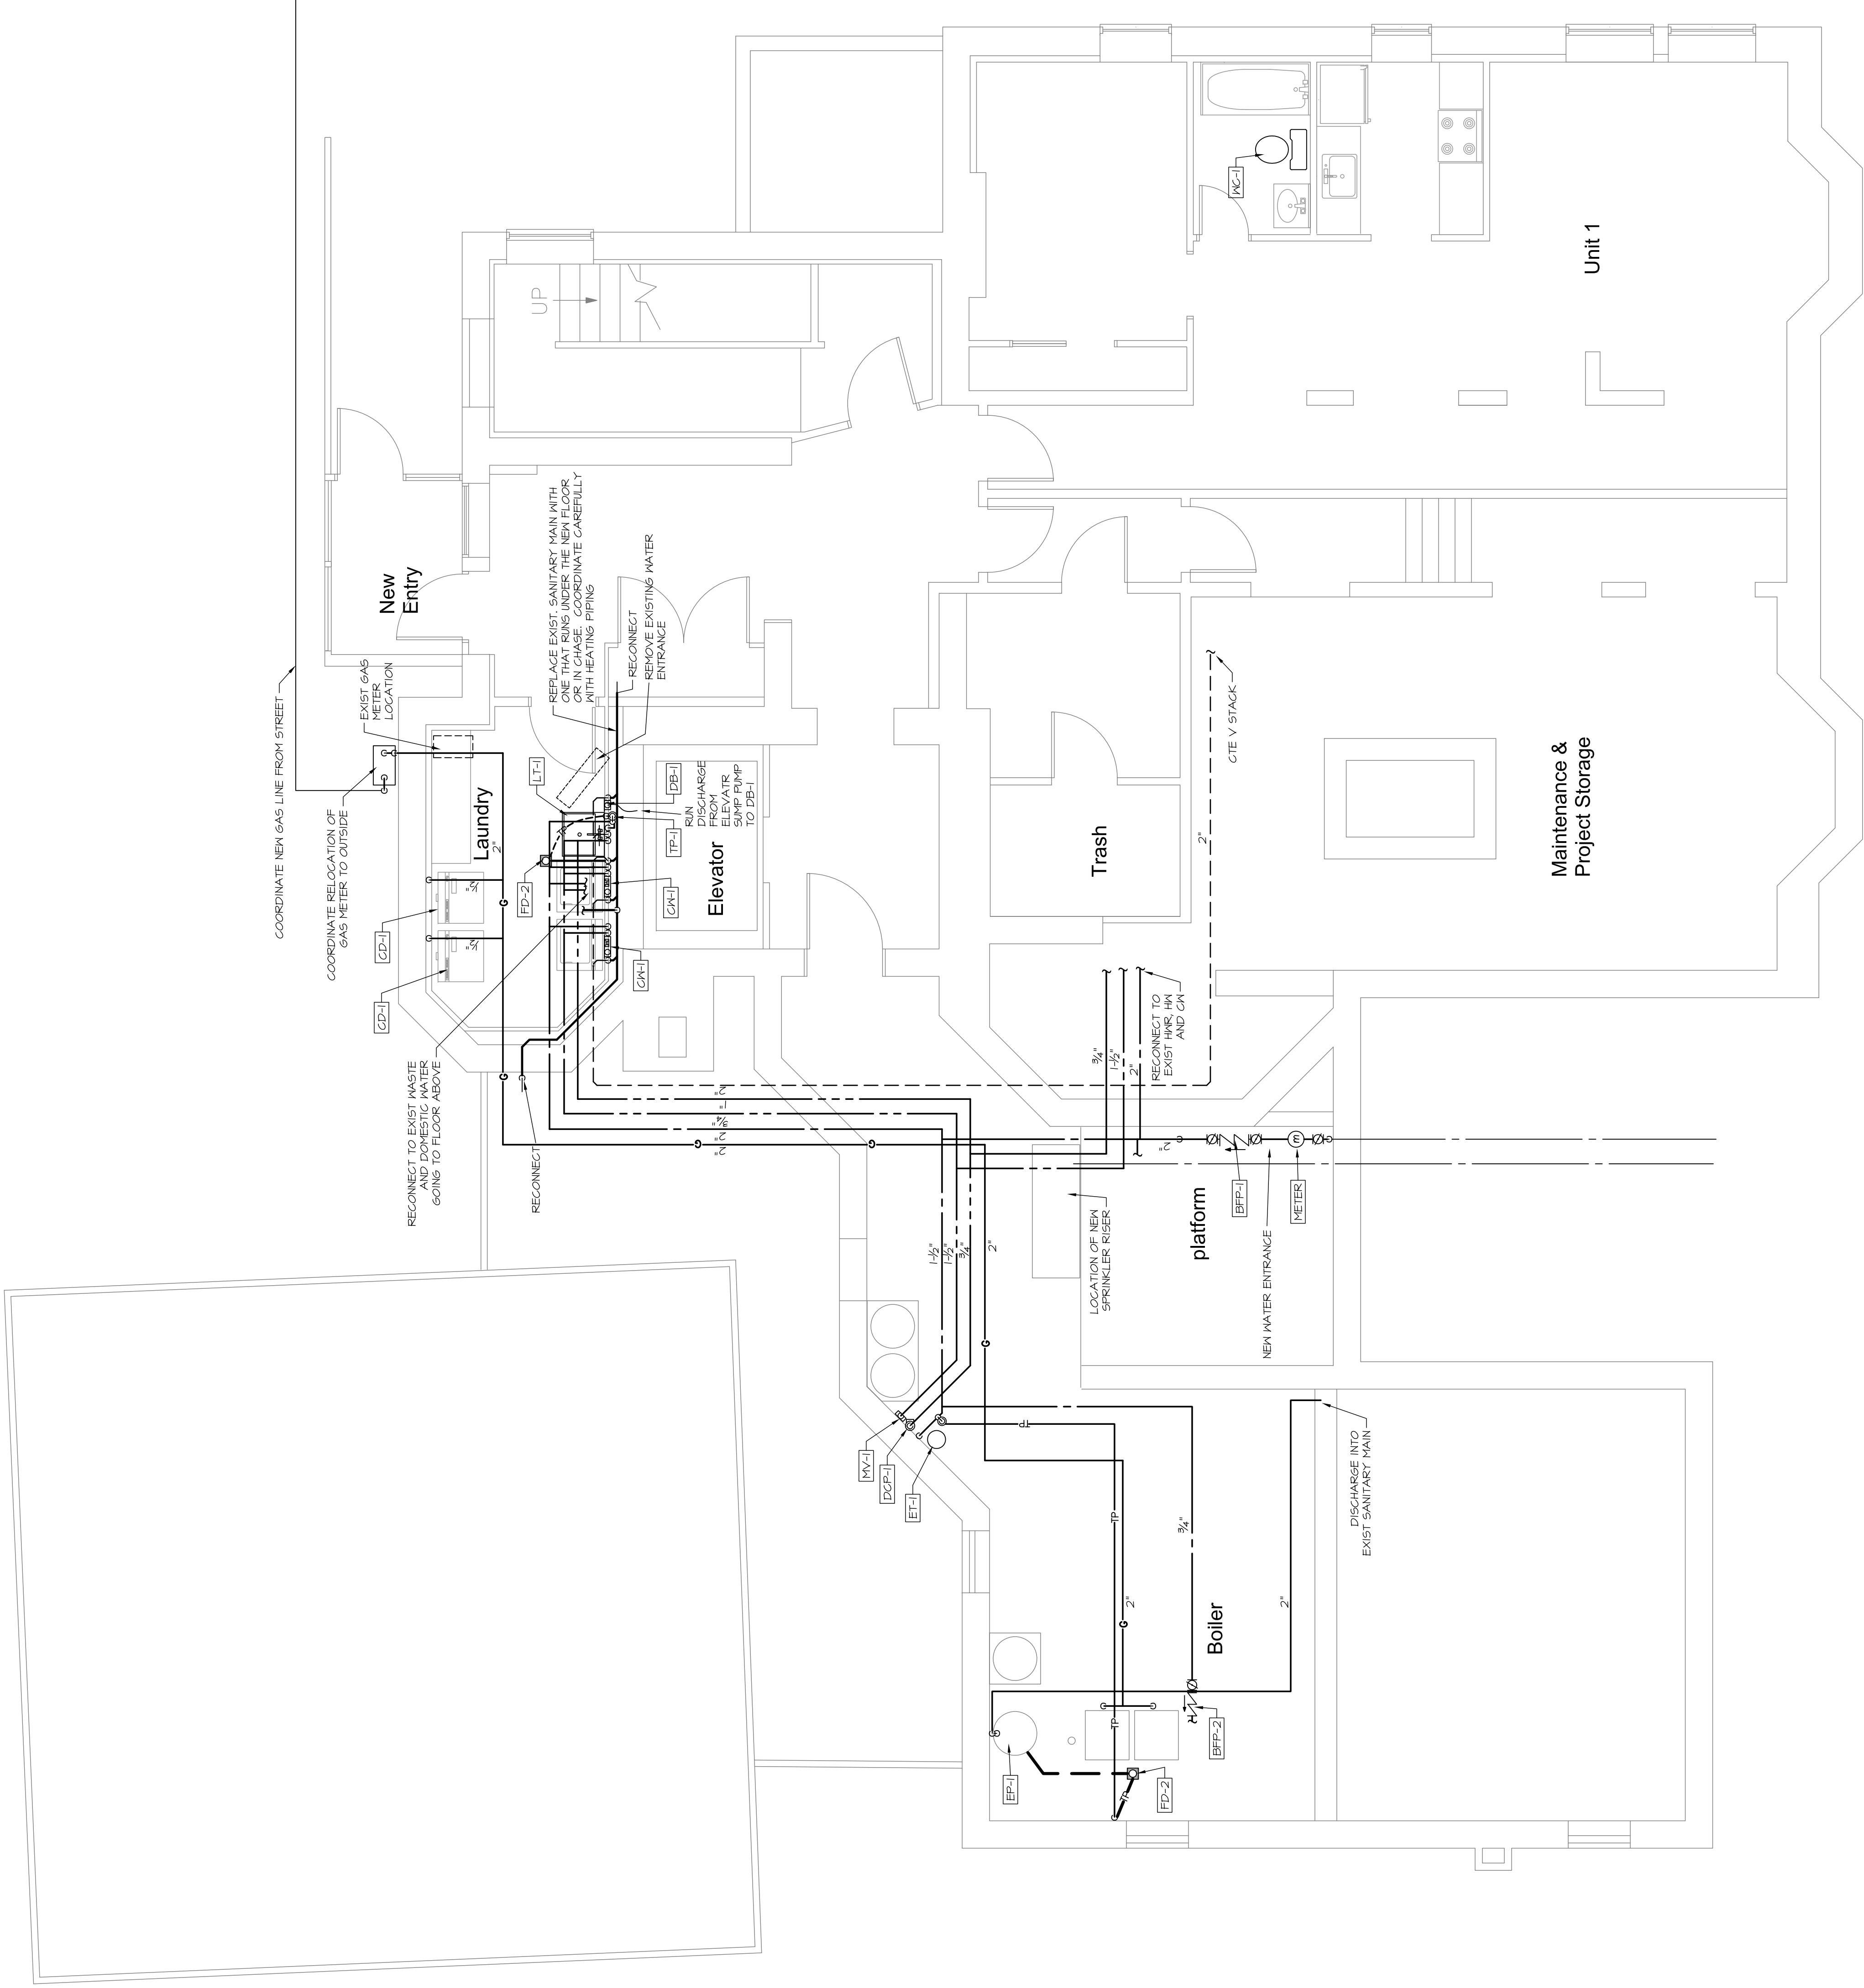

**MECHANICAL SYSTEMS ENGINEERS**  
10 FOREST FALLS DRIVE WARREN, MAINE 04086  
(207) 845-1441  
FACEBOOK: MECHANICAL SYSTEMS ENGINEERS  
© COPYRIGHT 2015

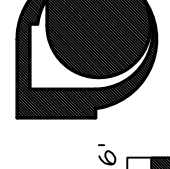

1/4" = 1'-0"  
0' 1' 2' 3' 4' 5' 6' 12'