
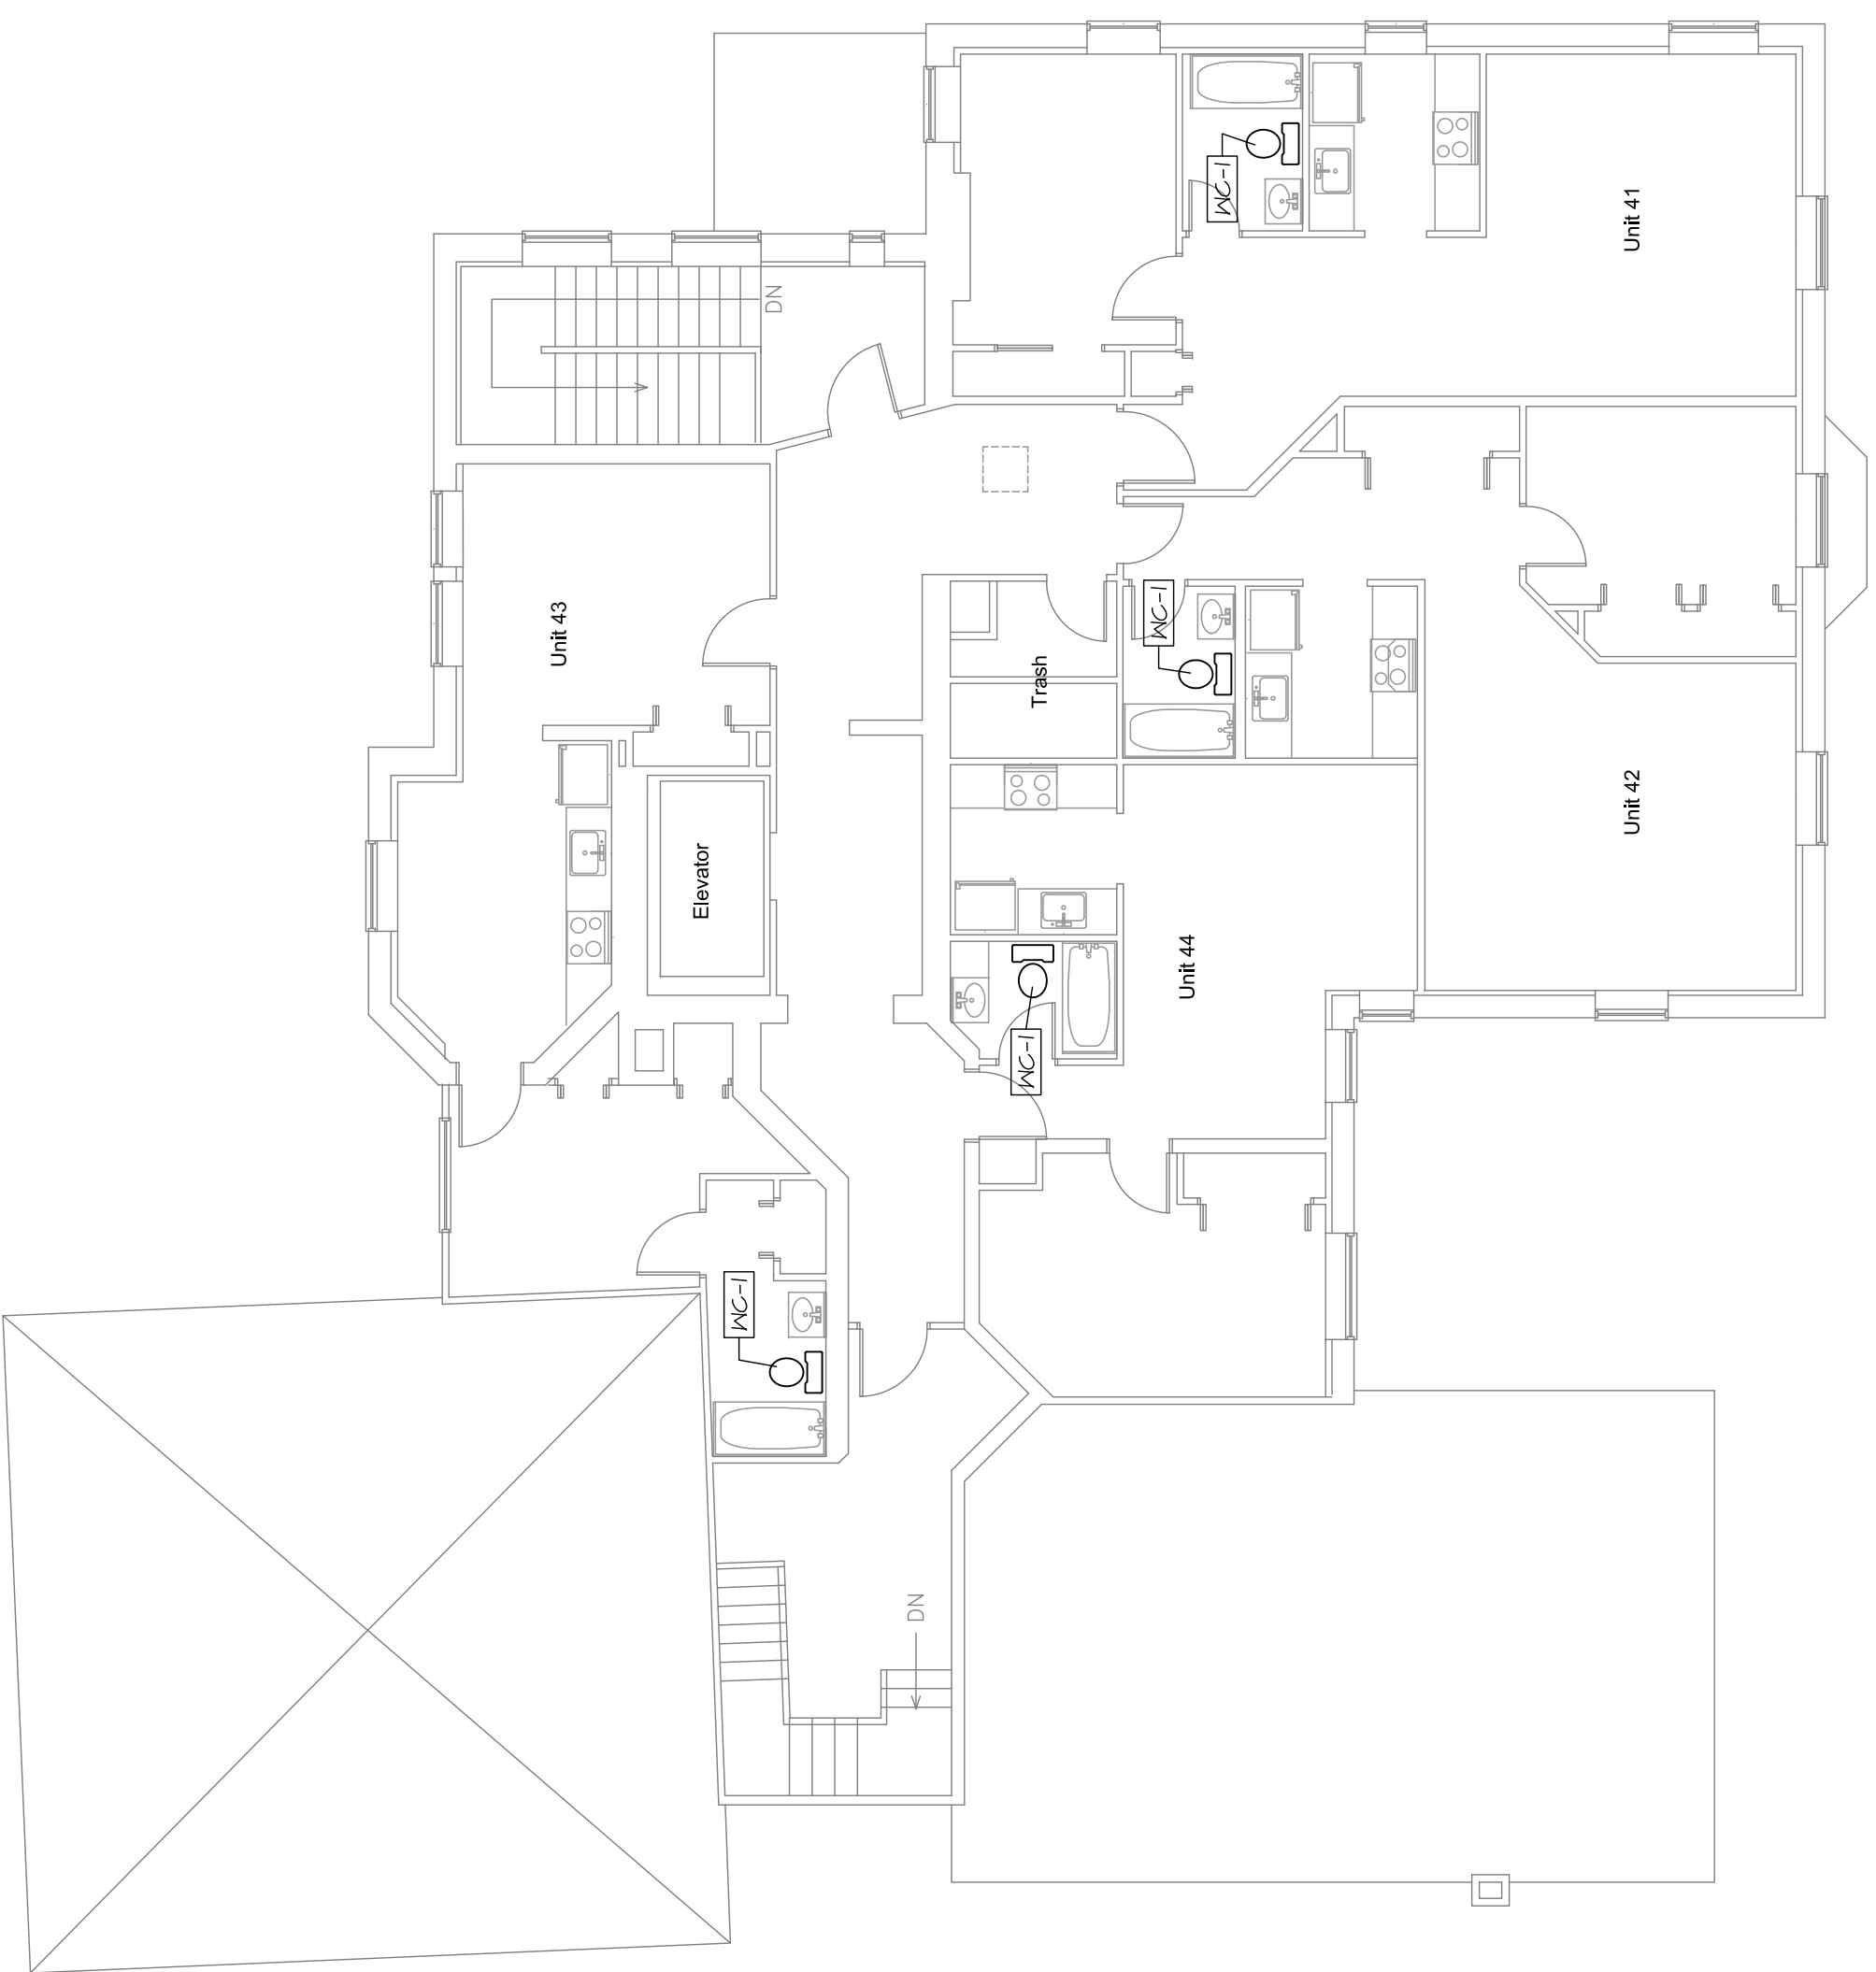
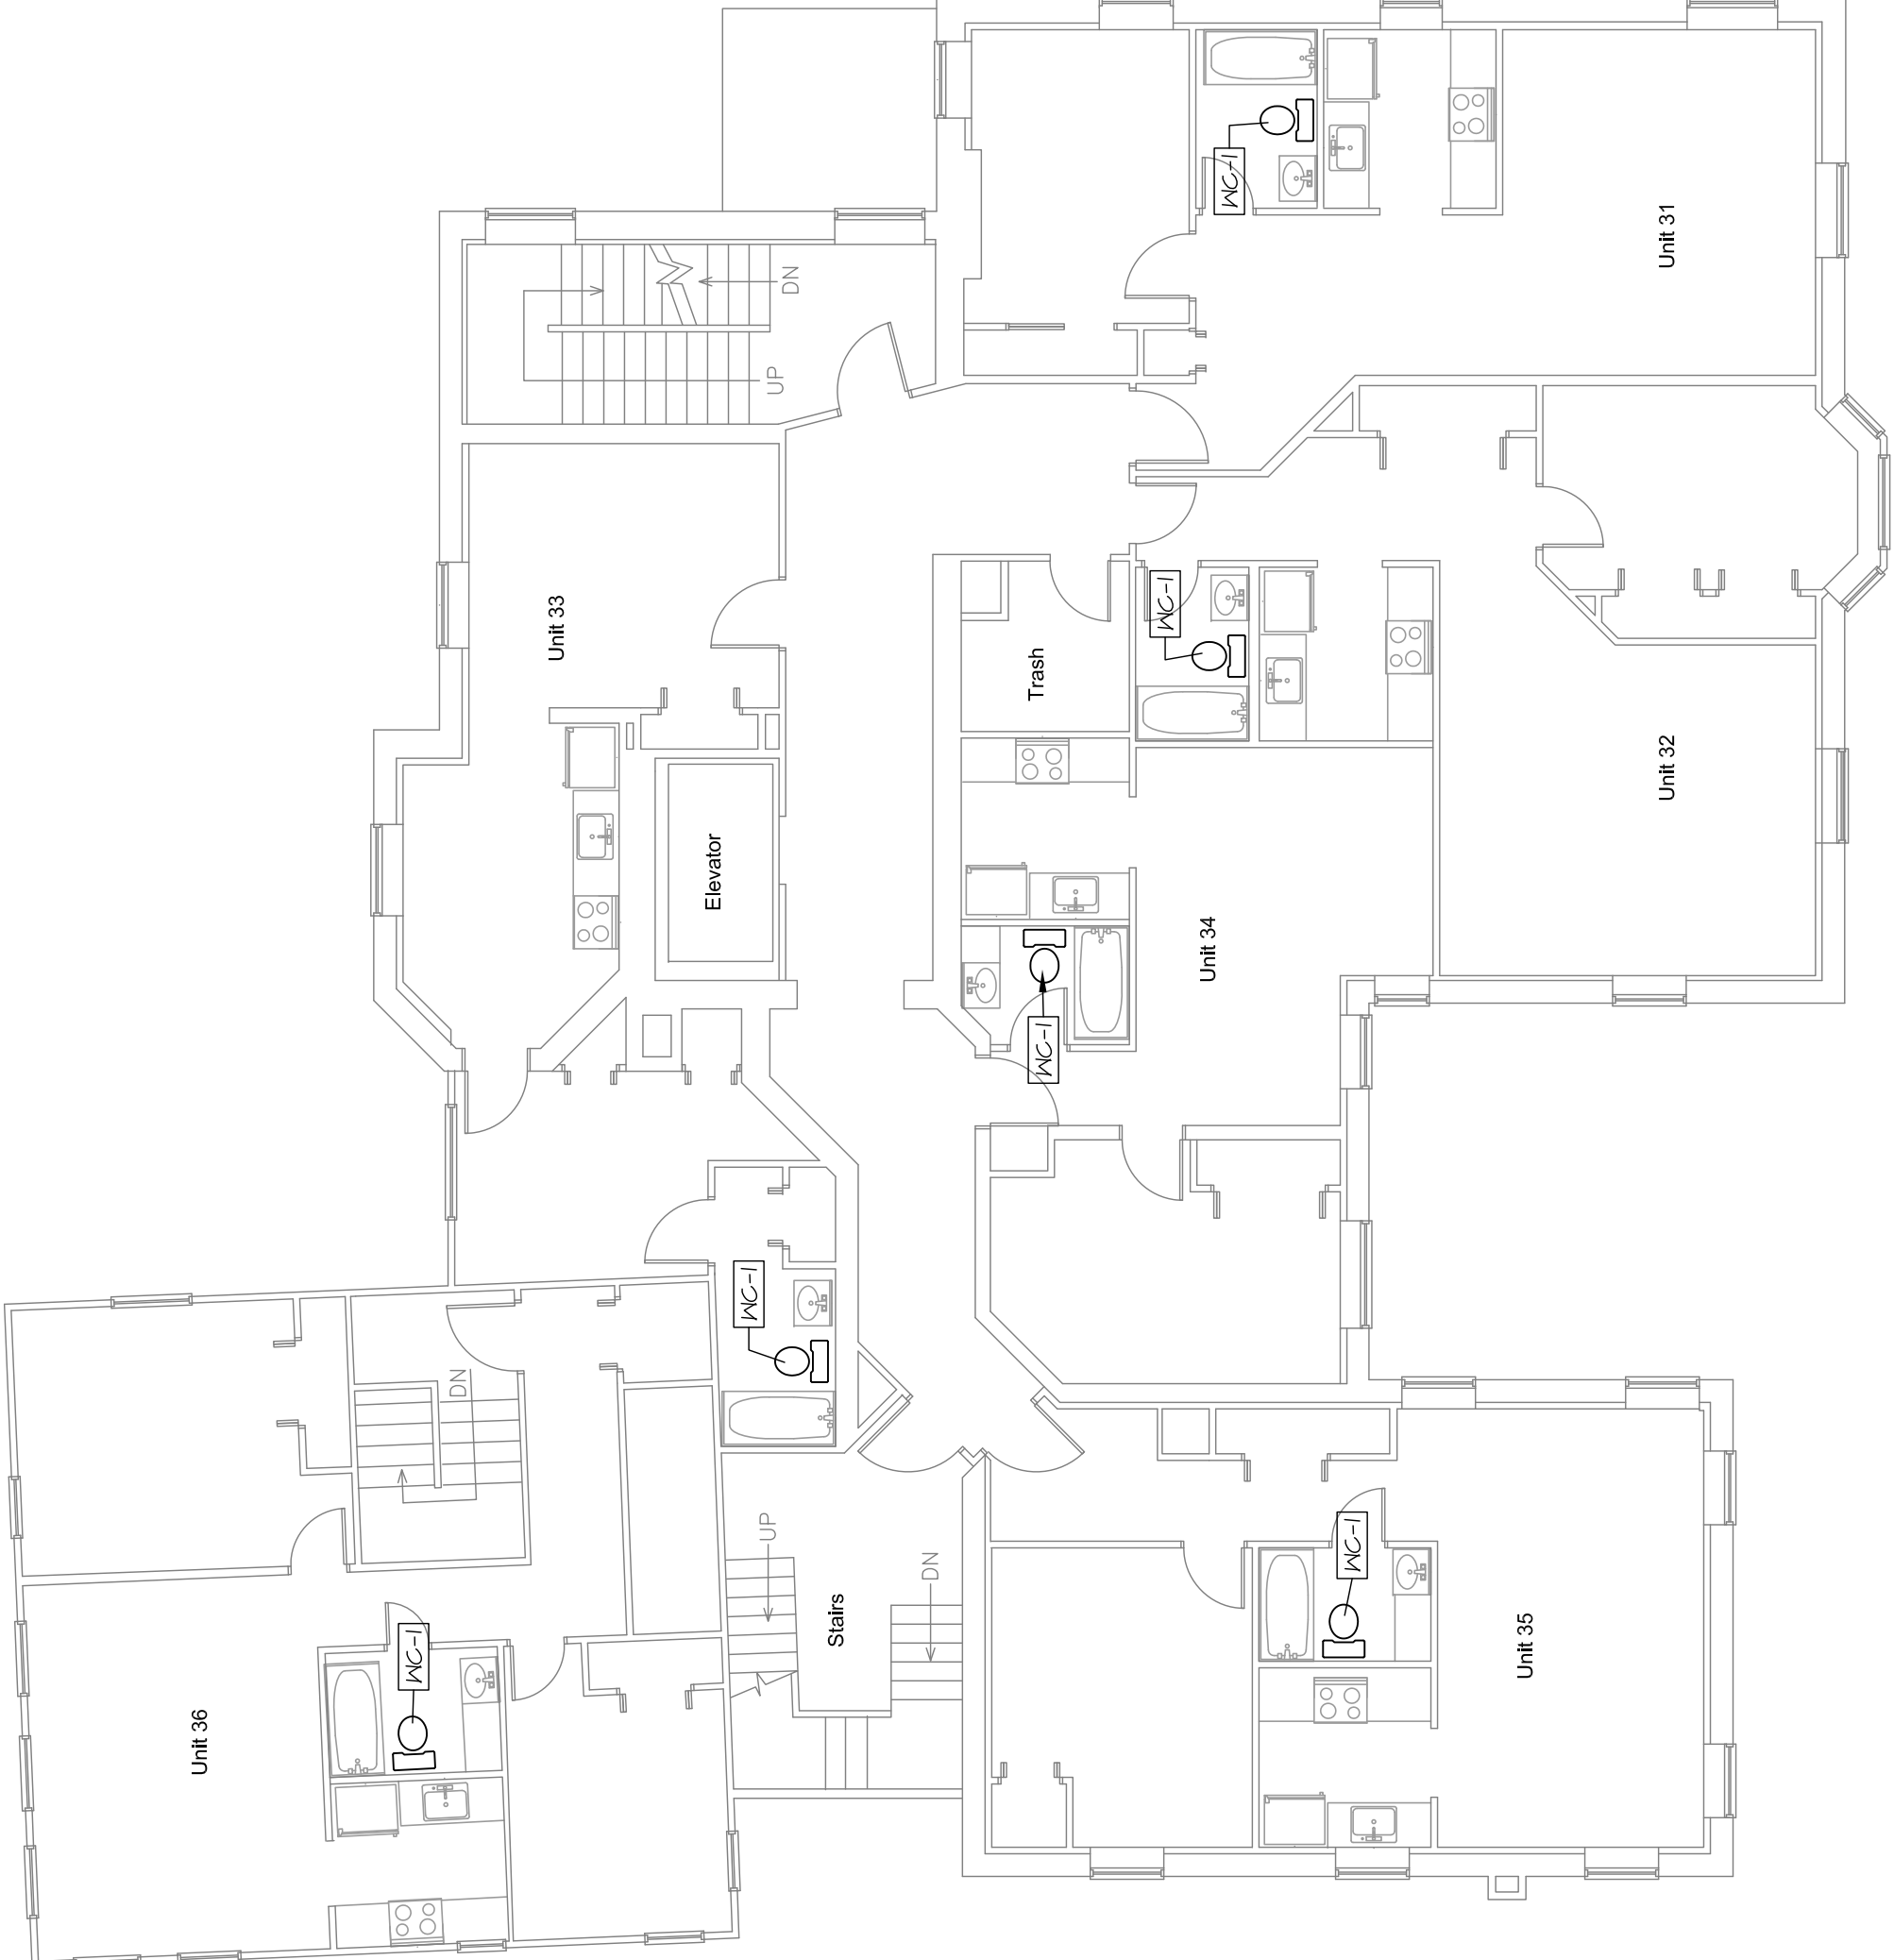


project name

Butler Payson
pine st.
state st.
portland, me

avesta housing

goduti/thomas architects
44 oak st.
portland, maine 04101
ph. 207-775-3184
fax 207-774-0486

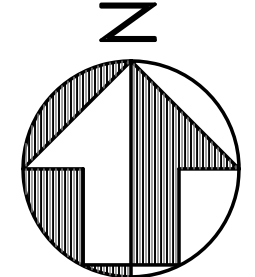

PERMIT SET

 

revisions
date January 13, 2015
sheet title

payson
second, third and
fourth floor
plumbing plans

scale 1/8"=1'-0"
drawn by ejp
project number butpay



MECHANICAL SYSTEMS ENGINEERS
10 FOREST FALLS DRIVE, YARMOUTH, MAINE 04096
(207) 846-1441
FACEBOOK: MECHANICAL SYSTEMS ENGINEERS
© COPYRIGHT 2015

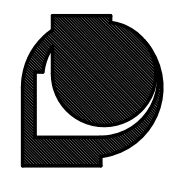

PP2