





Winton Scott Architects
5 Milk Street
Portland, Maine 04101
207 774 4811
www.wintonsscott.com

Architecture / Planning
Preservation Architecture
Interior Architecture

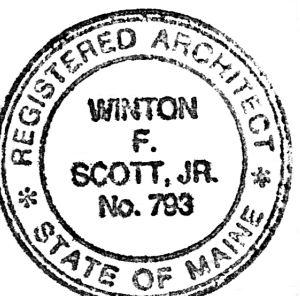


Winton Scott

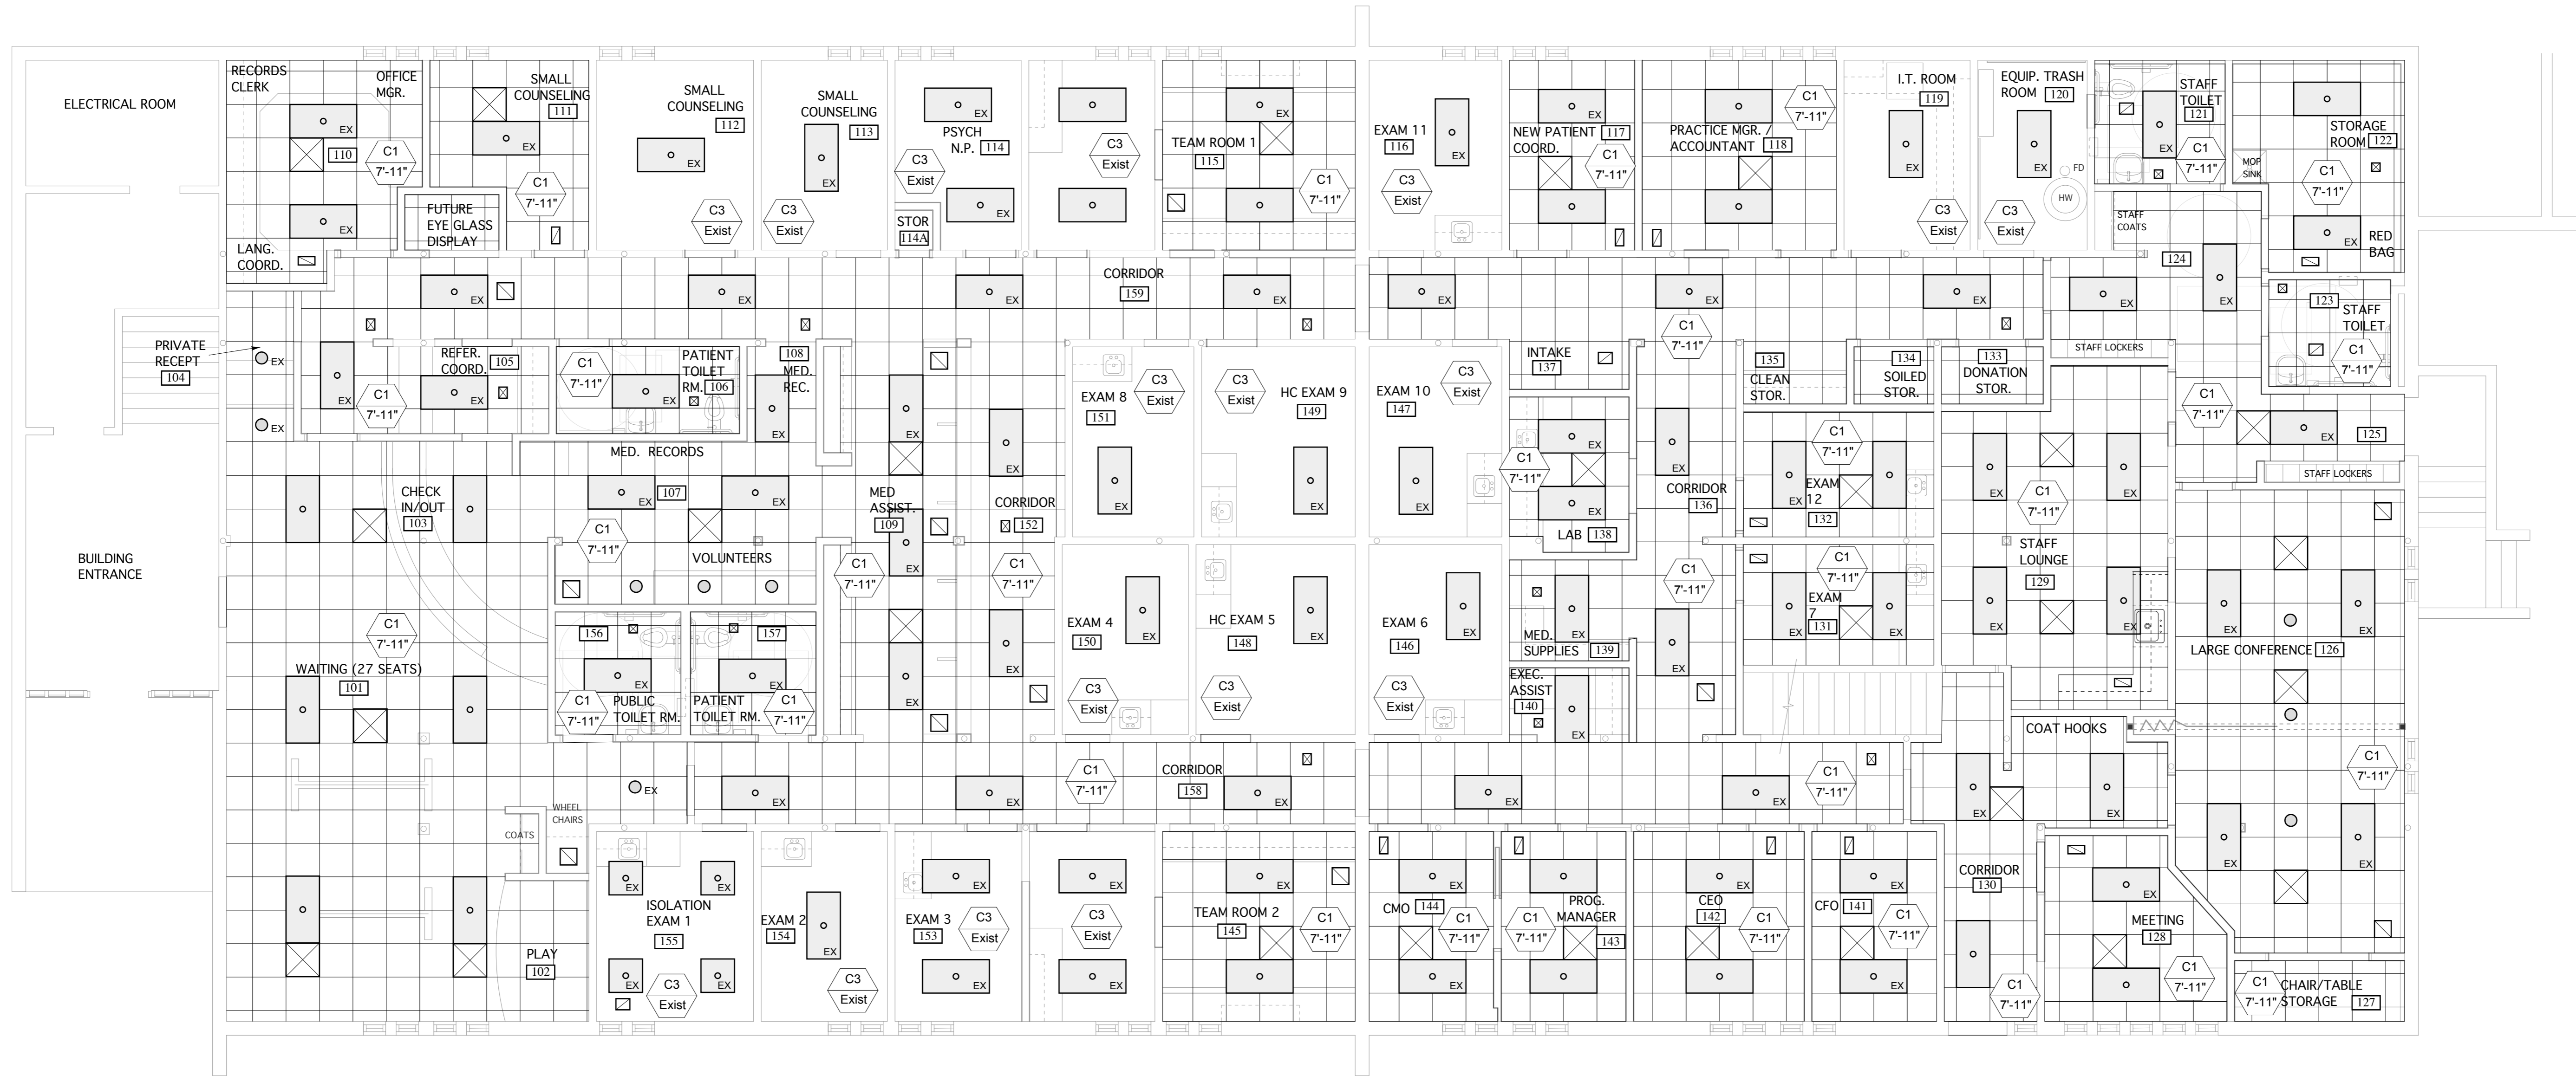


CEILING PLAN

3/16" = 1'-0"

CEILING LEGEND	MECHANICAL LEGEND
<p>C1 8'-0"</p> <p>Indicates ceiling type Indicates ceiling height from finish floor to underside of ceiling finish</p> <p>Suspended acoustical ceiling tiles.</p> <p>Painted GWB soffit.</p> <p>Existing Suspended acoustical ceiling tiles to remain</p>	<p>EQUIPMENT IS SHOWN FOR COORDINATION PURPOSES ONLY. LAYOUT IS NOT EXTENSIVE. REFER TO MECHANICAL DRAWINGS AND SPECIFICATIONS FOR MORE DETAILS.</p> <p>AIR SUPPLY GRILLE OR EXHAUST REGISTER. SEE MECH.</p> <p>AIR RETURN GRILLE OR EXHAUST REGISTER. SEE MECH.</p>
CEILING TYPES	LIGHT FIXTURES LEGEND
<p>C1 2'x2' suspended acoustical ceiling tiles.</p> <p>C2 Framed GWB soffit - painted</p> <p>C3 EXISTING 2'x2' suspended acoustical ceiling tiles to remain.</p>	<p>FIXTURES ARE SHOWN FOR LOCATION PURPOSES ONLY. REFER TO ELECTRICAL DRAWINGS AND SPECIFICATIONS FOR MORE DETAILS.</p> <p>EXISTING RECESSED FLUORESCENT FIXTURE.</p> <p>RECESSED FLUORESCENT FIXTURE.</p> <p>EXISTING RECESSED FLUORESCENT FIXTURE.</p> <p>RECESSED DOWNLIGHT FIXTURE.</p> <p>EXISTING RECESSED DOWNLIGHT FIXTURE.</p>

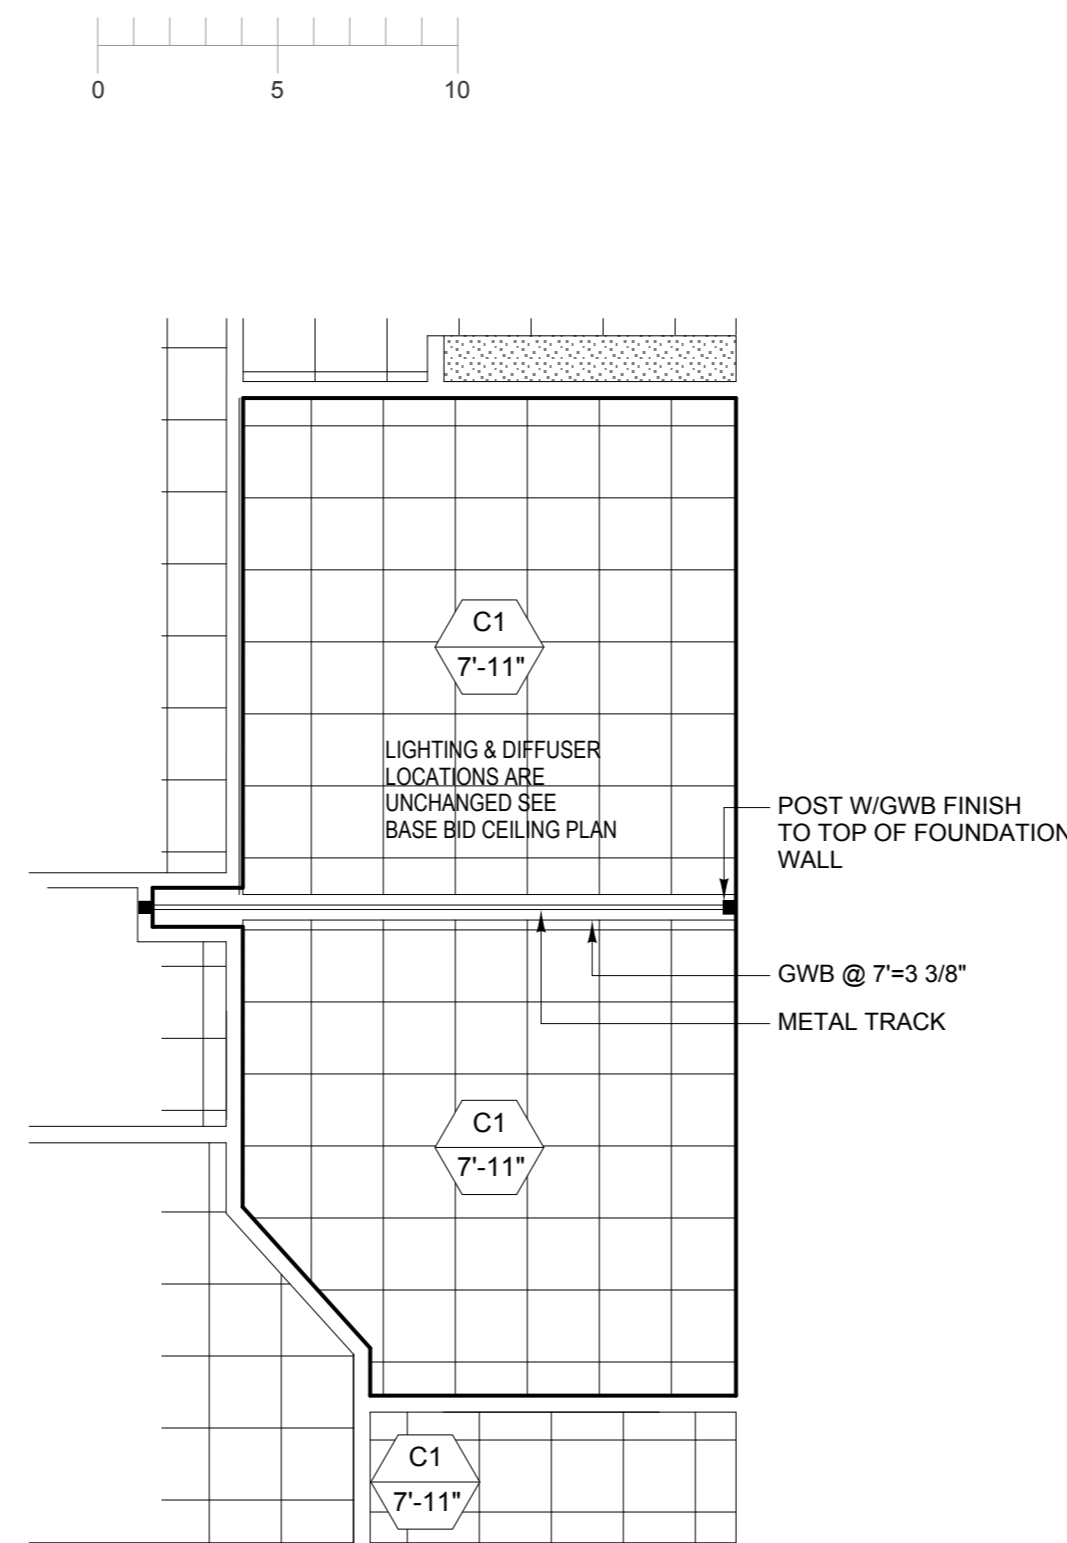

PART CEILING PLAN BY ALTERNATE #1
3/16" = 1'-0"

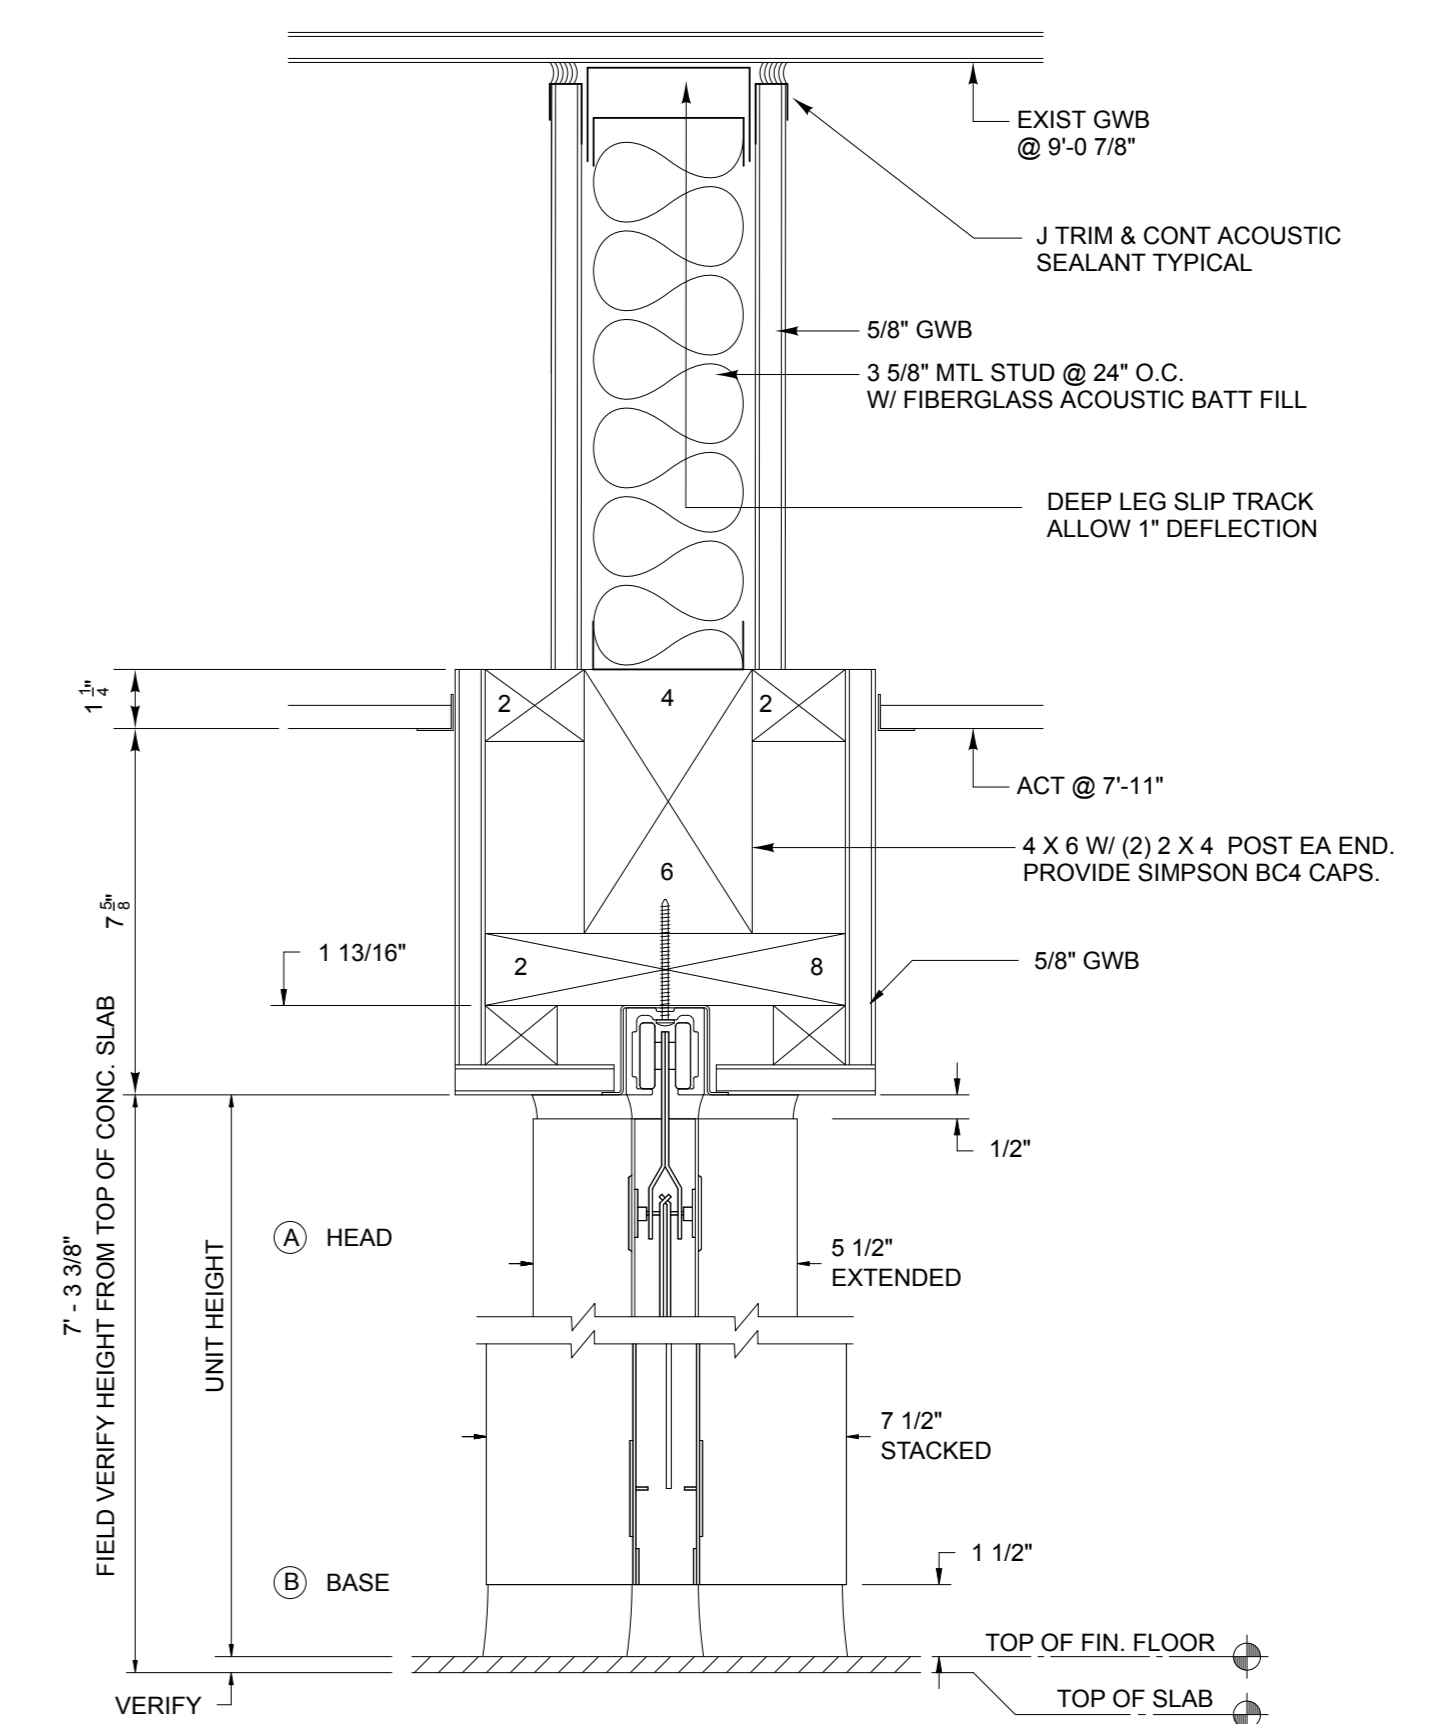

ACCORDION PARTITION SECTION - ALTERNATE #1
3" = 1'-0"

Portland
Community
Health Center

180 Park Avenue
Portland, Maine

CONSTRUCTION DOCUMENTS
August 31, 2012

Ceiling Plan

Scale: As Noted