


KEY NOTES:

P07...
FIRE ALARM SYSTEM SHALL RELEASE DOOR LOCK
IN THE EVENT OF AN ALARM CONDITION.

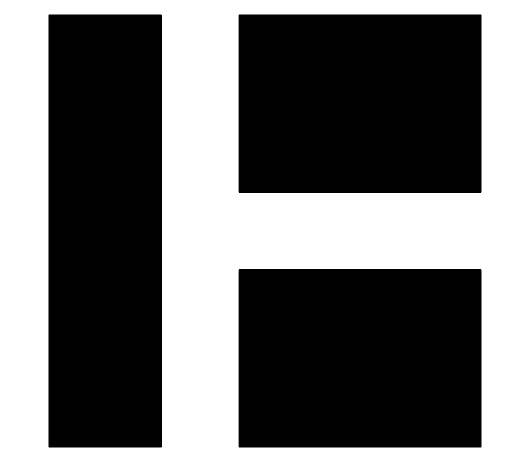

HARRIMAN



 
AUBURN PORTLAND MANCHESTER

**COMMUNITY DENTAL
PORTLAND**

180 Park Avenue
Portland, ME

Harriman Project No. 16336

Key Plan Proj North

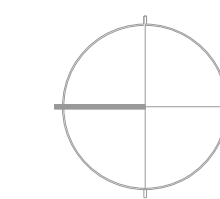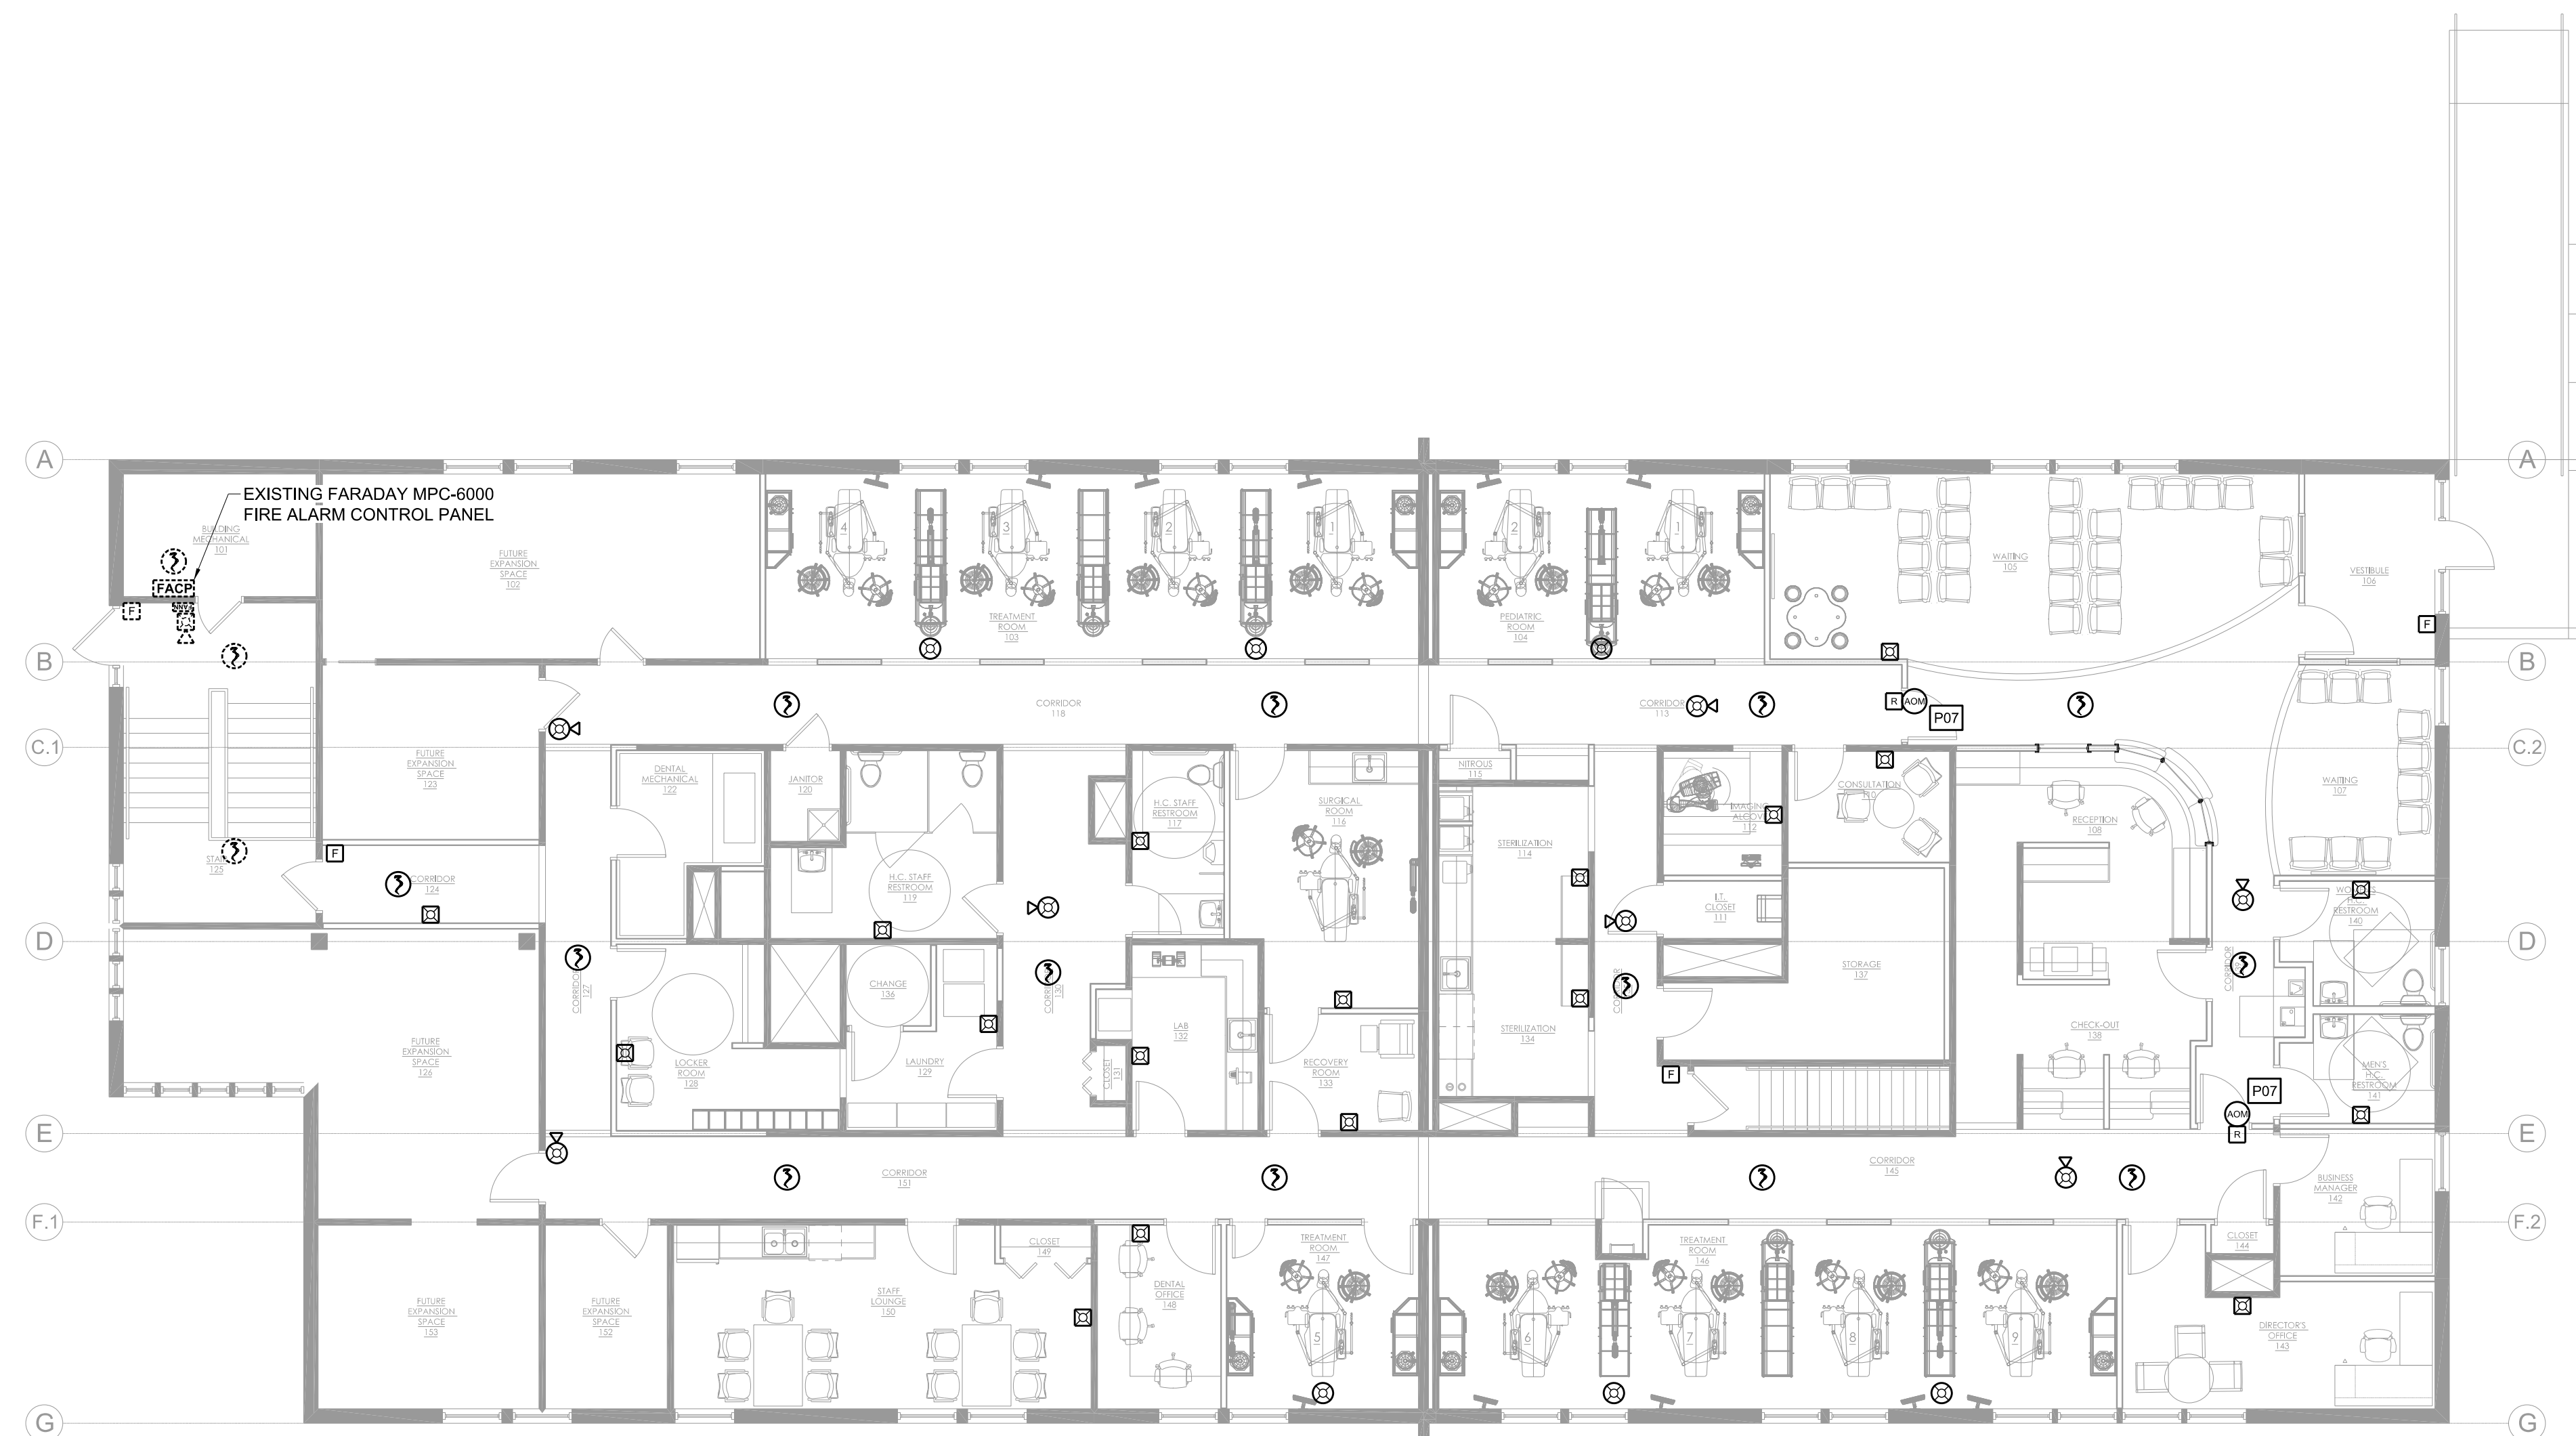

PROJECT NORTH



Issues and Revisions

Mark	Date	Description
--	07-03-16	PROGRESS

**PRELIMINARY
NOT FOR
CONSTRUCTION**

Drawing Scales

PA / PE: JWT © 2016
Drawn By: JWT Harriman Associates

**SYSTEMS
PLAN**

E30.1