


SYSTEM INPUTS

SYSTEM OUTPUTS

		A	B	C	D	E	F	G	H	I	J	K
1	MANUAL FIRE ALARM PULL STATION	●			●	●	●	●	●	●		
2	SMOKE DETECTOR	●			●	●	●	●	●	●		
3	HEAT DETECTOR	●			●	●	●	●	●	●		
4	FIRE ALARM AC POWER FAILURE		●		●	●	●				●	
5	FIRE ALARM SYSTEM LOW BATTERY		●		●	●	●				●	
6	OPEN CIRCUIT			●	●	●	●					●
7	GROUND FAULT			●	●	●	●					●
8	NOTIFICATION APPLIANCE CIRCUIT SHORT			●	●	●	●					●

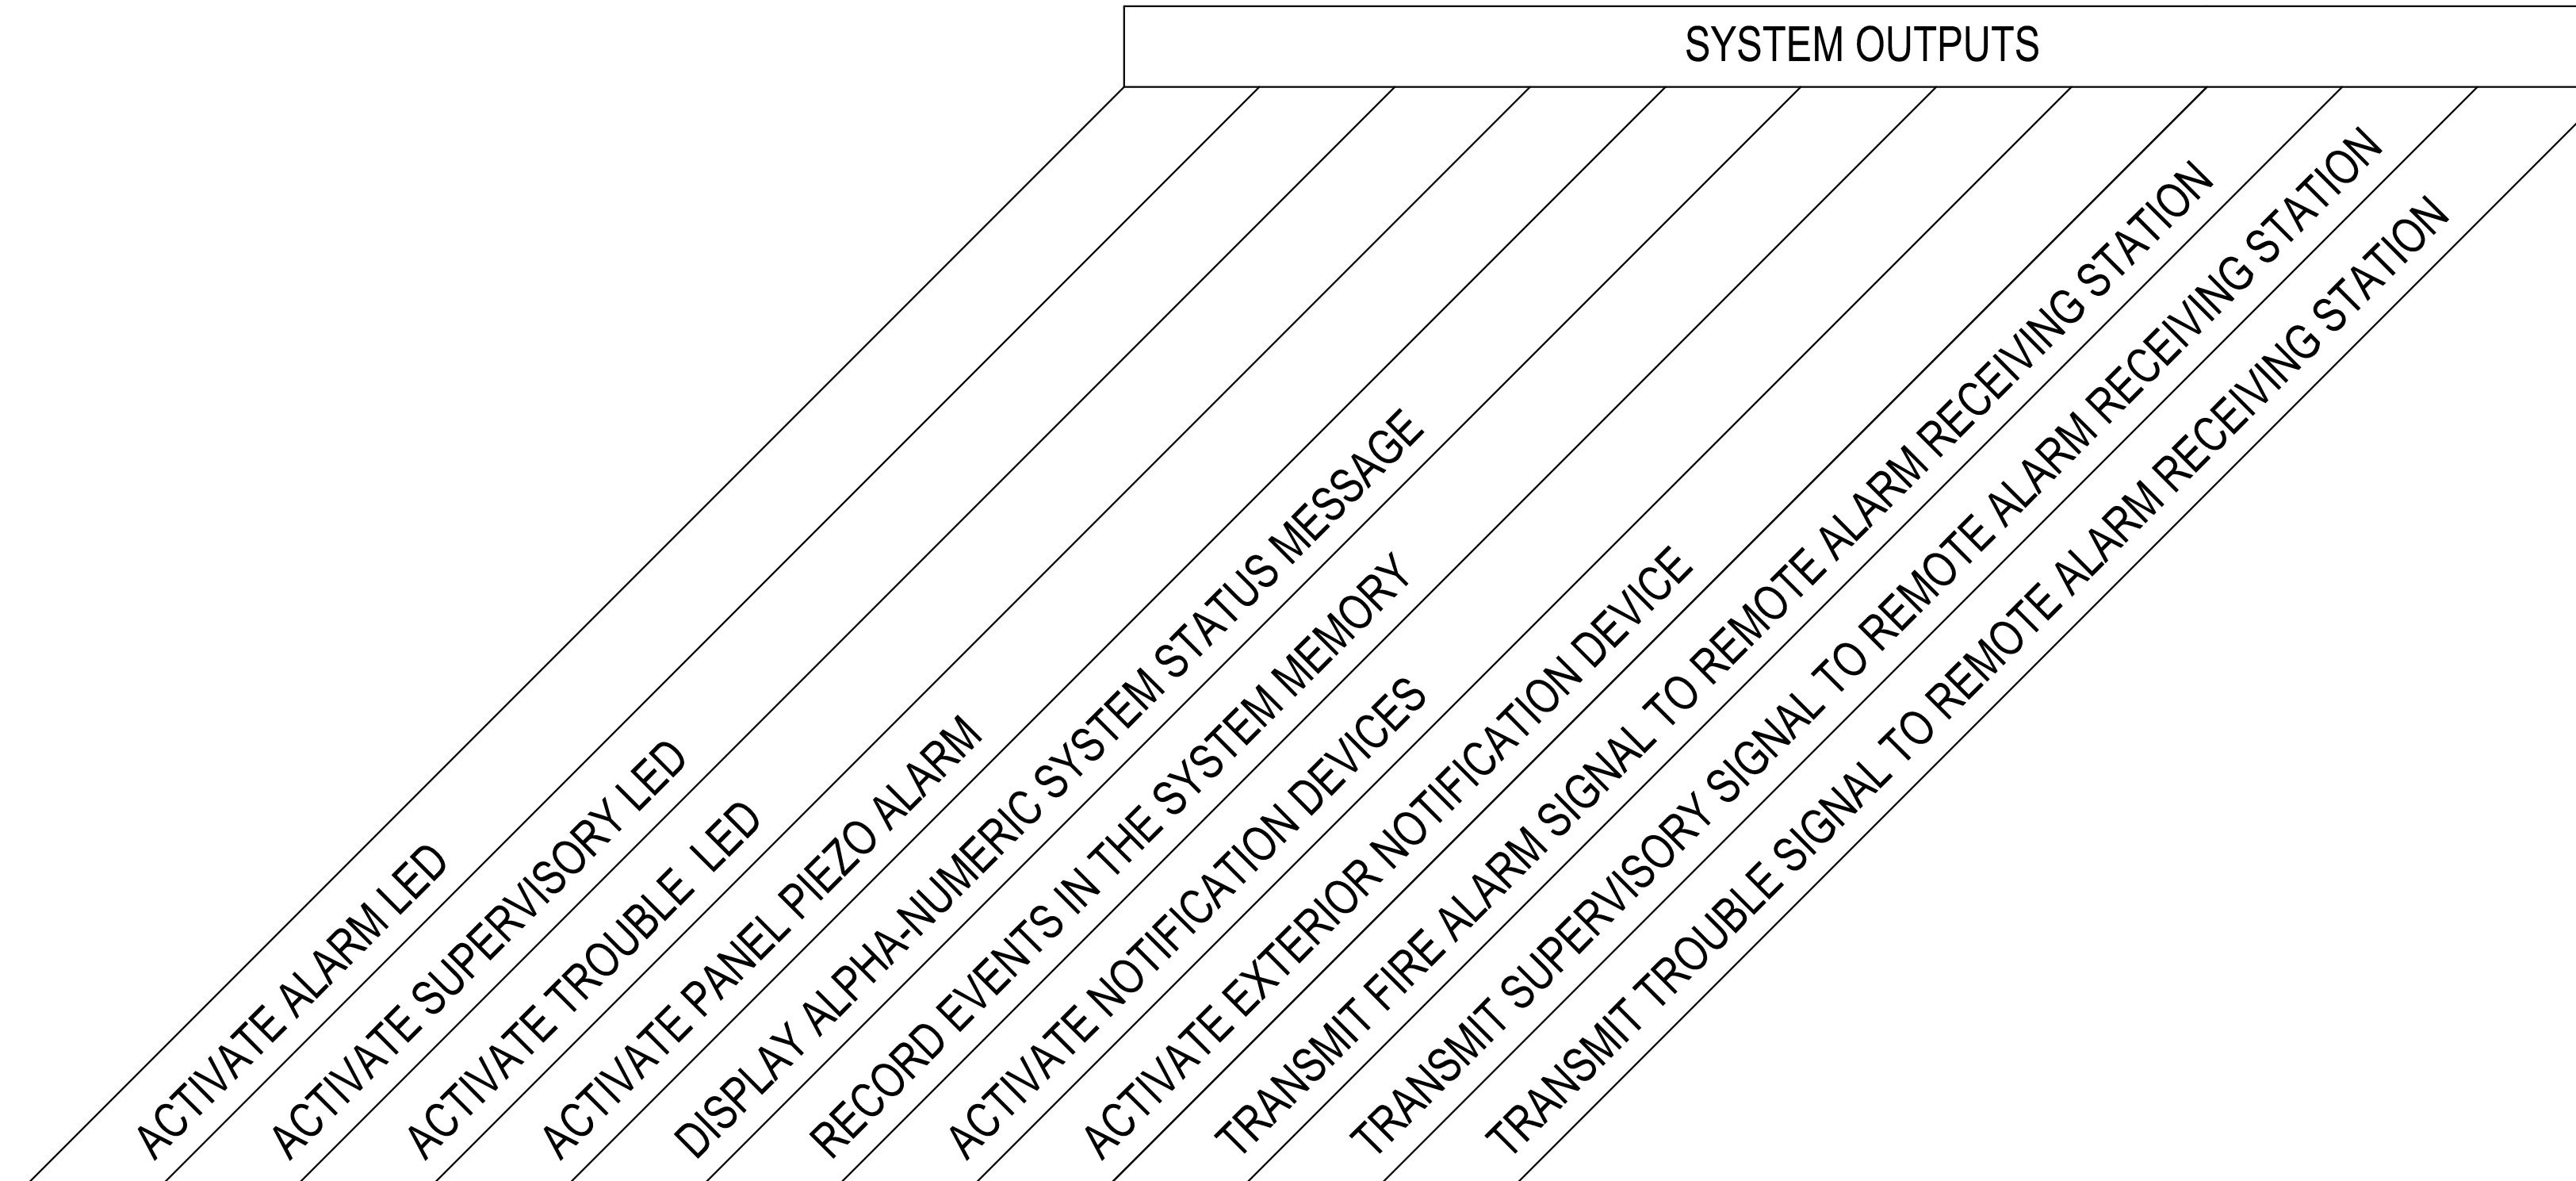

REVISION 2	DATE:
REVISION 1	DATE:
REVISION 0 SUBMITTAL	DATE: 12/26/2013

CAUSE AND EFFECT MATRIX

PROJECT NAME	SCALE NTS
129 GRANT STREET APTS 129 GRANT ST PORTLAND, ME	BY: JRS
	CK BY:



Prepared For Tomorrow, Delivered Today  
2257 BROADWAY, SO. PORTLAND, MAINE

SAVED AS: