


CAD FILE: 01404 UNDERDRAINS SCALE: 1=10

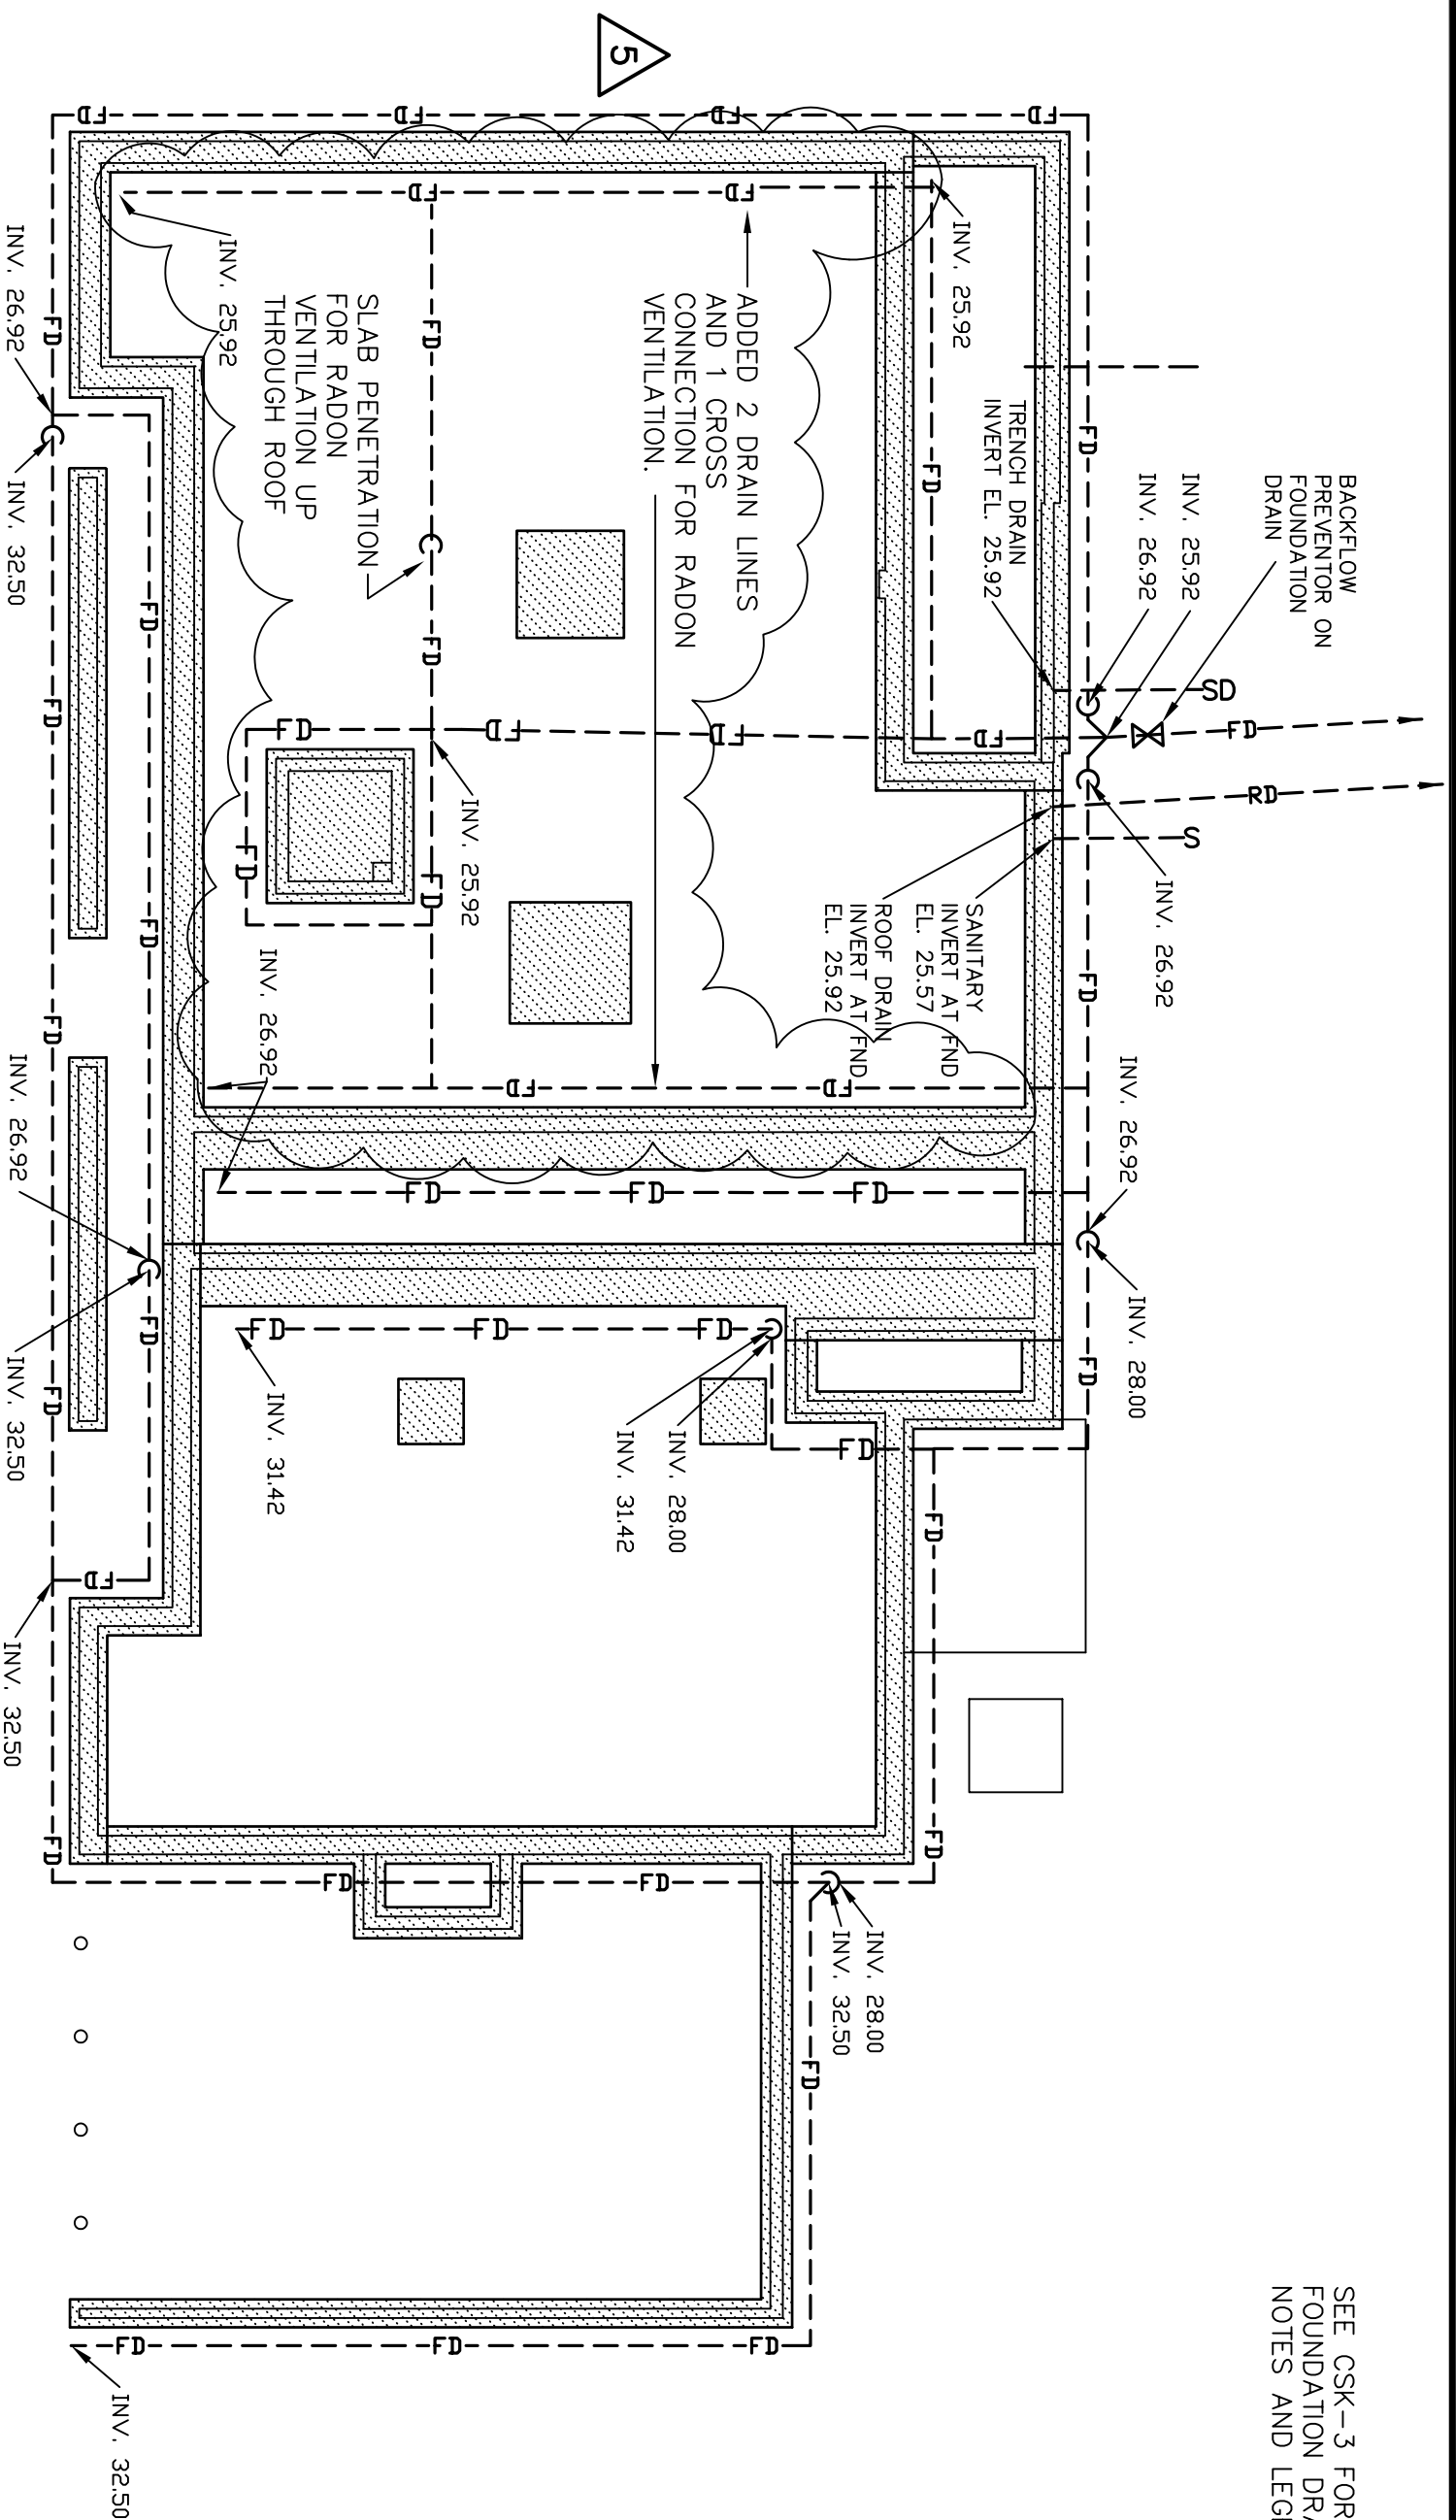

SEE CSK-3 FOR FOUNDATION DRAIN NOTES AND LEGEND

# FOUNDATION DRAIN PLAN - BUILDING A

SCALE:  
1"=10'

REV. 2	3/12/04	ADDED PIPING REQUIRED FOR RADON VENTILATION (BY TFH)
ADD. 5		
REV. 1	2/12/04	INVERTS REVISED PER COORDINATION W/ FOUNDATION PLAN ADDENDUM

# FOUNDATION DRAINS, BLDG A

GRANT STREET  
P.R.O.P. PORTLAND MAINE



SCALE: 1"=10'  
DATE: FEB. 10, 2004  
DESIG BY: TSG  
PROJECT: 01404

CSK-2

PINKHAM & GREER  
CONSULTING ENGINEERS, INC.  
FALMOUTH, MAINE