 
 
 
 
 
 
 



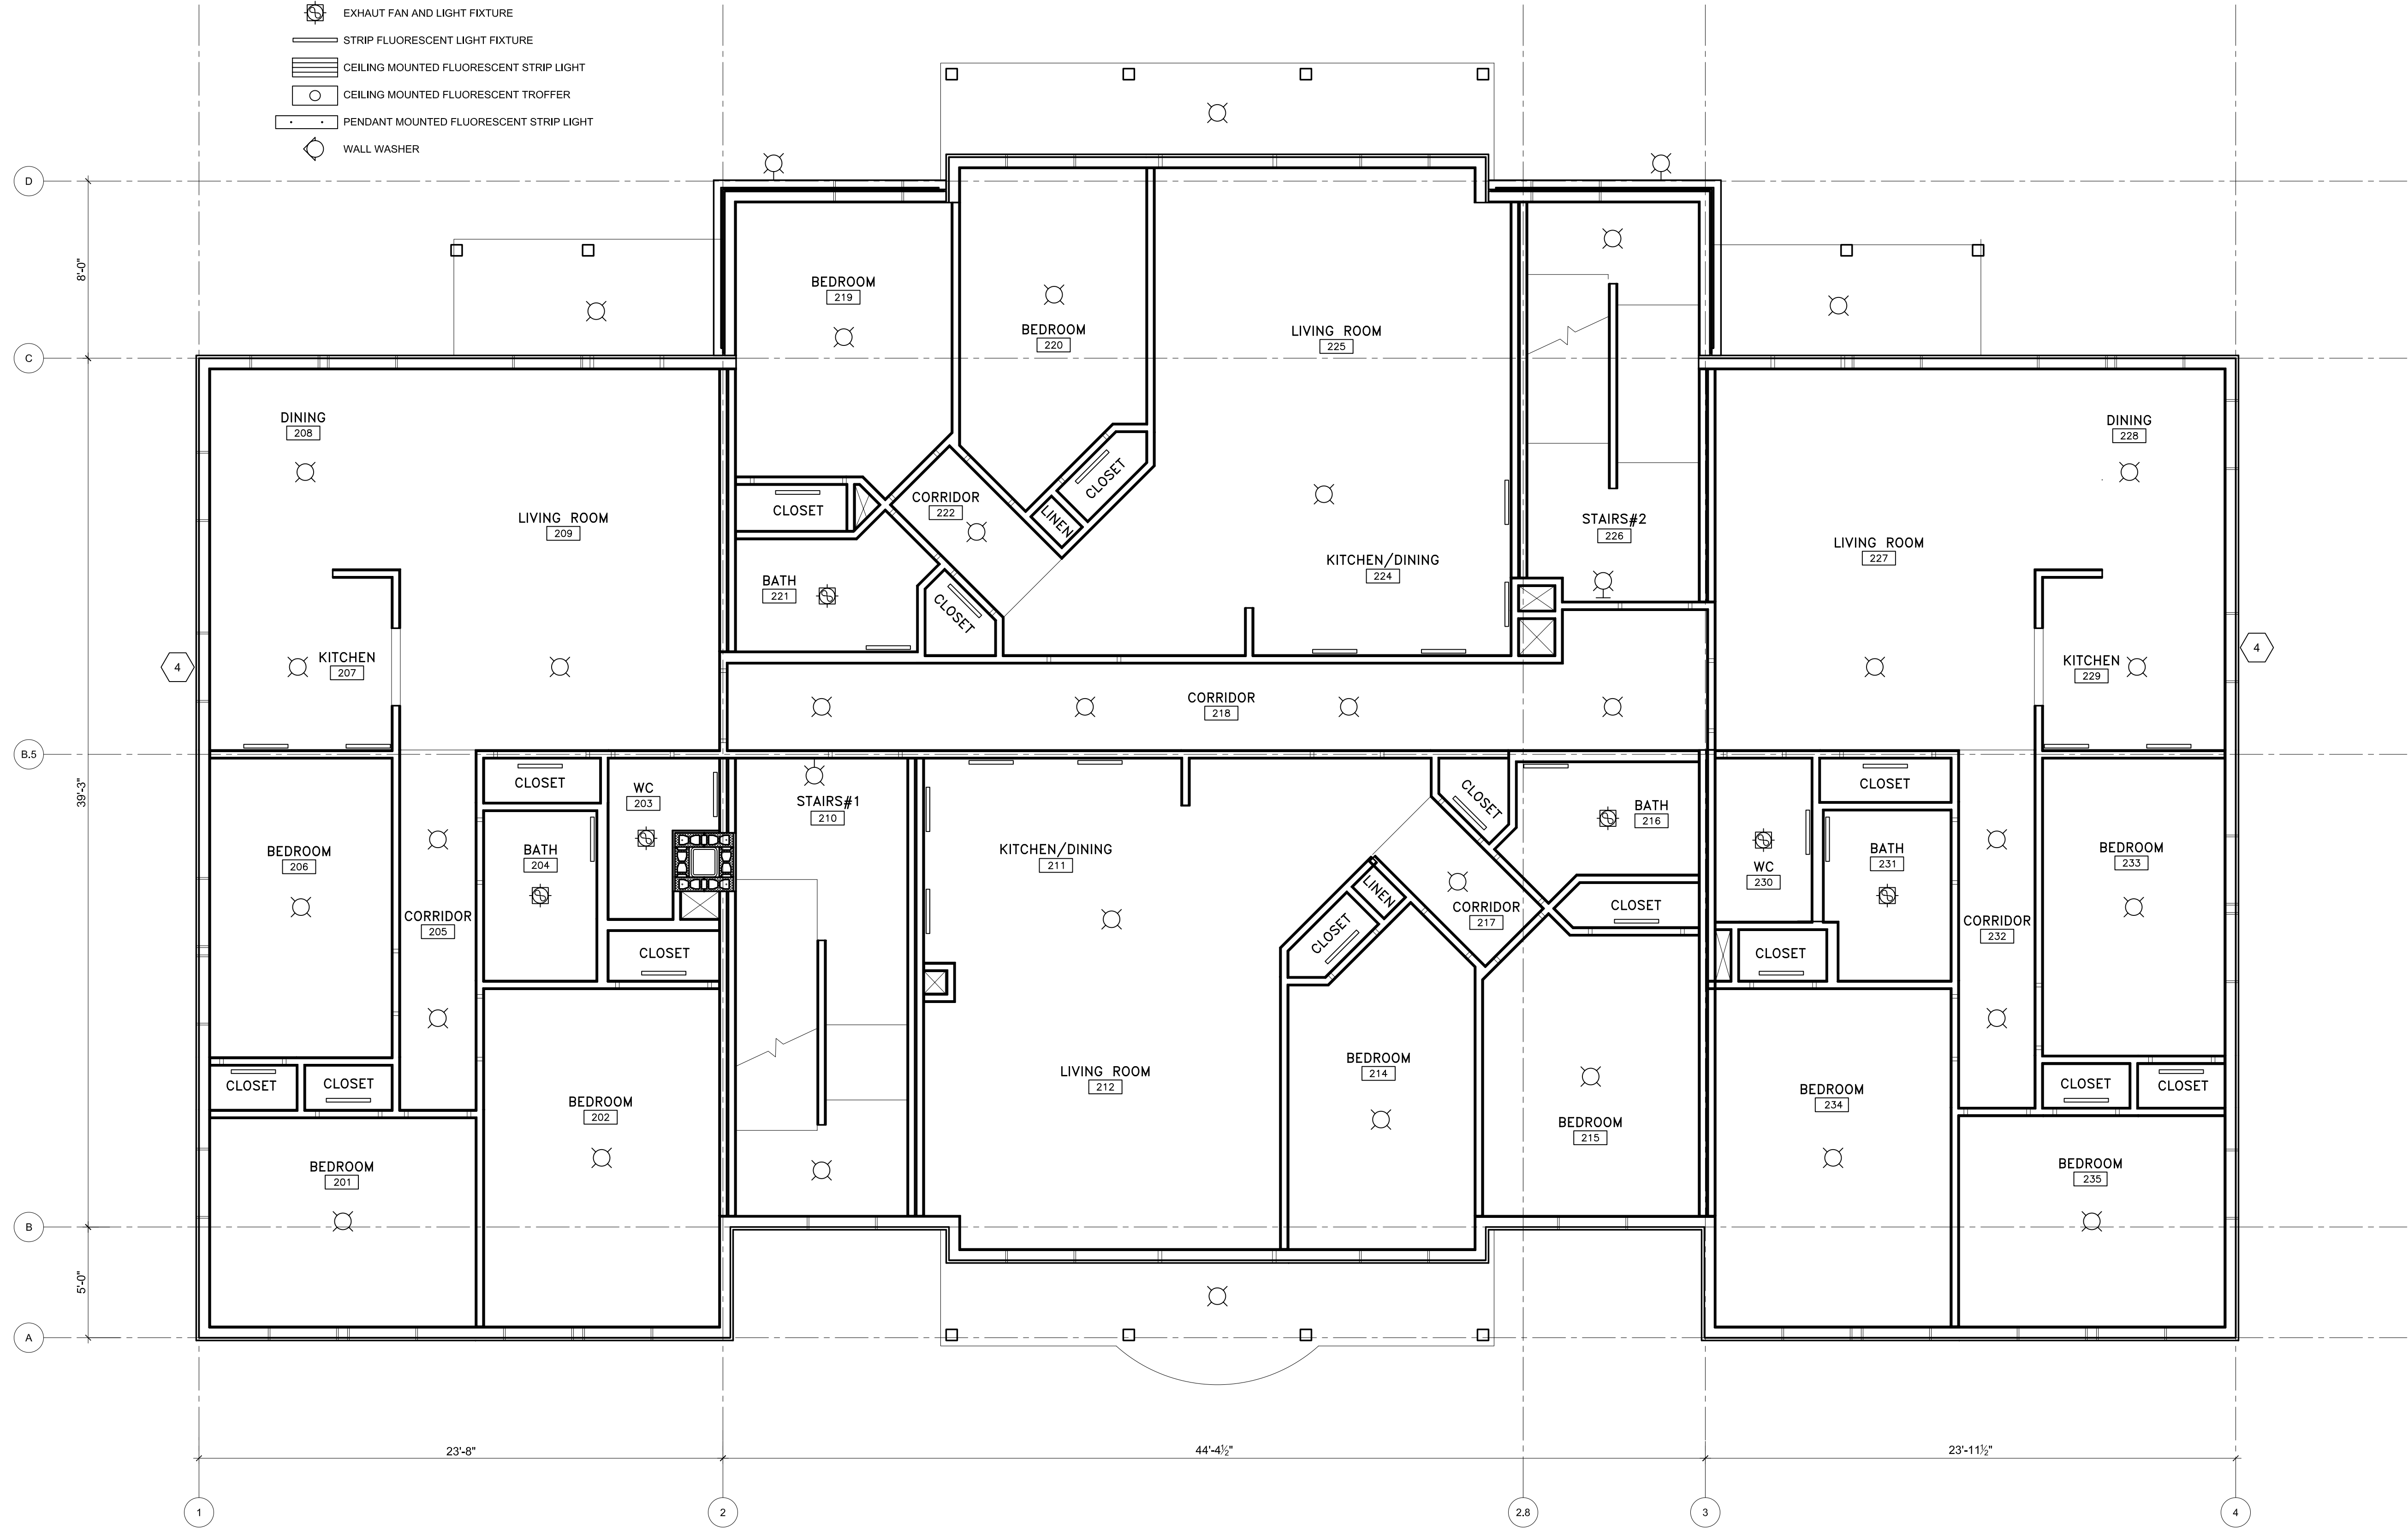
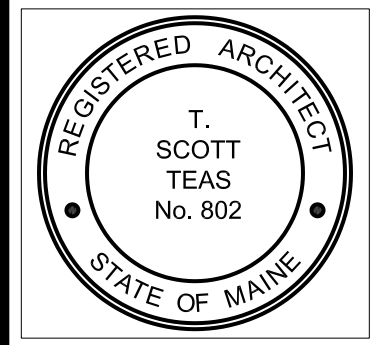
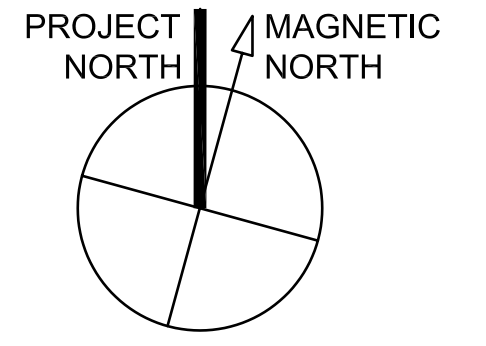
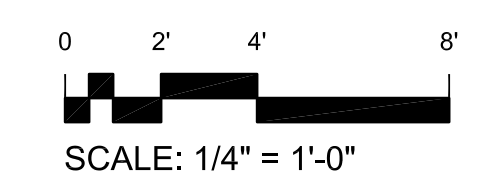


**LEGEND:**

-  CEILING MOUNTED LIGHT FIXTURE
-  WALL MOUNTED LIGHT FIXTURE
-  PENDANT MOUNTED LIGHT FIXTURE
-  FLUORESCENT DOWNLIGHT
-  EXHAUST FAN AND LIGHT FIXTURE
-  STRIP FLUORESCENT LIGHT FIXTURE
-  CEILING MOUNTED FLUORESCENT STRIP LIGHT
-  CEILING MOUNTED FLUORESCENT TROFFER
-  PENDANT MOUNTED FLUORESCENT STRIP LIGHT
-  WALL WASHER




**1** 2ND FLOOR REFLECTED CEILING PLAN BUILDING A  
1/4" = 1'-0"



TFH ARCHITECTS



**GRANT & MELLEEN SREET**  
**PARKSIDE NEIGHBORHOOD CENTER & AFFORDABLE HOUSING**  
**PEOPLE'S REGIONAL OPPORTUNITY PROGRAM**  
**PORTLAND, MAINE**

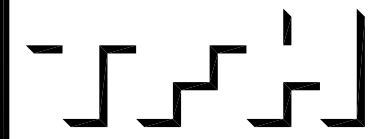

TFH ARCHITECTS  
100 COMMERCIAL STREET  
PORTLAND MAINE 04101  
TELEPHONE 207 775 6141  
ARCHITECTURE PLANNING

**CONSULTANTS:**  
**CIVIL:** Prichard & Greer  
170 US Route One  
Farmton, ME 04105  
207-785-0242  
**STRUCTURAL:** Structural Design Consulting  
Five Baskin Lane  
Farmton, ME 04105-2448  
207-878-8030  
**MECHANICAL:** Whitney Engineering  
10 Danforth Place  
Portland, ME 04102  
207-833-2921  
**ELECTRICAL:** Bennett Engineering  
7 Bennett Road  
Freeport, ME 04032  
207-865-0475

**REVISIONS:**

DATE: 01/29/04  
 PROJECT No. 0114  
 DRAWN BY: DAM/SA  
 CHECKED BY: TST  
 SCALE: AS NOTED

SHEET TITLE:  
2ND FLOOR  
REFLECTED  
CEILING PLAN

**BUILDING A**  
**A1.7**