


TFH ARCHITECTS

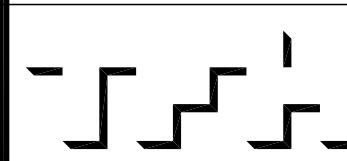

GRANT & MILLEN SREET  
PARKSIDE NEIGHBORHOOD CENTER & AFFORDABLE HOUSING  
PEOPLE'S REGIONAL OPPORTUNITY PROGRAM  
PORTLAND, MAINE



TFH ARCHITECTS  
100 COMMERCIAL STREET  
PORTLAND MAINE 04101  
TELEPHONE 207 775 6141  
ARCHITECTURE PLANNING

CONSULTANTS:

CIVIL:  
Prakham & Greer  
179 US Route One  
Farmton, ME 04105  
207-785-0242  
STRUCTURAL:  
Structural Design Consulting  
Five Baskin Lane  
Farmton, ME 04105-2448  
207-878-8030  
MECHANICAL:  
Whitney Engineering  
10 Danforth Place  
Portland, ME 04102  
207-433-2921  
ELECTRICAL:  
Bennett Engineering  
7 Bennett Road  
Frasport, ME 04032  
207-865-0475

REVISIONS:	REV.	DATE	DESCRIPTION
-	-	-	-
-	-	-	-
-	-	-	-
-	-	-	-

DATE: 01/29/04

PROJECT No. 0114

DRAWN BY: AWH

CHECKED BY: RPW


SCALE: AS NOTED

SHEET TITLE:



3RD FLOOR PLAN

BUILDING A

HVAC1.3

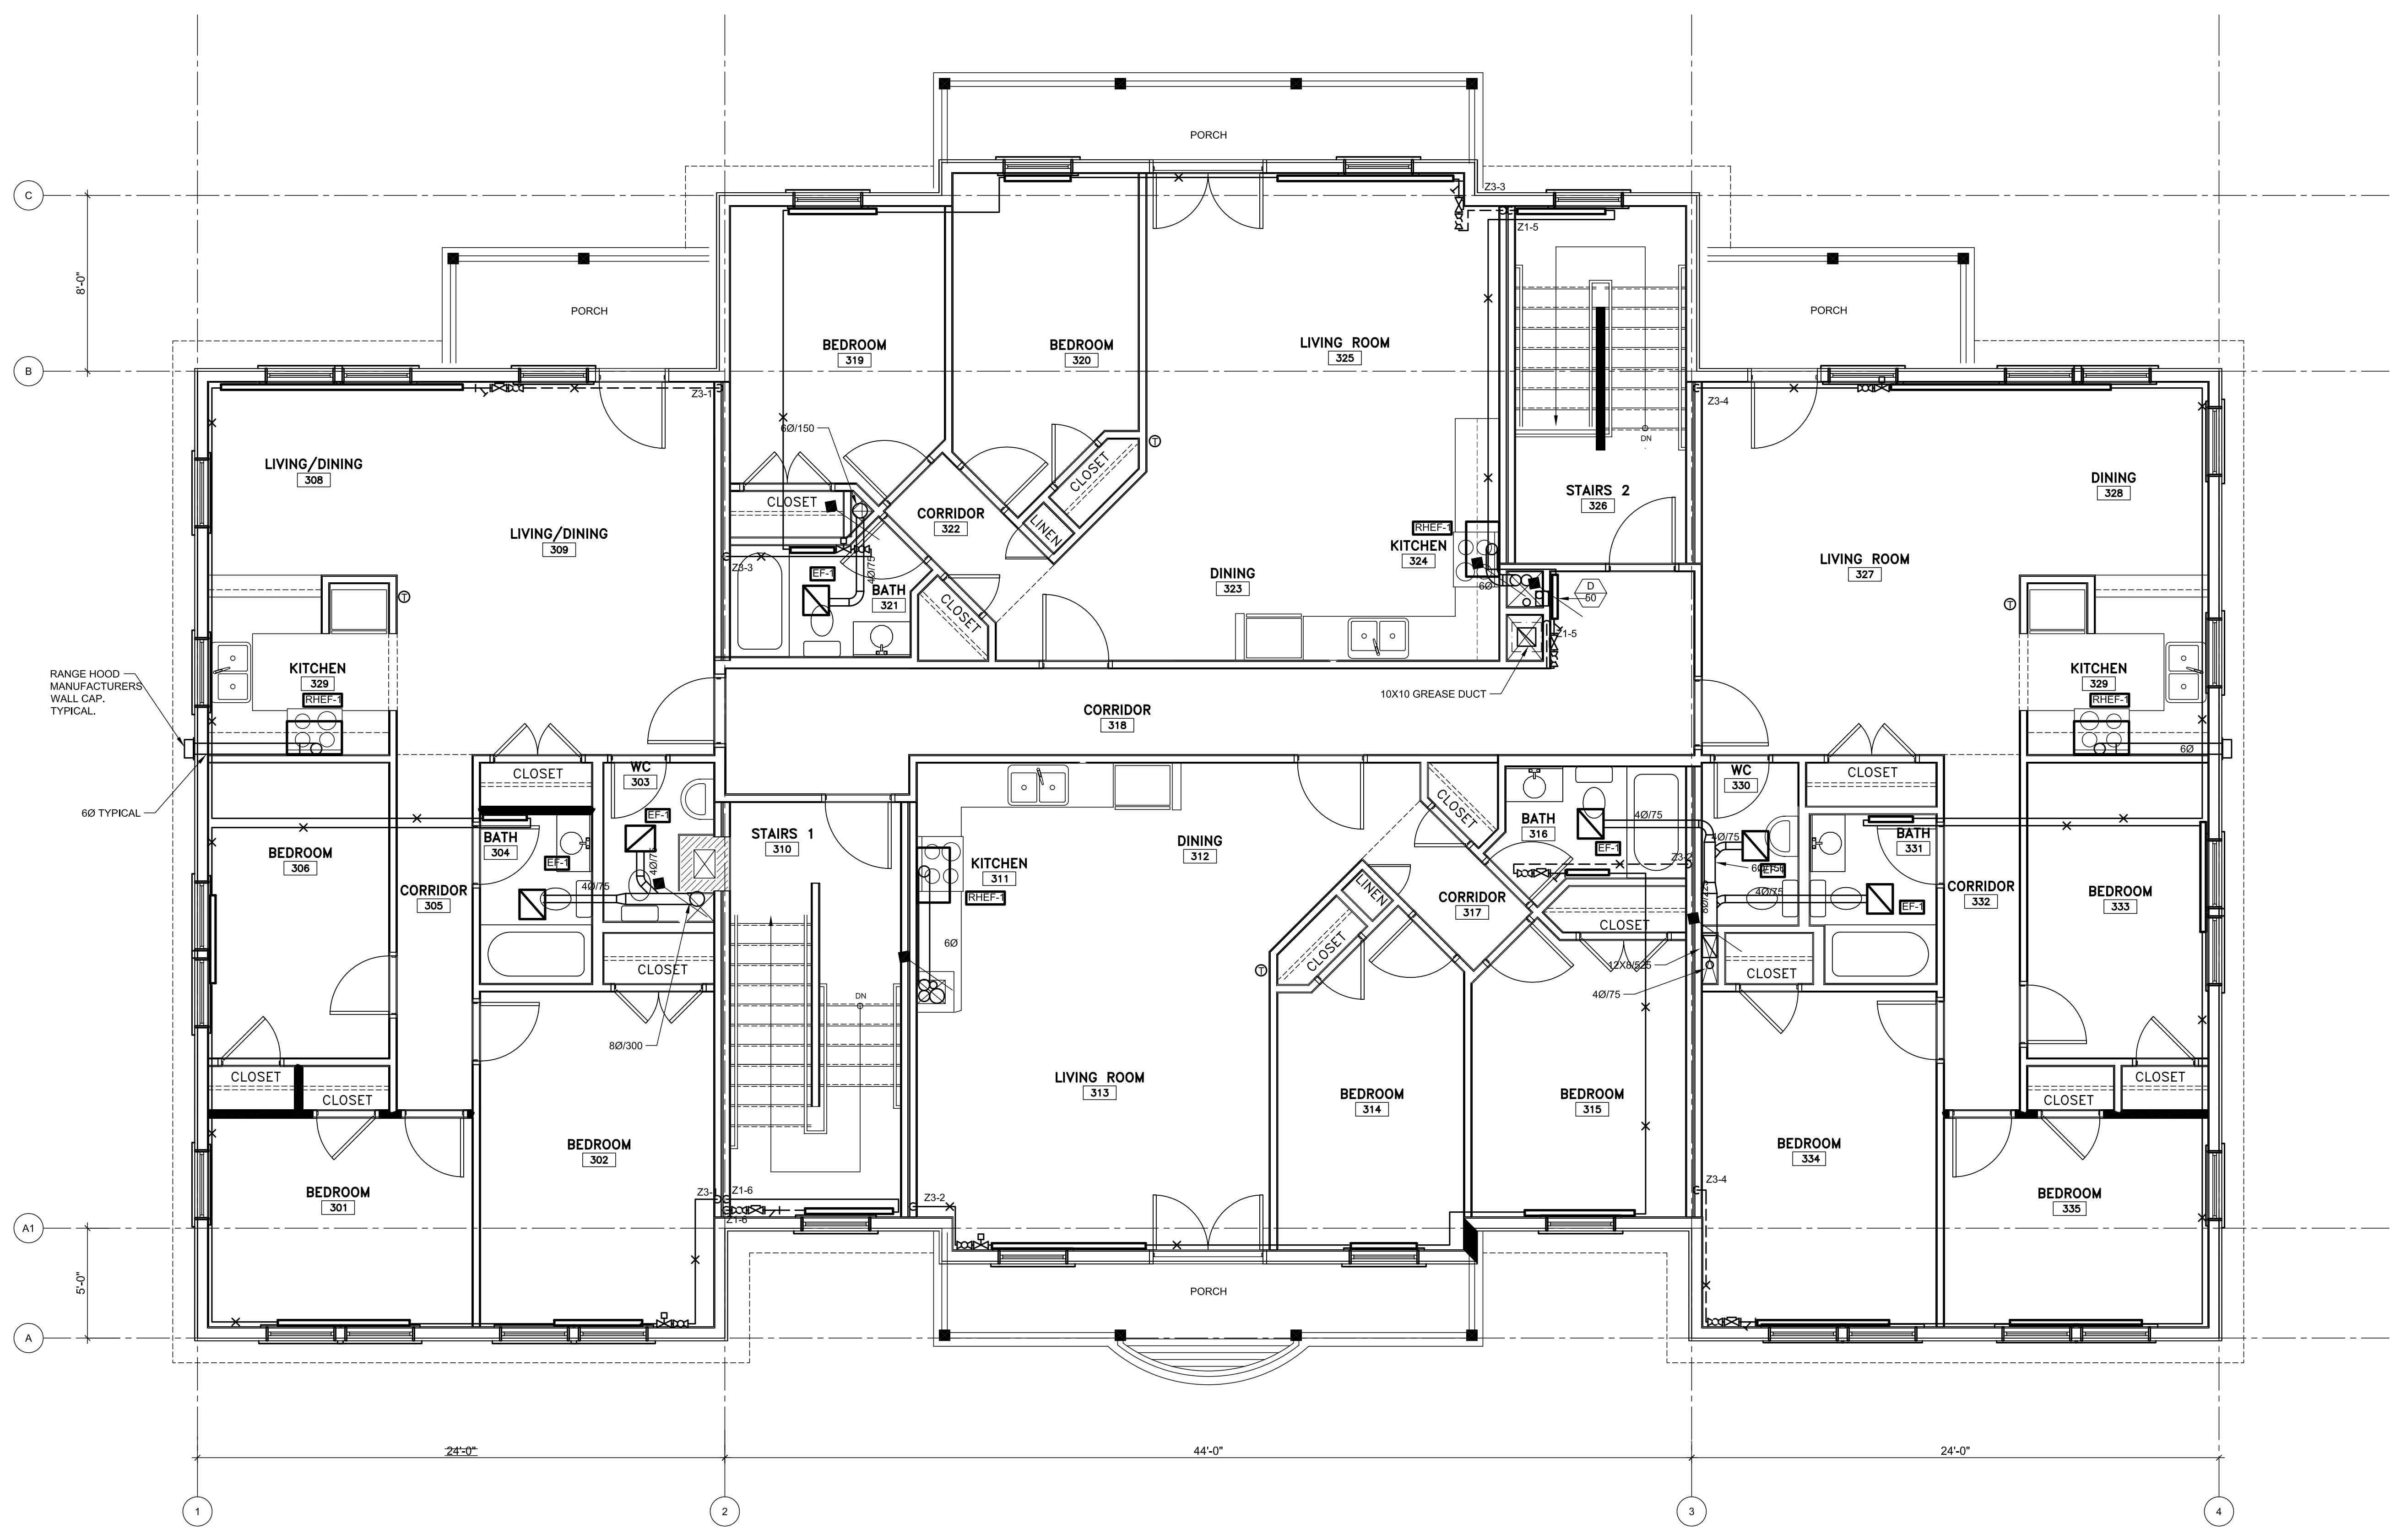

1 3RD FLOOR PLAN BUILDING A - HVAC  
1/4" = 1'-0"

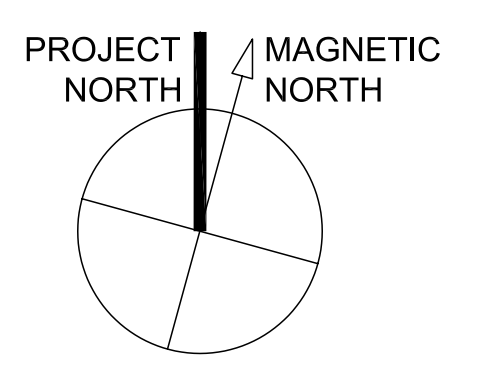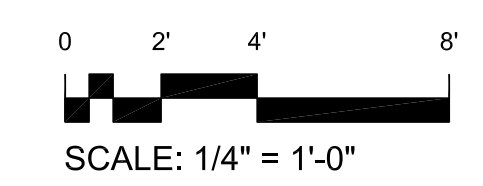

T:\00\_TFH Projects\PROP0114\_Melan Grant\Rev\Proposed\Whitney\021004\_bld.dwg, 2/23/04 3:51 PM