


REVISION	DESCRIPTION	DATE
0	ISSUED FOR REVIEW & APPROVAL	10/19/2013

RESERVED FOR CITY STAMP

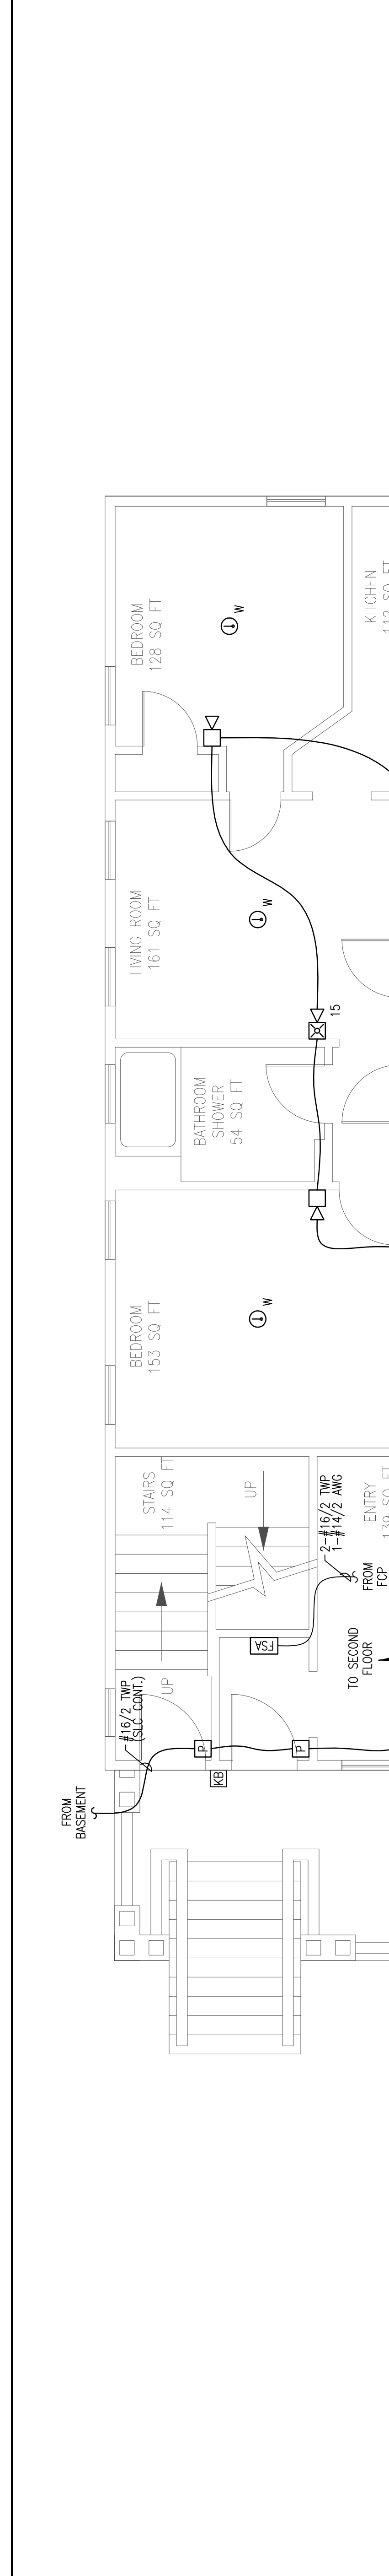

CUNNINGHAM
Security Systems
10 Princes Point Road, Yarmouth, Maine 04096
Office: 207.846.3350 • Fax: 207.846.6080

FIRST FLOOR FIRE ALARM PLAN
108 SHERMAN STREET
PORTLAND, MAINE 04101

DRAWN	JPB UNICAD JOB #13608
CHECKED	WAYNE B. HAWES NGEET N° 90496
DATE	10/18/2013
REVISION	0
SCALE	1/4"=1'-0"



UNICAD Inc.
www.unicad.net
575 W. 40th St.
Office: 603.865.5410
www.unicad.net Fire Alarm Design & Drafting Services

FA-3