

REVISION	DESCRIPTION	DATE
0	ISSUED FOR REVIEW & APPROVAL	10/19/2013

RESERVED FOR CITY STAMP

CUNNINGHAM

Security Systems

10 Princes Point Road, Yarmouth, Maine 04096
Office: 207.846.3350 • Fax: 207.846.6080


SECOND FLOOR FIRE ALARM PLAN

**108 SHERMAN STREET
PORTLAND, MAINE 04101**

DRAWN	JPB UNICAD JOB #13608
CHECKED	WAYNE B. HAWES NGEET N 90496
DATE	10/18/2013
REVISION	0
SCALE	1/4"=1'-0"

FA-4

UNICAD Inc.
www.unicad.net
Fire Alarm Design & Drafting Services

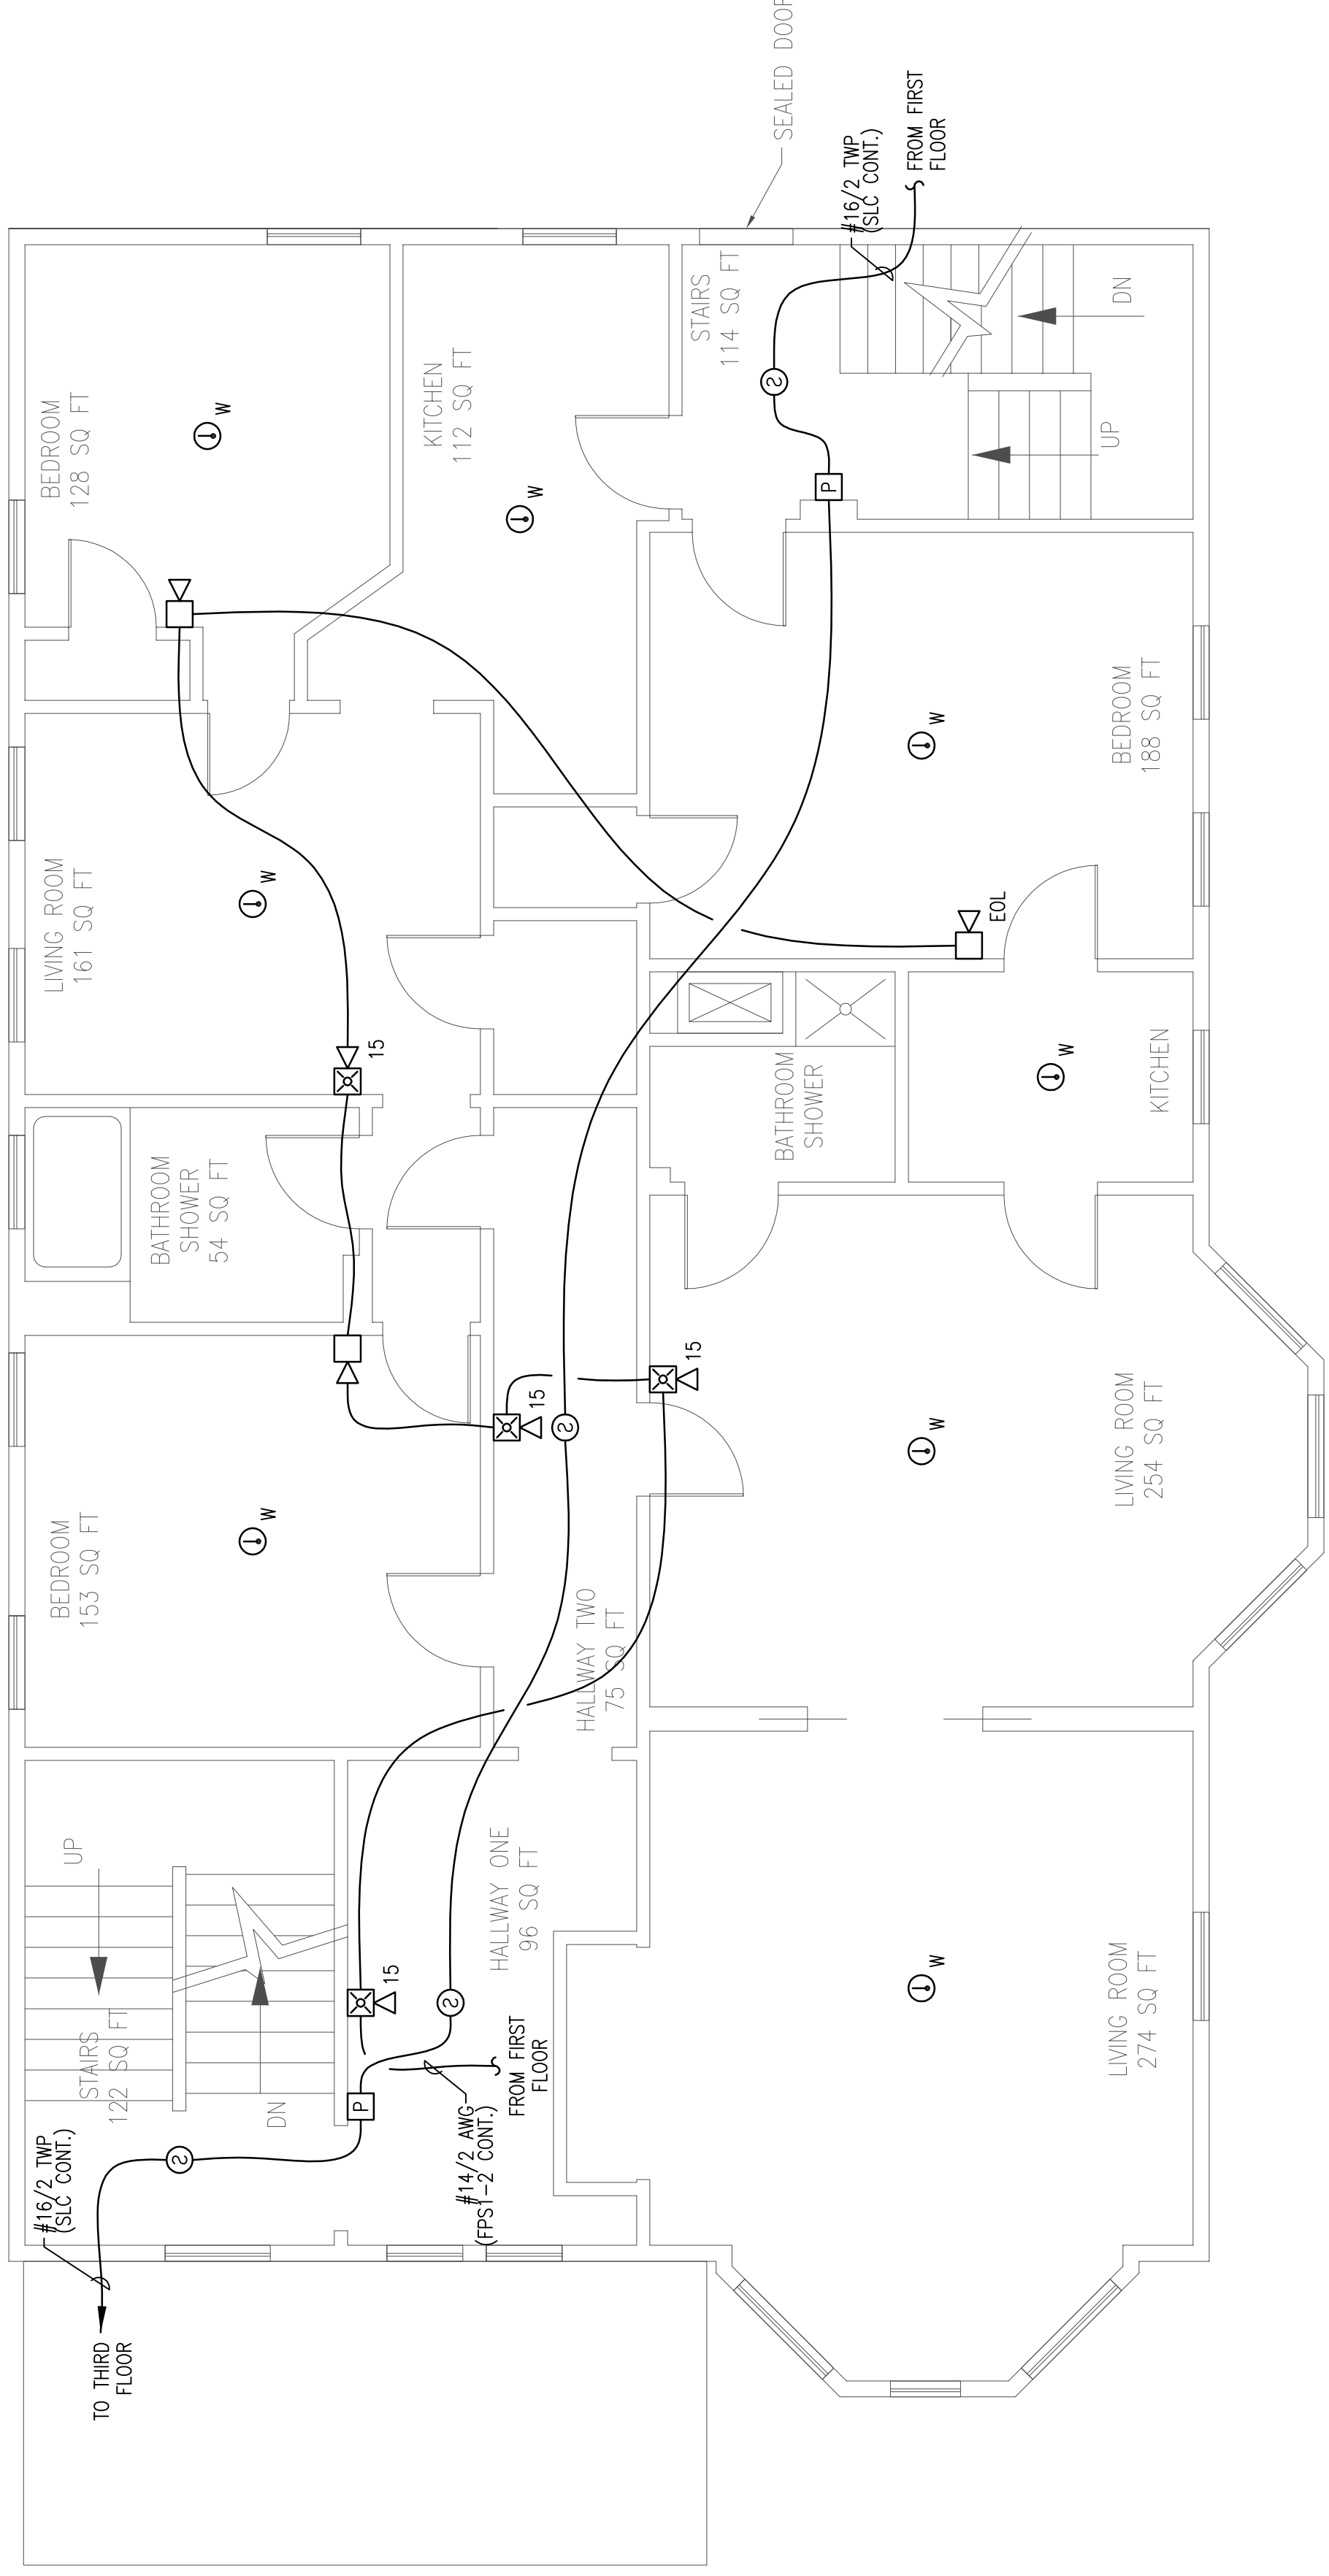

SECOND FLOOR FIRE ALARM PLAN
SCALE: 1/8"=1'-0"

