

REVISION	DESCRIPTION	DATE
0	ISSUED FOR REVIEW & APPROVAL	10/19/2013

RESERVED FOR CITY STAMP

CUNNINGHAM
Security Systems

10 Princes Point Road, Yarmouth, Maine 04096
Office: 207.846.3350 • Fax: 207.846.6080

**108 SHERMAN STREET
PORTLAND, MAINE 04101**


THIRD FLOOR FIRE ALARM PLAN

DRAWN	JPB	UNICAD JOB #13608
CHECKED	WAYNE B. HAWES	UNICAD # 90496
DATE	10/18/2013	
REVISION	0	
SCALE	1/4"=1'-0"	

FA-5

UNICAD Inc.
www.unicad.net
575 W. 40th St.
Portland, ME 04102
Office: 603.865.5410

Fire Alarm Design & Drafting Services

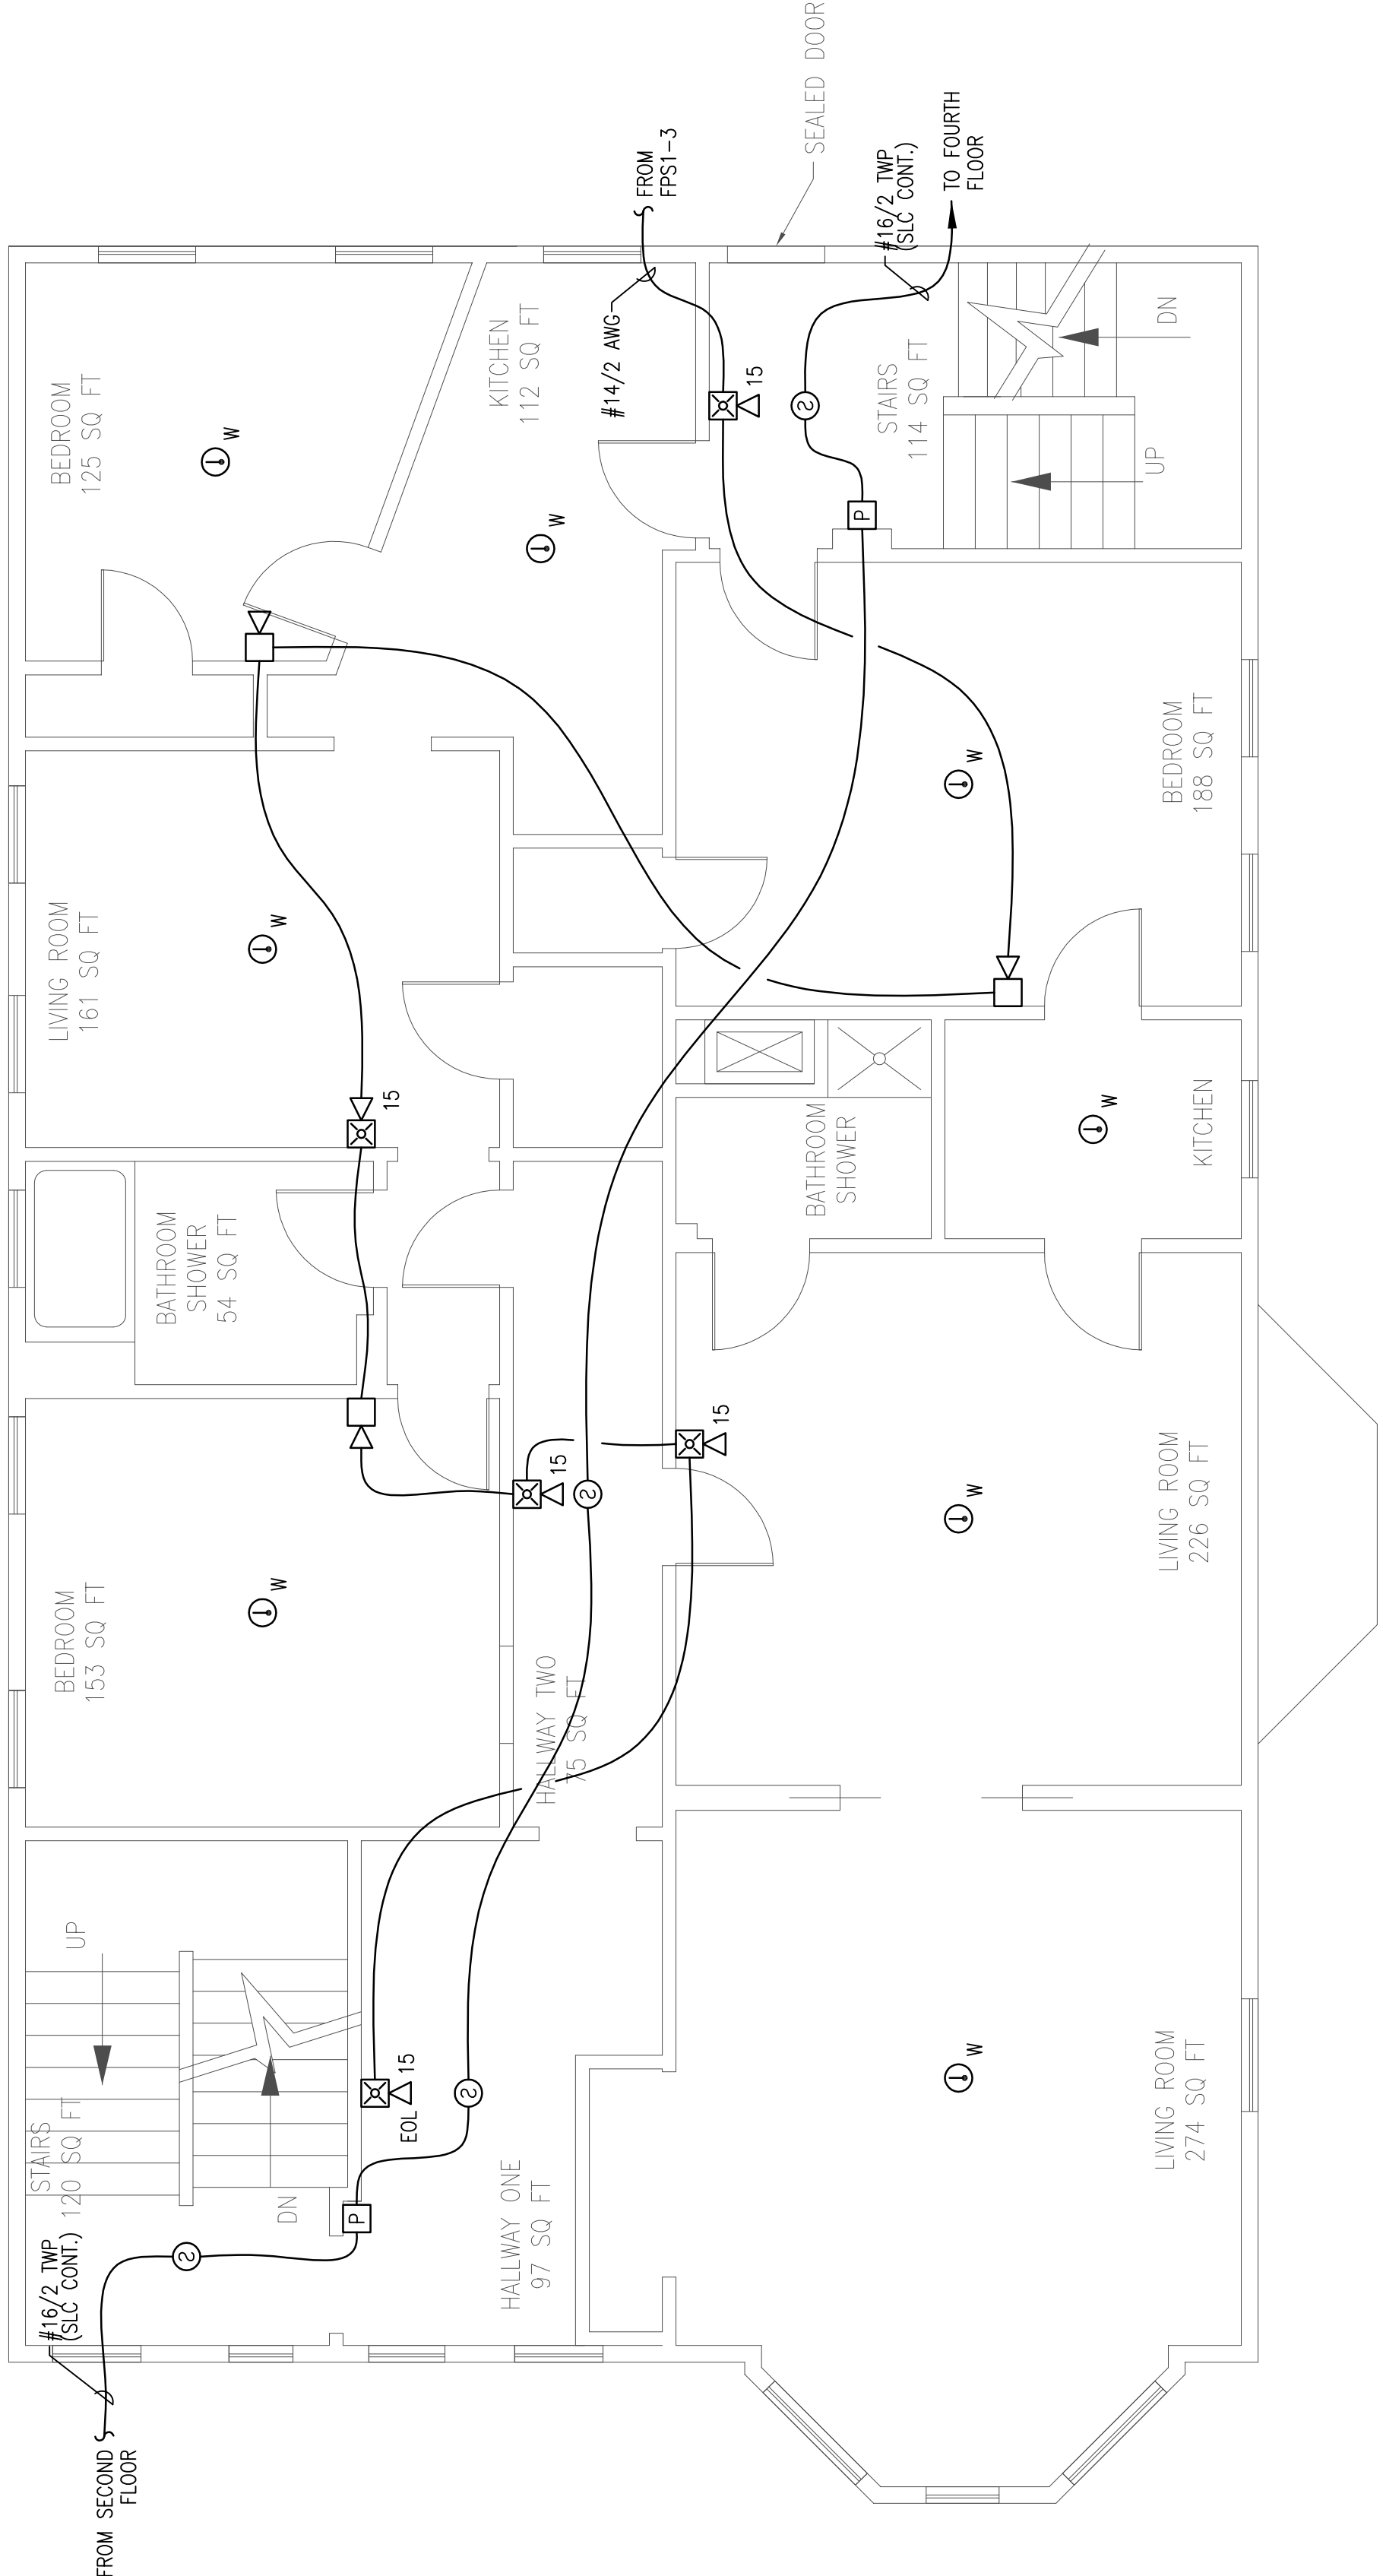

THIRD FLOOR FIRE ALARM PLAN
SCALE: 1/8"=1'-0"