

NOTES:

1. SEE SHEET T-1 FOR LEGEND, ABBREVIATIONS & GENERAL NOTES.
2. PLAN SHOWS FRAME STRUCTURE ONLY. SHEATHING, GWB, INSULATION & SIDING NOT SHOWN FOR CLARITY.
3. SEE MECHANICAL PLANS FOR FLOOR DRAIN LOCATIONS.

TOILET ACCESSORY KEY NOTES:

| | | |
|-----|------------------------|----------|
| (A) | PAPER TOWEL DISPENSER | BLOCKING |
| (B) | RESERVED | RESERVED |
| (C) | SOAP DISPENSER | BLOCKING |
| (D) | RESERVED | RESERVED |
| (E) | MIRROR | PROVIDE |
| (F) | TOILET PAPER DISPENSER | BLOCKING |
| (G) | 36" GRAB BAR | PROVIDE |
| (H) | 42" GRAB BAR | PROVIDE |
| (I) | SHOWER SEAT | PROVIDE |
| (J) | 2 WALL GRAB BAR | PROVIDE |
| (O) | SHOWER ROD & CURTAIN | PROVIDE |

NOTES/ REVISIONS

-
-

**PORTLAND
SEA DOGS
CLUB HOUSE**

HADLOCK FIELD
PORTLAND, ME


ISSUED FOR
CONSTRUCTION
8/6/07

AE-410


**ENLARGED FLOOR
PLANS**

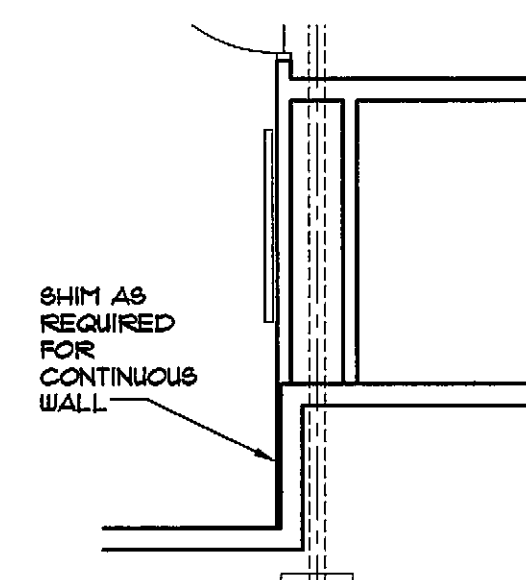


J1
ENLARGED PLAN
SCALE 1/4" = 1'-0"

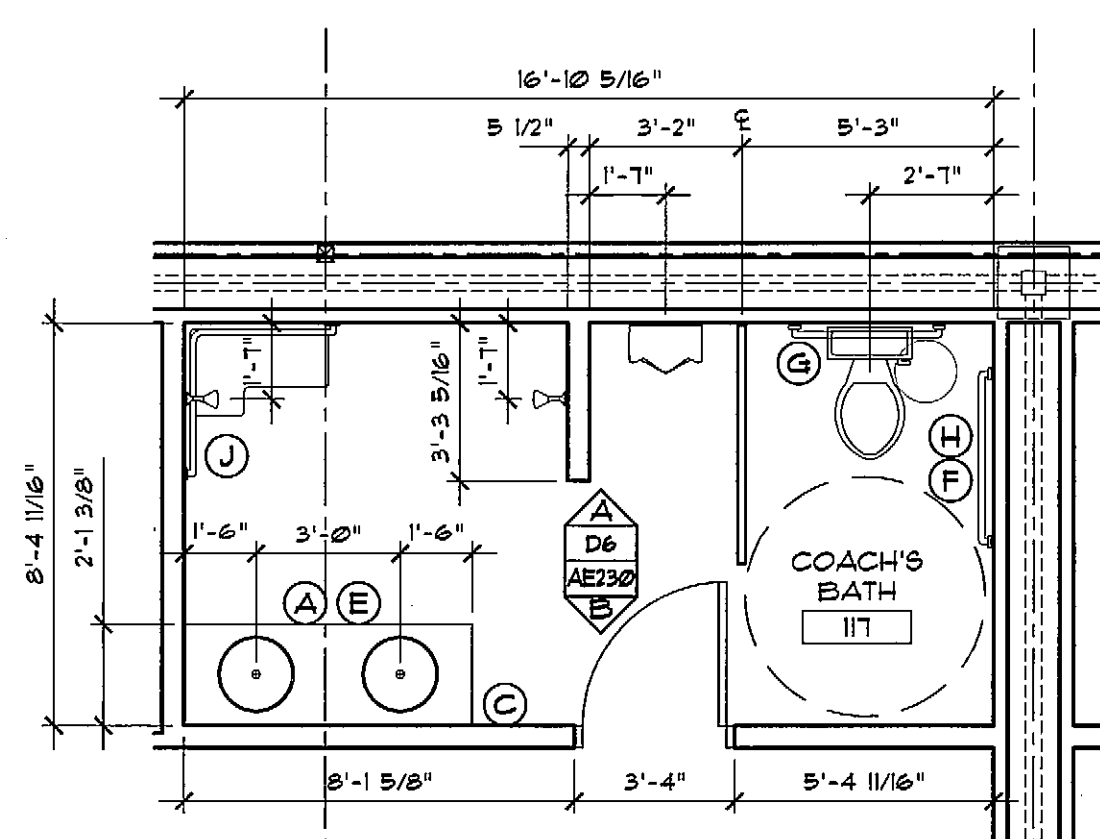

E1
ENLARGED COACH'S BATH
SCALE 1/4" = 1'-0"

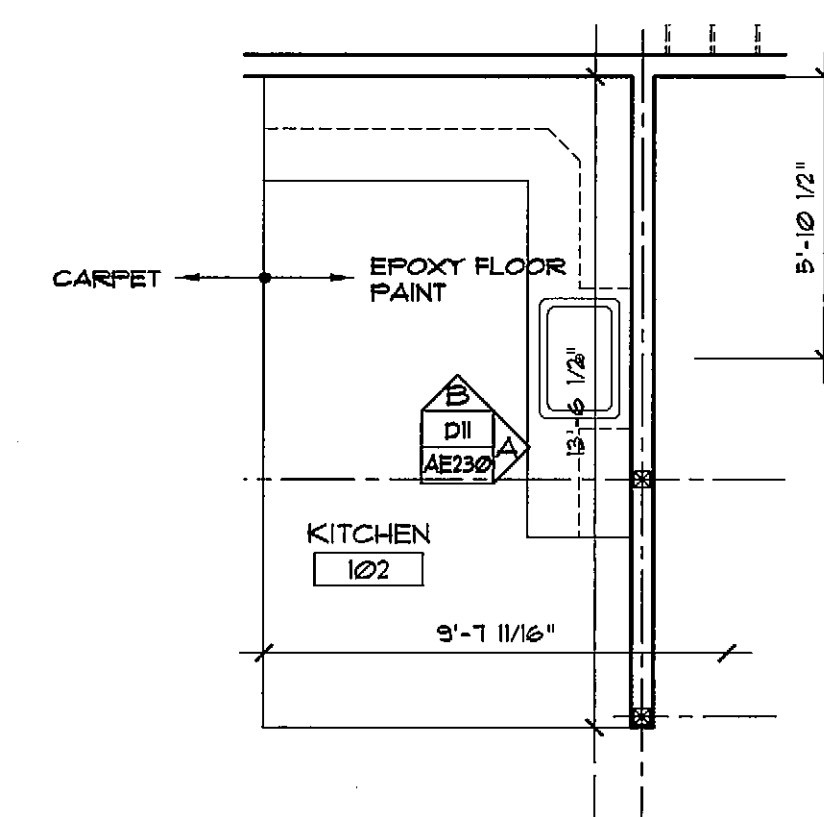

A1
ENLARGED KITCHEN PLAN
SCALE 1/4" = 1'-0"

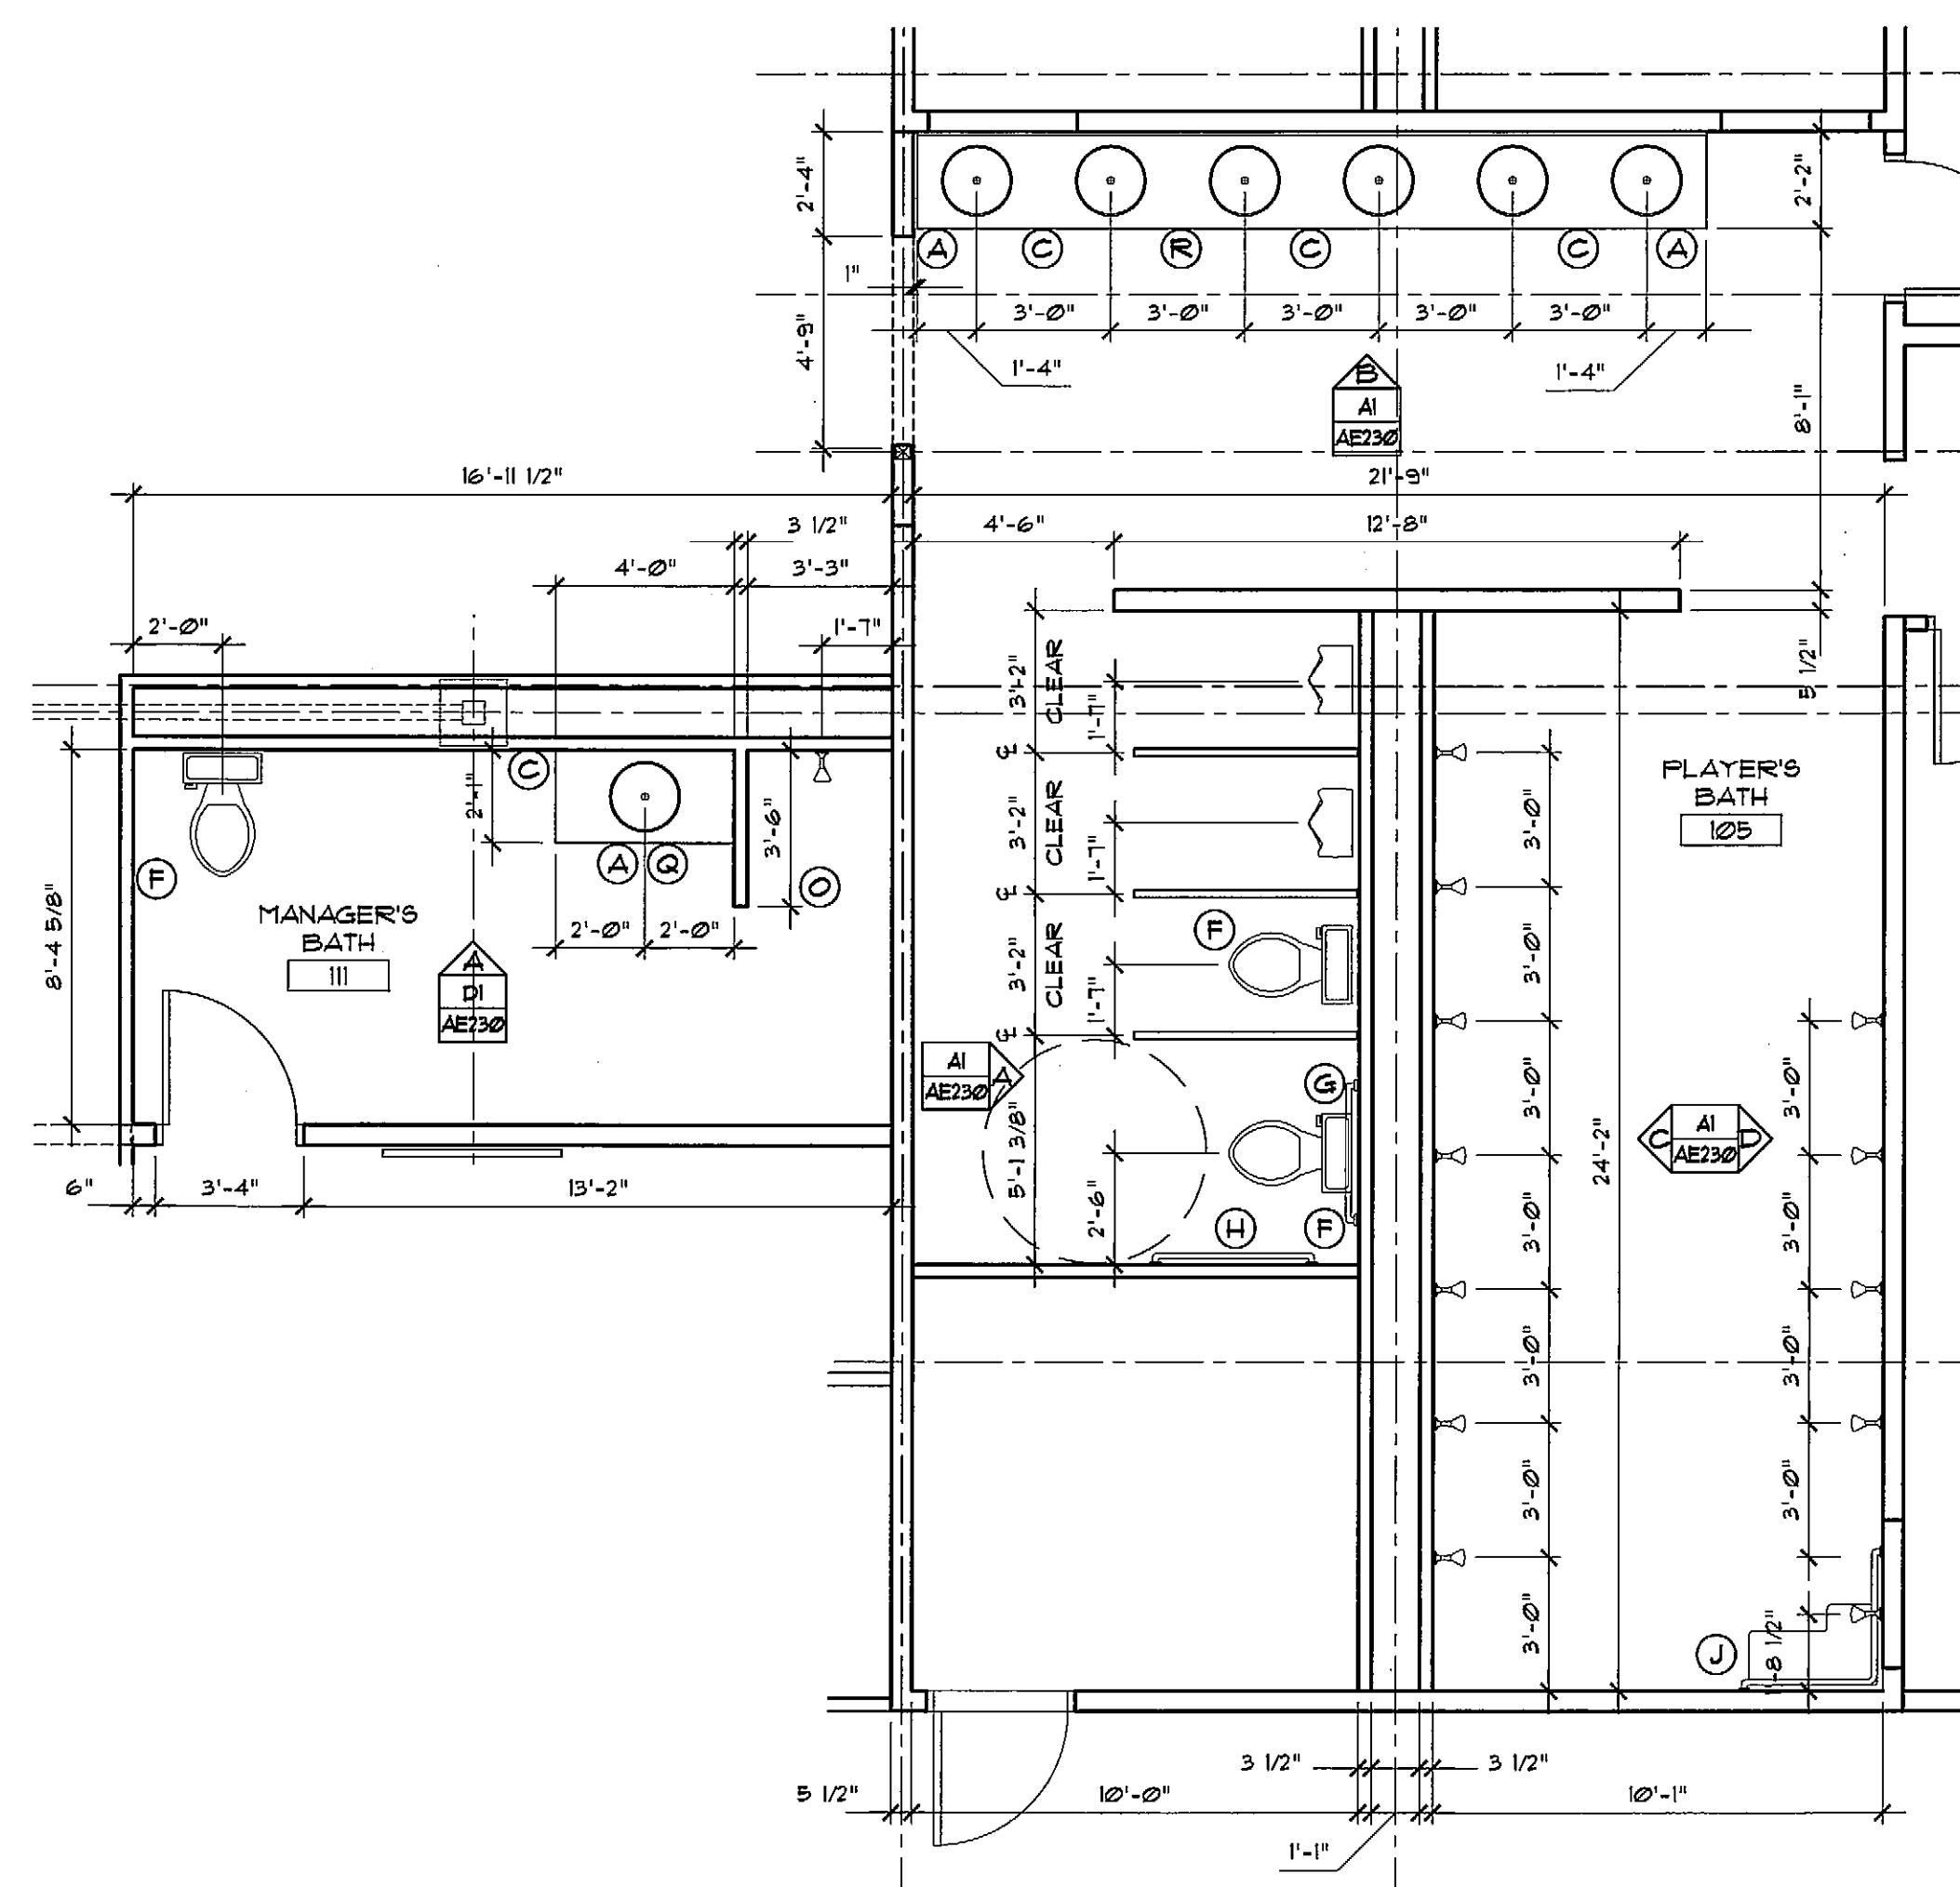

A5
ENLARGED PLAYERS' BATH/MANAGER'S BATH
SCALE 1/4" = 1'-0"