

PO BOX 301
FREEPORT, MAINE
04032

TEL 207-865-1272
FAX 207-865-XXXX

WWW.DOMUSARCHITECTS.NET

NOTE:

- 1. SEE SHEET E-001 FOR LEGEND AND GENERAL NOTES.

KEYED NOTES:

- ① WEATHERPROOF LIGHTING FIXTURE. MOUNT TO UNDERSIDE OF STAGING FOR BULLPEN ROOF. FIXTURES SHALL BE PLACED SUCH THAT THEY WILL NOT BE VISIBLE FROM HOMEPLATE AREA ON FIELD.
- ② WEATHERPROOF LIGHTING FIXTURE. MOUNT TO UNDERSIDE OF BULLPEN FLOOR TO LIGHT STAIRWELL.
- ③ LIGHTING SWITCHES TO BE WEATHERPROOF.
- ④ FURNISH FIRE ALARM MANUAL PULL STATION WITH CLEAR LEXAN "LIFT-TO-OPERATE" COVER TO PROTECT FROM BATTED BALLS.
- ⑤ FURNISH FIRE ALARM HORN/STROBE WITH WIRE CAGE ACCESSORY FOR PROTECTION FROM BATTED BALLS.

NOTES/ REVISIONS

- _____
- _____

**PORTLAND
SEA DOGS
CLUB HOUSE**

HADLOCK FIELD
PORTLAND, ME


ISSUED FOR
CONSTRUCTION
8/6/07

E-102

**SECOND FLOOR
LIGHTING &
FIRE ALARM PLAN**

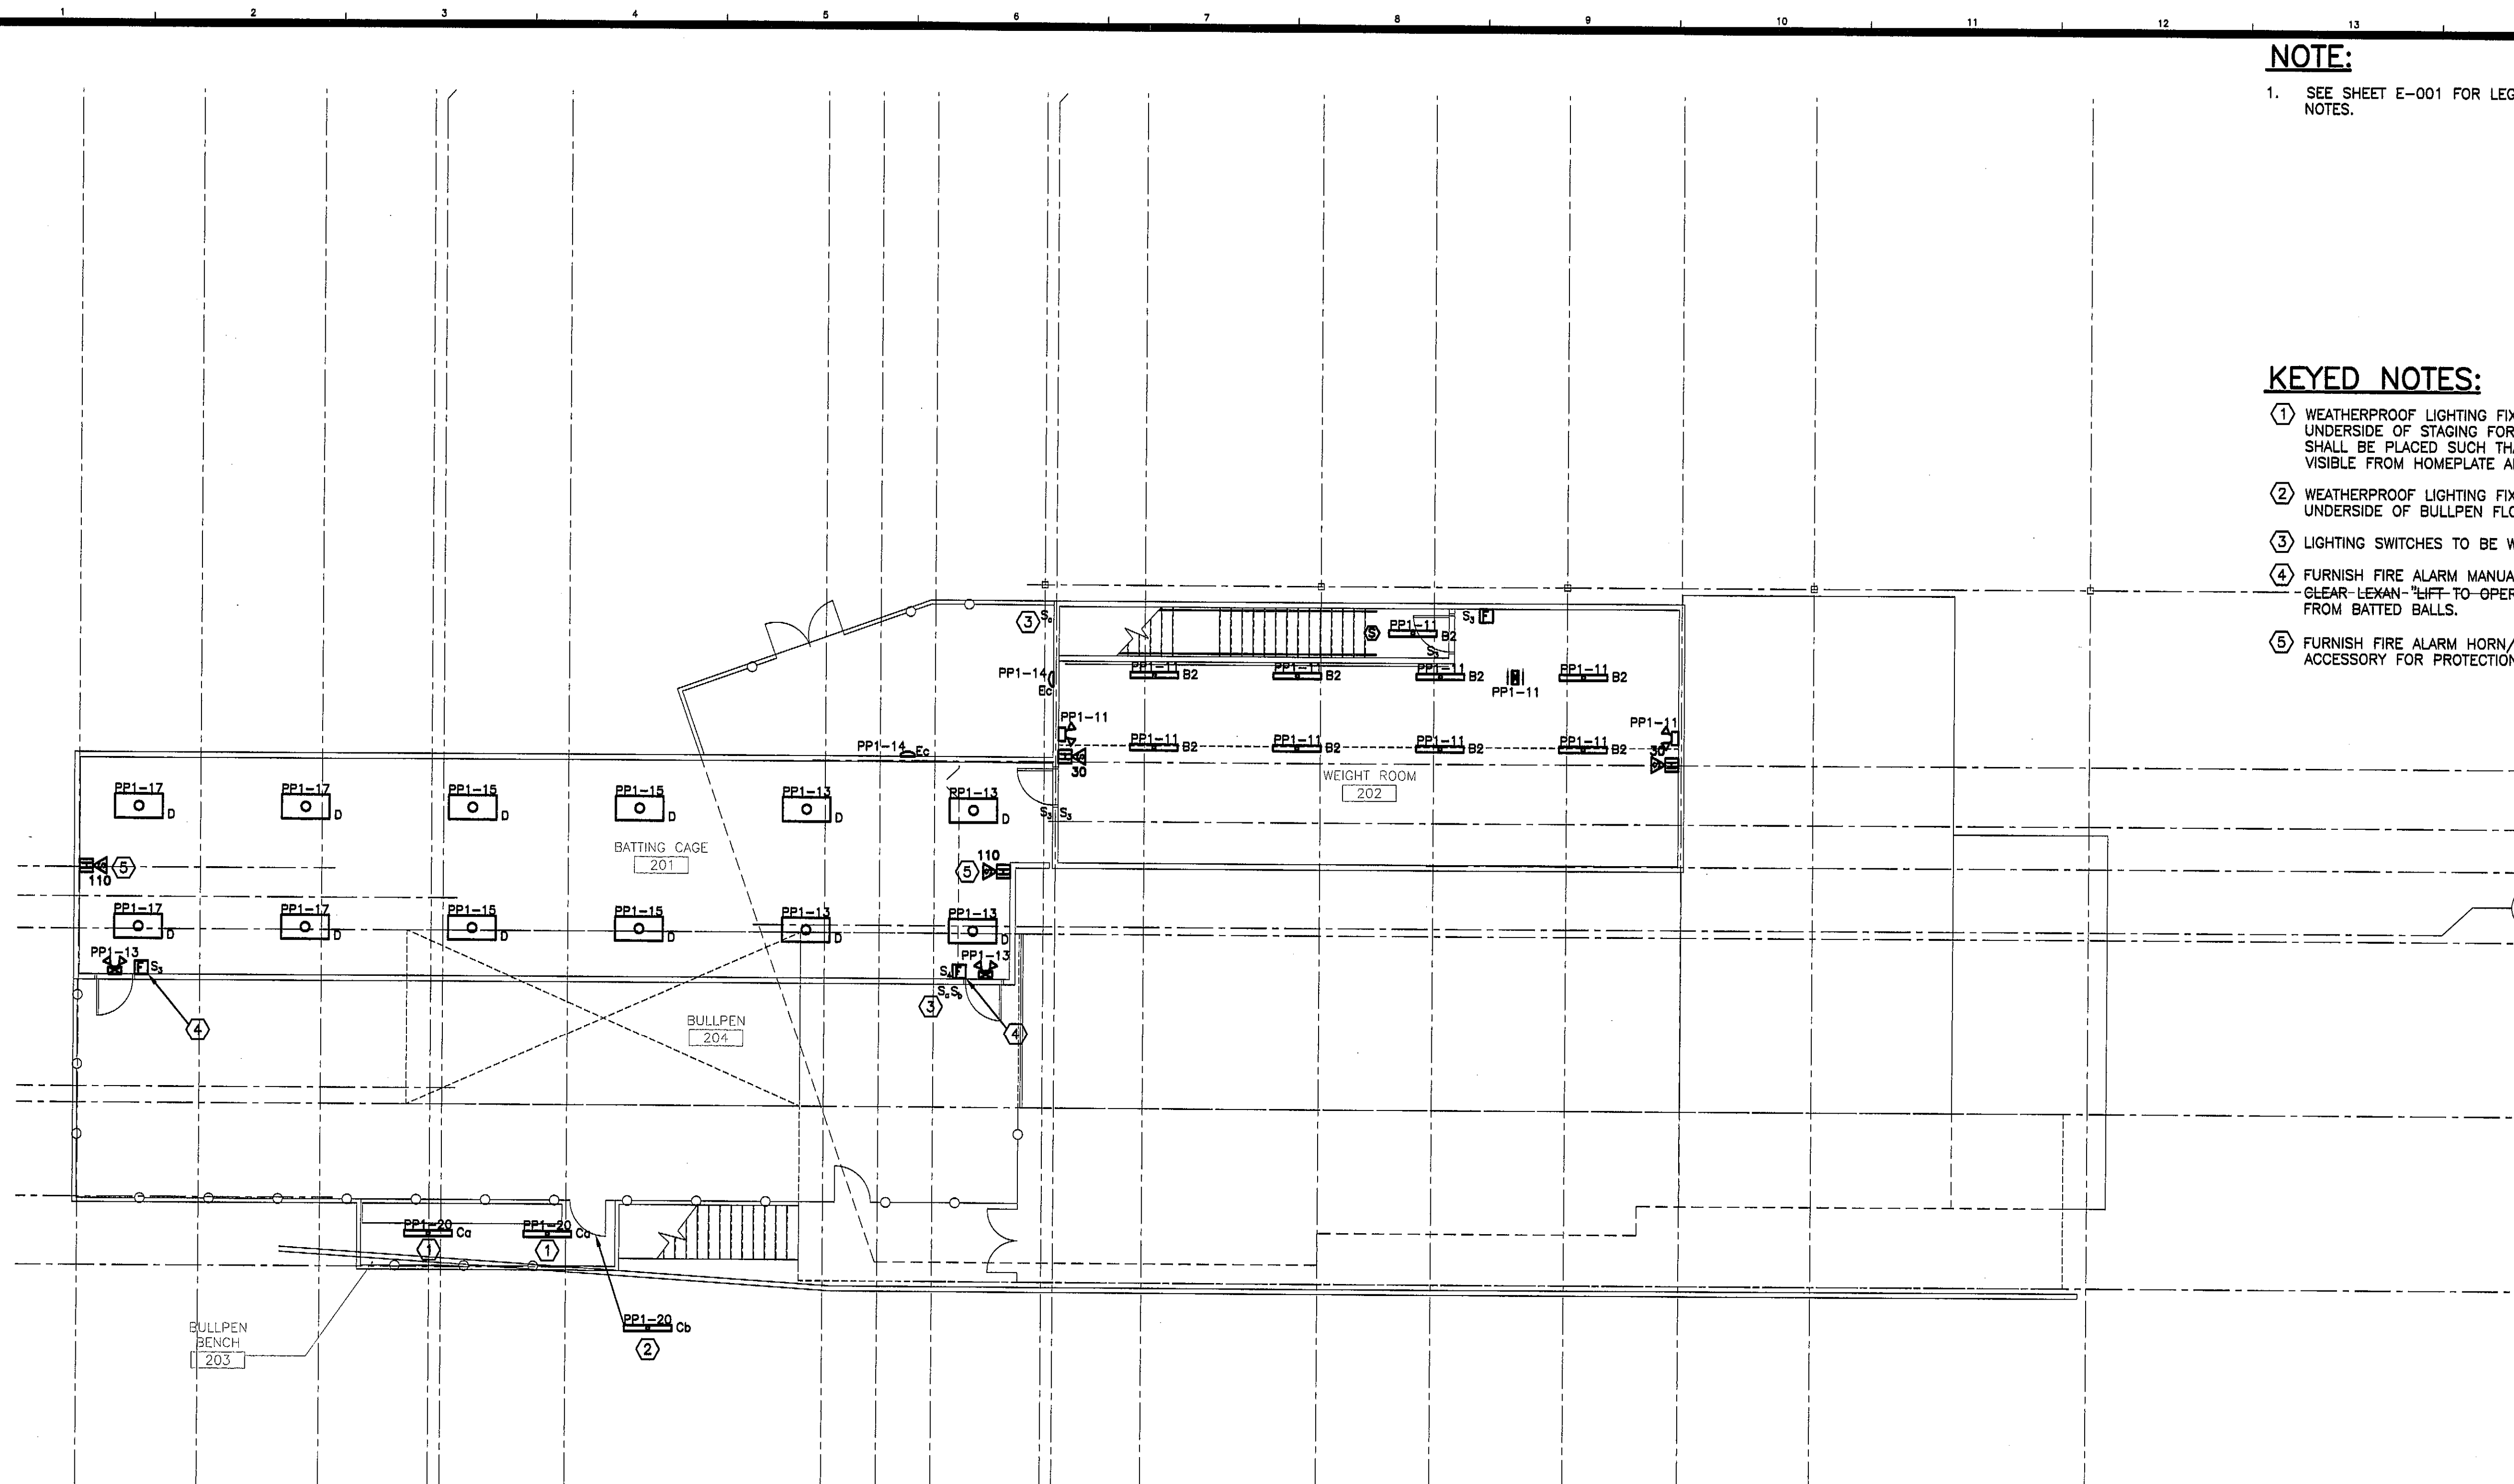

PROJECT
NORTH

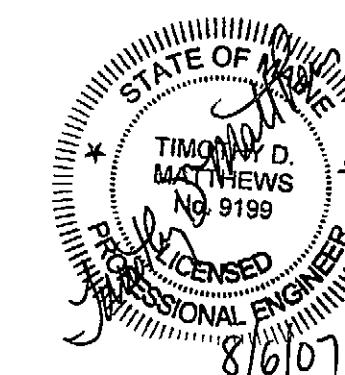

AI
E-102
SCALE: 1/8" = 1'-0"

SWIFTCURRENT
Engineering Services
273 Main Street
Yarmouth, ME 04096
Tel: (207) 847-9280