

NOTE:


1. SEE SHEET E-001 FOR LEGEND AND GENERAL NOTES.

PO BOX 301
FREEPORT, MAINE
04032

KEYED NOTE:

① RE-USE EXISTING EXHAUST FAN LOCATED ON ROOF ABOVE LOCKER ROOM.

TEL 207-865-1272
FAX 207-865-XXXX
WWW.DOMUSARCHITECTS.NET

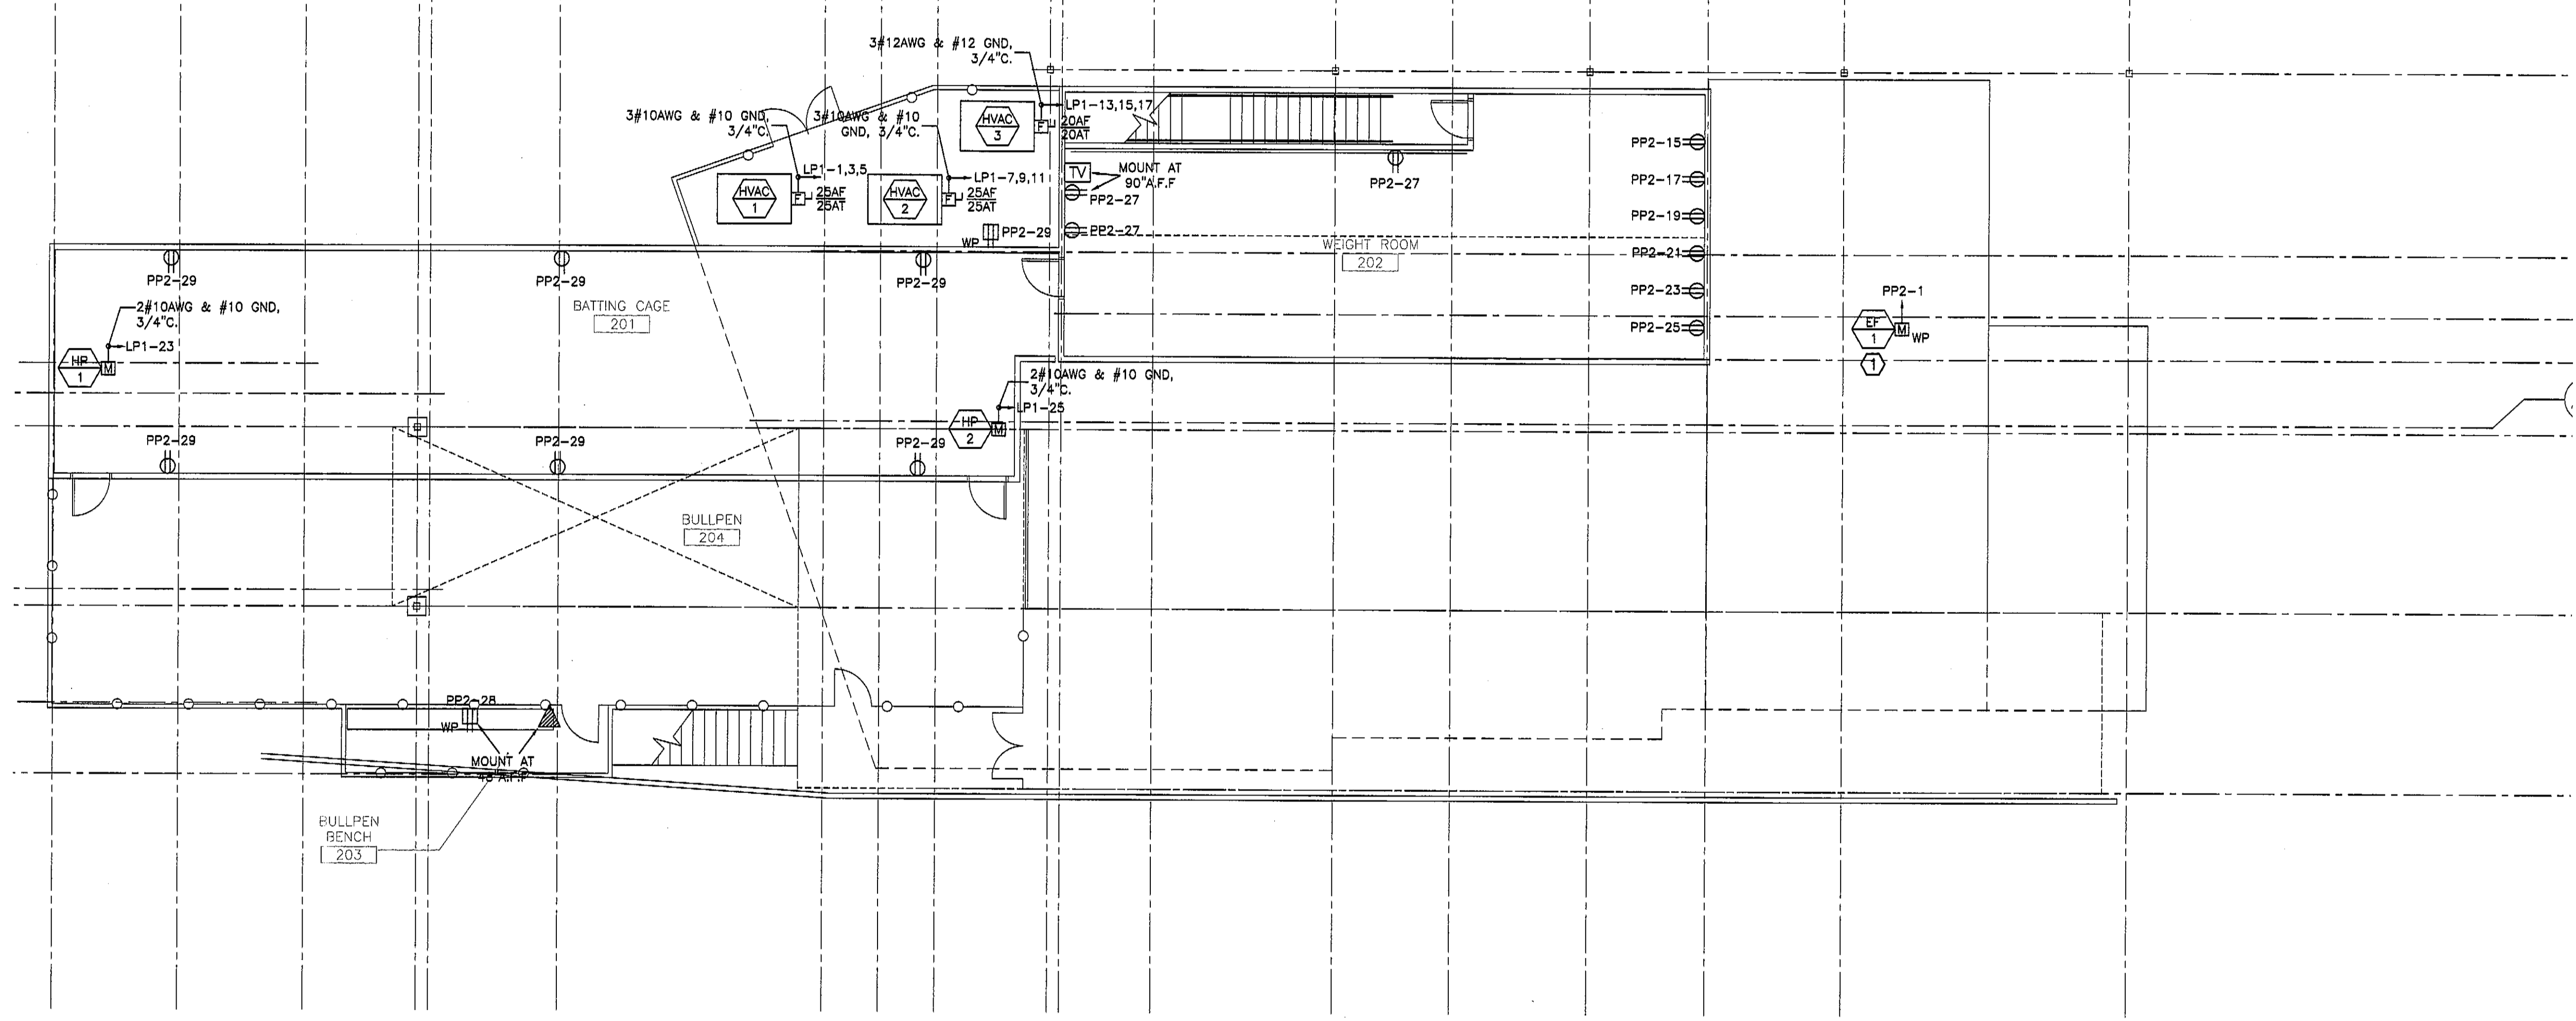

NOTES/ REVISIONS

-
-
**PORTLAND
SEA DOGS
CLUB HOUSE**



HADLOCK FIELD
PORTLAND, ME

ISSUED FOR
CONSTRUCTION
8/6/07

E-104

**SECOND FLOOR
POWER &
SYSTEMS PLAN**

SECOND FLOOR PLAN
SCALE: 1/8" = 1'-0"

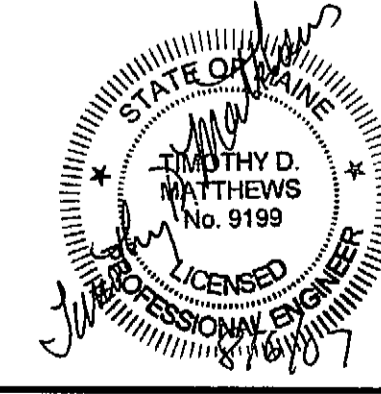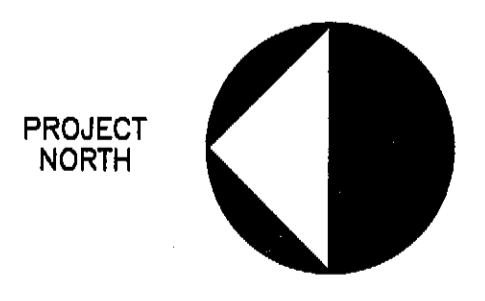

SWIFTCURRENT
Engineering Services

273 Main Street
Yarmouth, ME 04096
Tel: (207) 847-9280