



EQUIPMENT LAYOUT
SCALE: N.T.S.

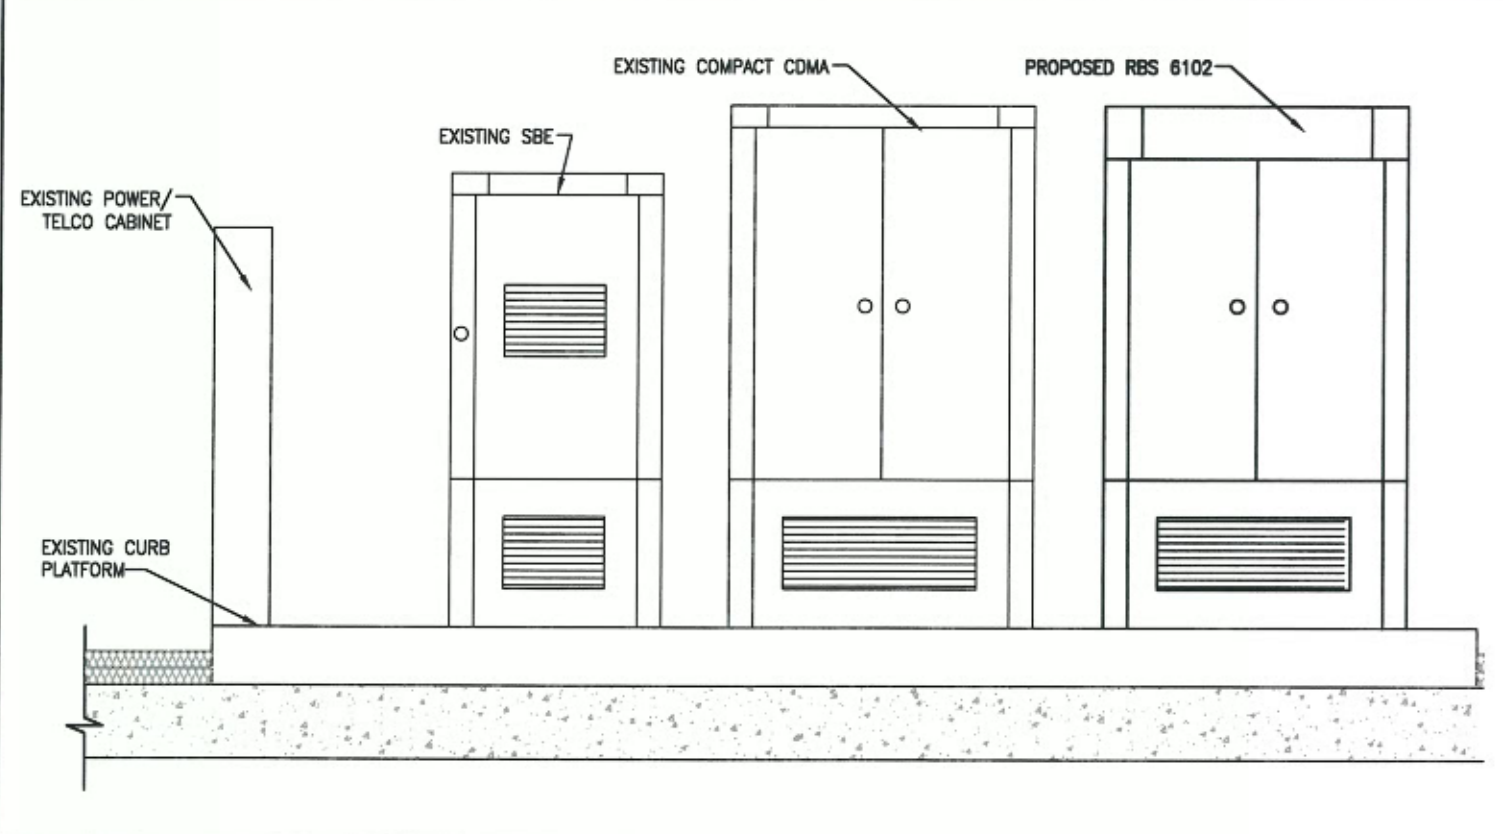

A EQUIPMENT ELEVATION
SCALE: N.T.S.

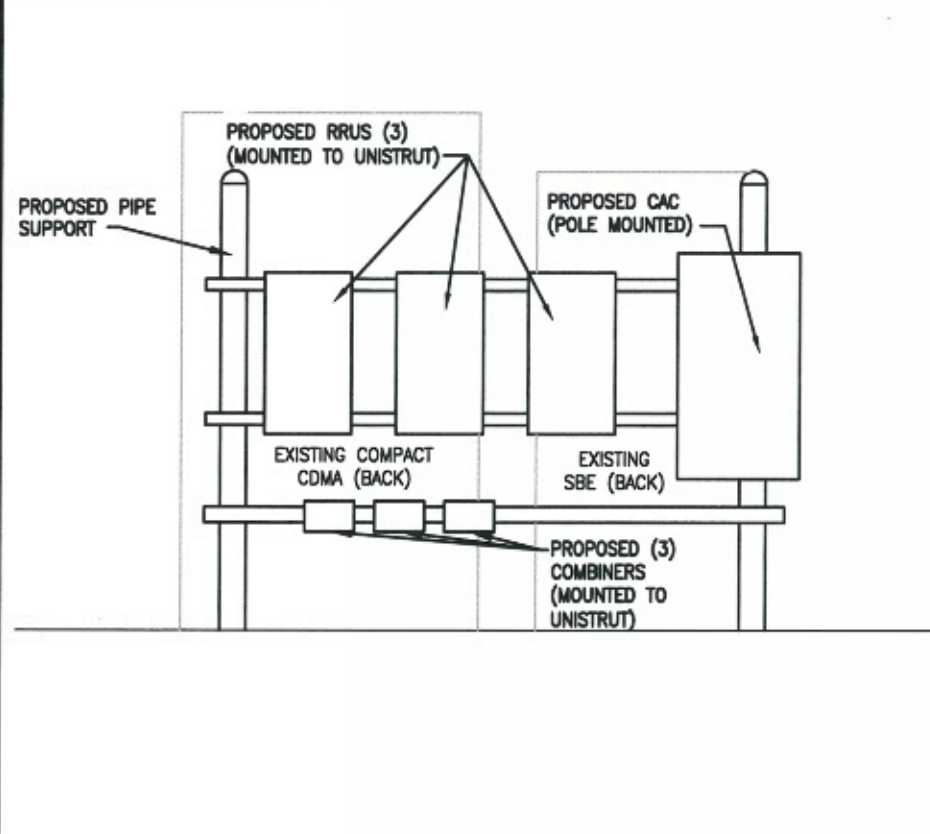

B EQUIPMENT ELEVATION
SCALE: N.T.S.

PLANS PREPARED FOR:

US Cellular
We connect with you
10 Corporate Drive, Suite 210, Bedford, NH 03110

PROJECT INFORMATION

853488 - OAKDALE
246 DEERING AVE
PORTLAND, ME 04101
(CUMBERLAND COUNTY)

PLANS PREPARED BY:

amec
511 Congress Street Suite 200, Portland ME 04101
P: (207) 775-5401 F: (207) 772-4782 www.amec.com

PROJECT COORDINATION & MANAGEMENT:

KJK Wireless, LLC
127 Ridge Road, Nashua, NH 03062
Phone: (603) 888-8974

SEAL

STATE OF MAINE
MICHAEL S. DELETETSKY
No. 5023
LICENSED PROFESSIONAL ENGINEER

| REV | DATE | ISSUED FOR |
|-----|---------|-------------------------|
| 1 | 5/23/13 | ISSUED FOR CONSTRUCTION |


PROJECT NO: 3618138235

DRAWN BY: EJG

RELEASED BY: MSD


SHEET TITLE
**EQUIPMENT LAYOUT
PLAN AND ELEVATIONS**

| SHEET NUMBER | REVISION: |
|--------------|-----------|
| C1 | 0 |

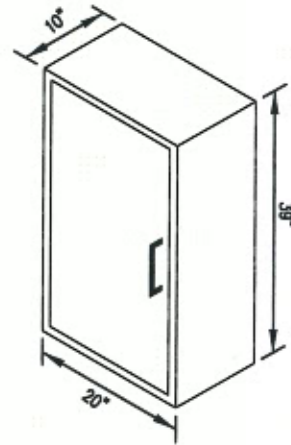


TYPICAL CAC-A32214090 DETAIL

SCALE: N.T.S.

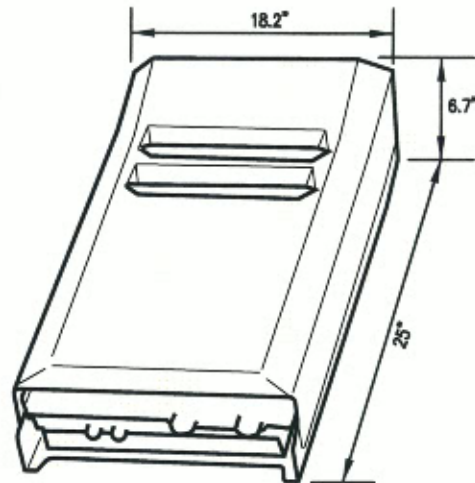

TYPICAL RRUS DETAIL

SCALE: N.T.S.

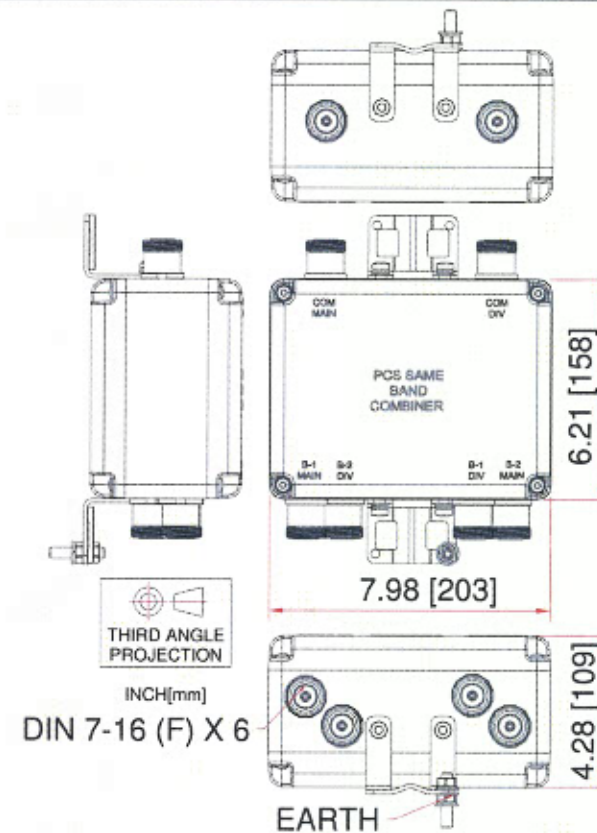

TYPICAL DBC0081FVX-1 COMBINER DETAIL

SCALE: N.T.S.

PLANS PREPARED FOR:



PROJECT INFORMATION

853488 - OAKDALE
246 DEERING AVE
PORTLAND, ME 04101
(CUMBERLAND COUNTY)

PLANS PREPARED BY:



511 Congress Street Suite 200, Portland ME 04101
P: (207) 775-5401 F: (207) 772-4762 www.amec.com

PROJECT COORDINATION & MANAGEMENT:

KJK Wireless, LLC
127 Ridge Road, Nashua, NH 03062
Phone: (603) 888-8974

SEAL



| REV | DATE | ISSUED FOR |
|-----|---------|-------------------------|
| △ | 5/23/13 | ISSUED FOR CONSTRUCTION |

PROJECT NO: 3618138235


DRAWN BY: CBM

RELEASED BY: MSD

SHEET TITLE
**PROPOSED
EQUIPMENT DETAILS**

| SHEET NUMBER | REVISION: |
|--------------|-----------|
| C-2 | 0 |

RF Coaxial Cable & Combiner Configuration

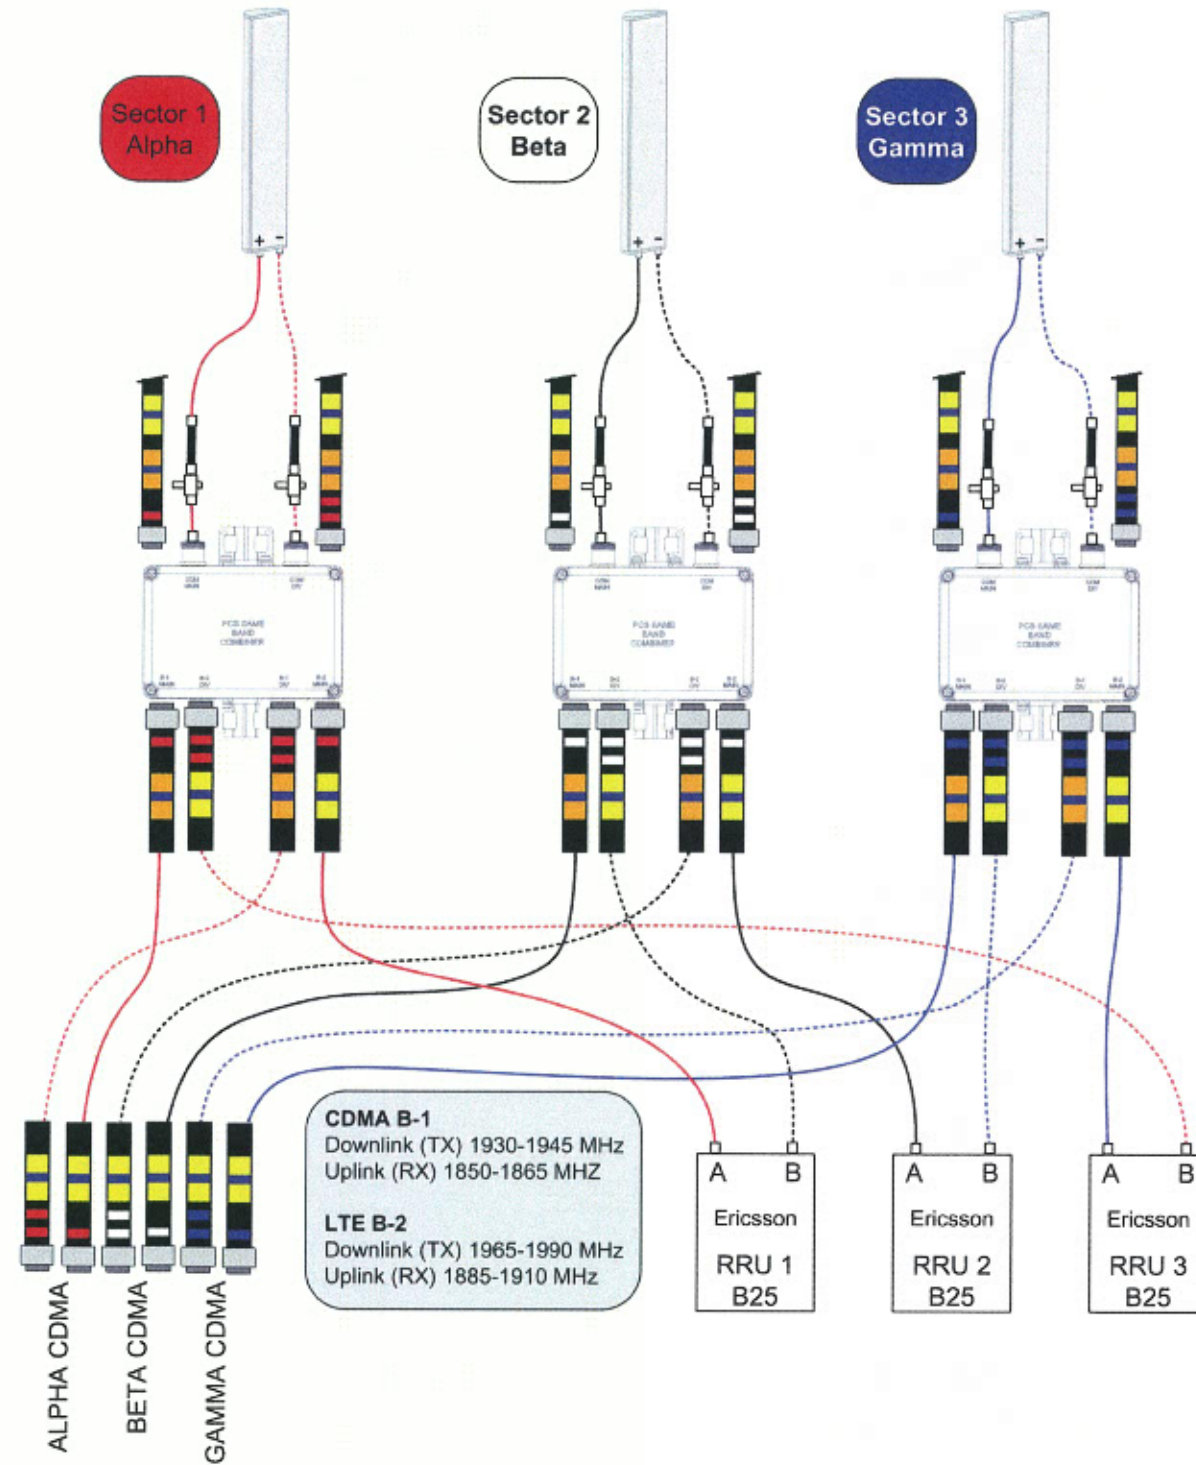

ONE-LINE DIAGRAM
SCALE: N.T.S.


PLANS PREPARED FOR:
 **US Cellular**
 We connect with you
 10 Corporate Drive, Suite 210, Bedford, NH 03110

PROJECT INFORMATION
853488 - OAKDALE
 246 DEERING AVE
 PORTLAND, ME 04101
 (CUMBERLAND COUNTY)

PLANS PREPARED BY:

 343 Gorham Road, South Portland ME 04106
 P: (207) 761-1770 F: (207) 774-1246 www.amec.com

PROJECT COORDINATION & MANAGEMENT:
KJK Wireless, LLC
 127 Ridge Road, Nashua, NH 03062
 Phone: (603) 888-8974

SEAL

 MICHAEL S. DELETETSKY
 No. 6023
 LICENSED PROFESSIONAL ENGINEER
 23 May 2013

| REV | DATE | ISSUED FOR |
|-----|---------|-------------------------|
| 1 | 5/23/13 | ISSUED FOR CONSTRUCTION |

PROJECT NO: 3618138235

DRAWN BY: CBM

RELEASED BY: MSD

SHEET TITLE
ONE-LINE DIAGRAM

| | |
|----------------------------|-----------------------|
| SHEET NUMBER E-1 | REVISION: 0 |
|----------------------------|-----------------------|