

**PROJECT INFORMATION**

SCOPE OF WORK: TELECOMMUNICATIONS FACILITY UPGRADE (LTE-3C 2015):  
 ROOFTOP:  
 REMOVE: (3) LTE ANTENNAS AND (3) GSM/UMTS ANTENNAS  
 INSTALL: (9) NEW LTE 3C ANTENNAS, (9) RRH'S, (3) LTE A2  
 (3) SURGE ARRESTOR, (2) DC POWER LINES AND (1) FIBER RUN  
 EXISTING TO REMAIN: (12) LINES OF COAX, (2) DC POWER LINES, (1) FIBER RUN,  
 (3) SURGE ARRESTORS, (6) TMA'S & (6) DIPLEXERS  
 EQUIPMENT PAD: INSTALL: (1) PURCELL CABINET AND (2) LTE DUS

BUILDING OWNER: UNIVERSITY OF MAINE SYSTEM.  
 107 MAINE AVE.  
 BANGOR, ME 04401

SITE ADDRESS: 246 DEERING AVENUE  
 PORTLAND, ME 04102

LATITUDE: 43.66099 N 43° 39' 39.6" N  
 LONGITUDE: 70.27911 W 70° 16' 44.8" W

TYPE OF SITE: ROOFTOP / OUTDOOR EQUIPMENT  
 OVERALL

ROOF HEIGHT: 84'-8"±  
 RAD CENTER: 92'-5"± ALPHA SECTOR & 88'-3" BETA & GAMMA SECTOR



**SITE NUMBER: ME5045**  
**SITE NAME: PORTLAND USM**  
**PROJECT: LTE 3C 2015 UPGRADE**


**DRAWING INDEX**

**REV**

- T-1 TITLE SHEET
- GN-1 GENERAL NOTES
- A-1 ROOF & EQUIPMENT PLAN
- A-2 ELEVATION
- A-3 ANTENNA LAYOUT
- A-4 DETAILS
- A-5 DETAILS
- RF-1 RF PLUMBING DIAGRAM
- E-1 ELECTRICAL ONE-LINE DIAGRAM
- G-1 GROUNDING DETAILS

- 0
- 0
**VICINITY MAP**

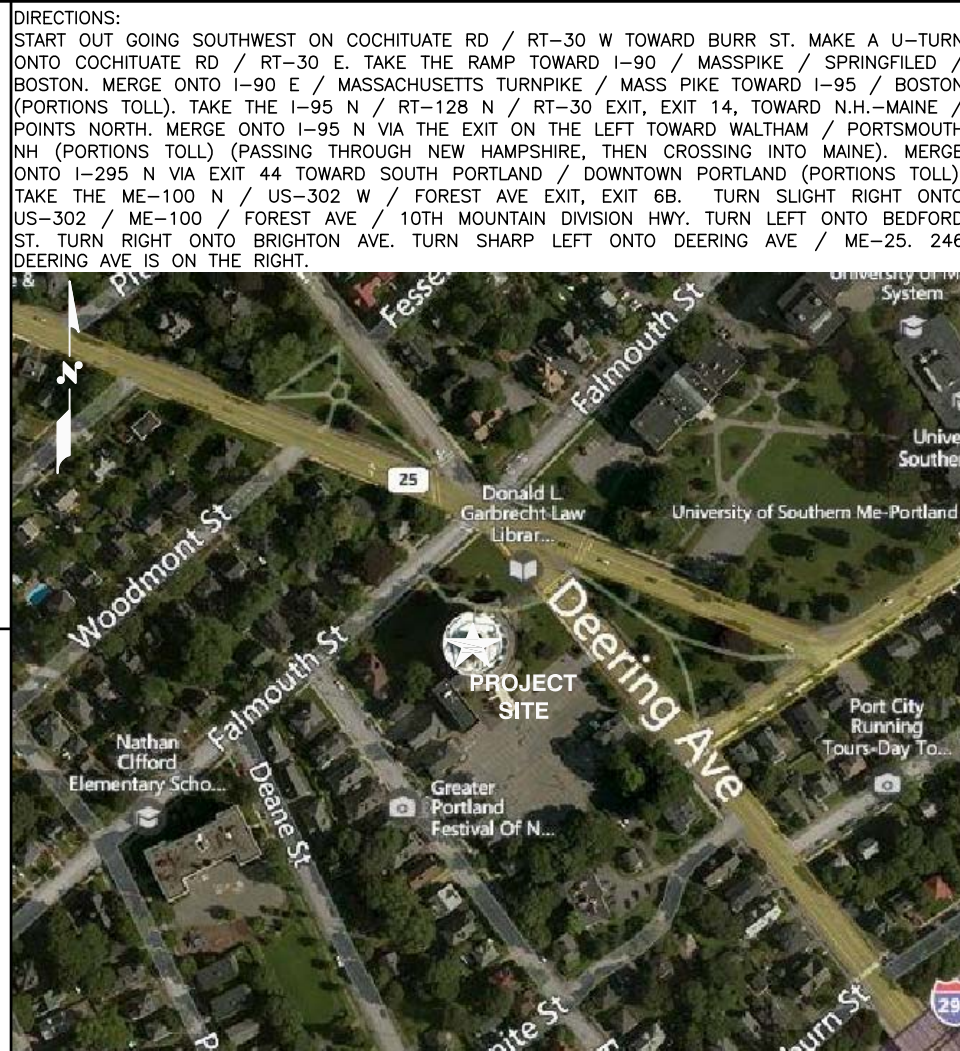

**GENERAL NOTES**

1. THIS DOCUMENT IS THE CREATION, DESIGN, PROPERTY AND COPYRIGHTED WORK OF AT&T. ANY DUPLICATION OR USE WITHOUT EXPRESS WRITTEN CONSENT IS STRICTLY PROHIBITED. DUPLICATION AND USE BY GOVERNMENT AGENCIES FOR THE PURPOSES OF CONDUCTING THEIR LAWFULLY AUTHORIZED REGULATORY AND ADMINISTRATIVE FUNCTIONS IS SPECIFICALLY ALLOWED.
2. THE FACILITY IS AN UNMANNED PRIVATE AND SECURED EQUIPMENT INSTALLATION. IT IS ONLY ACCESSED BY TRAINED TECHNICIANS FOR PERIODIC ROUTINE MAINTENANCE AND THEREFORE DOES NOT REQUIRE ANY WATER OR SANITARY SEWER SERVICE. THE FACILITY IS NOT GOVERNED BY REGULATIONS REQUIRING PUBLIC ACCESS PER ADA REQUIREMENTS.
3. CONTRACTOR SHALL VERIFY ALL PLANS AND EXISTING DIMENSIONS AND CONDITIONS ON THE JOB SITE AND SHALL IMMEDIATELY NOTIFY THE AT&T REPRESENTATIVE IN WRITING OF DISCREPANCIES BEFORE PROCEEDING WITH THE WORK OR BE RESPONSIBLE FOR SAME.

72 HOURS



BEFORE YOU DIG



CALL TOLL FREE 888-DIG-SAFE OR DIAL 811

**UNDERGROUND SERVICE ALERT**

**Hudson Design Group, Inc.**  
 1600 OSGOOD STREET  
 BUILDING 20 NORTH, SUITE 3090  
 N. ANDOVER, MA 01845  
 TEL: (978) 557-5553  
 FAX: (978) 336-5586

**EMPIRE telecom**  
 16 ESQUIRE ROAD  
 BILLERICA, MA 01862  
 TEL: (978) 608-8400

**SITE NUMBER: ME5045**  
**SITE NAME: PORTLAND USM**  
 246 DEERING AVENUE  
 PORTLAND, ME 04102  
 CUMBERLAND COUNTY

**at&t**  
 550 COCHITUATE ROAD  
 FRAMINGHAM, MA 01701

NO.	DATE	REVISIONS	BY	CHK	APP'D
0	12/12/14	ISSUED FOR REVIEW	MR	HC	DC
SCALE: AS SHOWN		DESIGNED BY: HC	DRAWN BY: MR		

AT&T		
TITLE SHEET (LTE-3C 2015)		
JOB NUMBER	DRAWING NUMBER	REV
5045.00	T-1	0