


ALARM TERMINAL CABINET "TC" WIRING DETAIL

SCALE: N.T.S.

ALARM TERMINAL NOTES:

1. TERMINAL STRIP SHALL BE SQUARE 'D' 9080GP620 WITH MOUNTING CHANNELS. EACH STRIP SHALL BE 20 CONTACT BLOCK TYPE.
2. MINIMUM #14 THW CONDUCTOR SIZE FOR ALARM WIRING.
3. MOUNT TERMINAL STRIP INTO 12"x12"x6" NEMA 1 HINGED DOOR ENCLOSURE McNISTRY #30-12126LP WITH BACK PANEL.
4. ALARM CONTACTS SHALL BE OPEN ON ALARM.

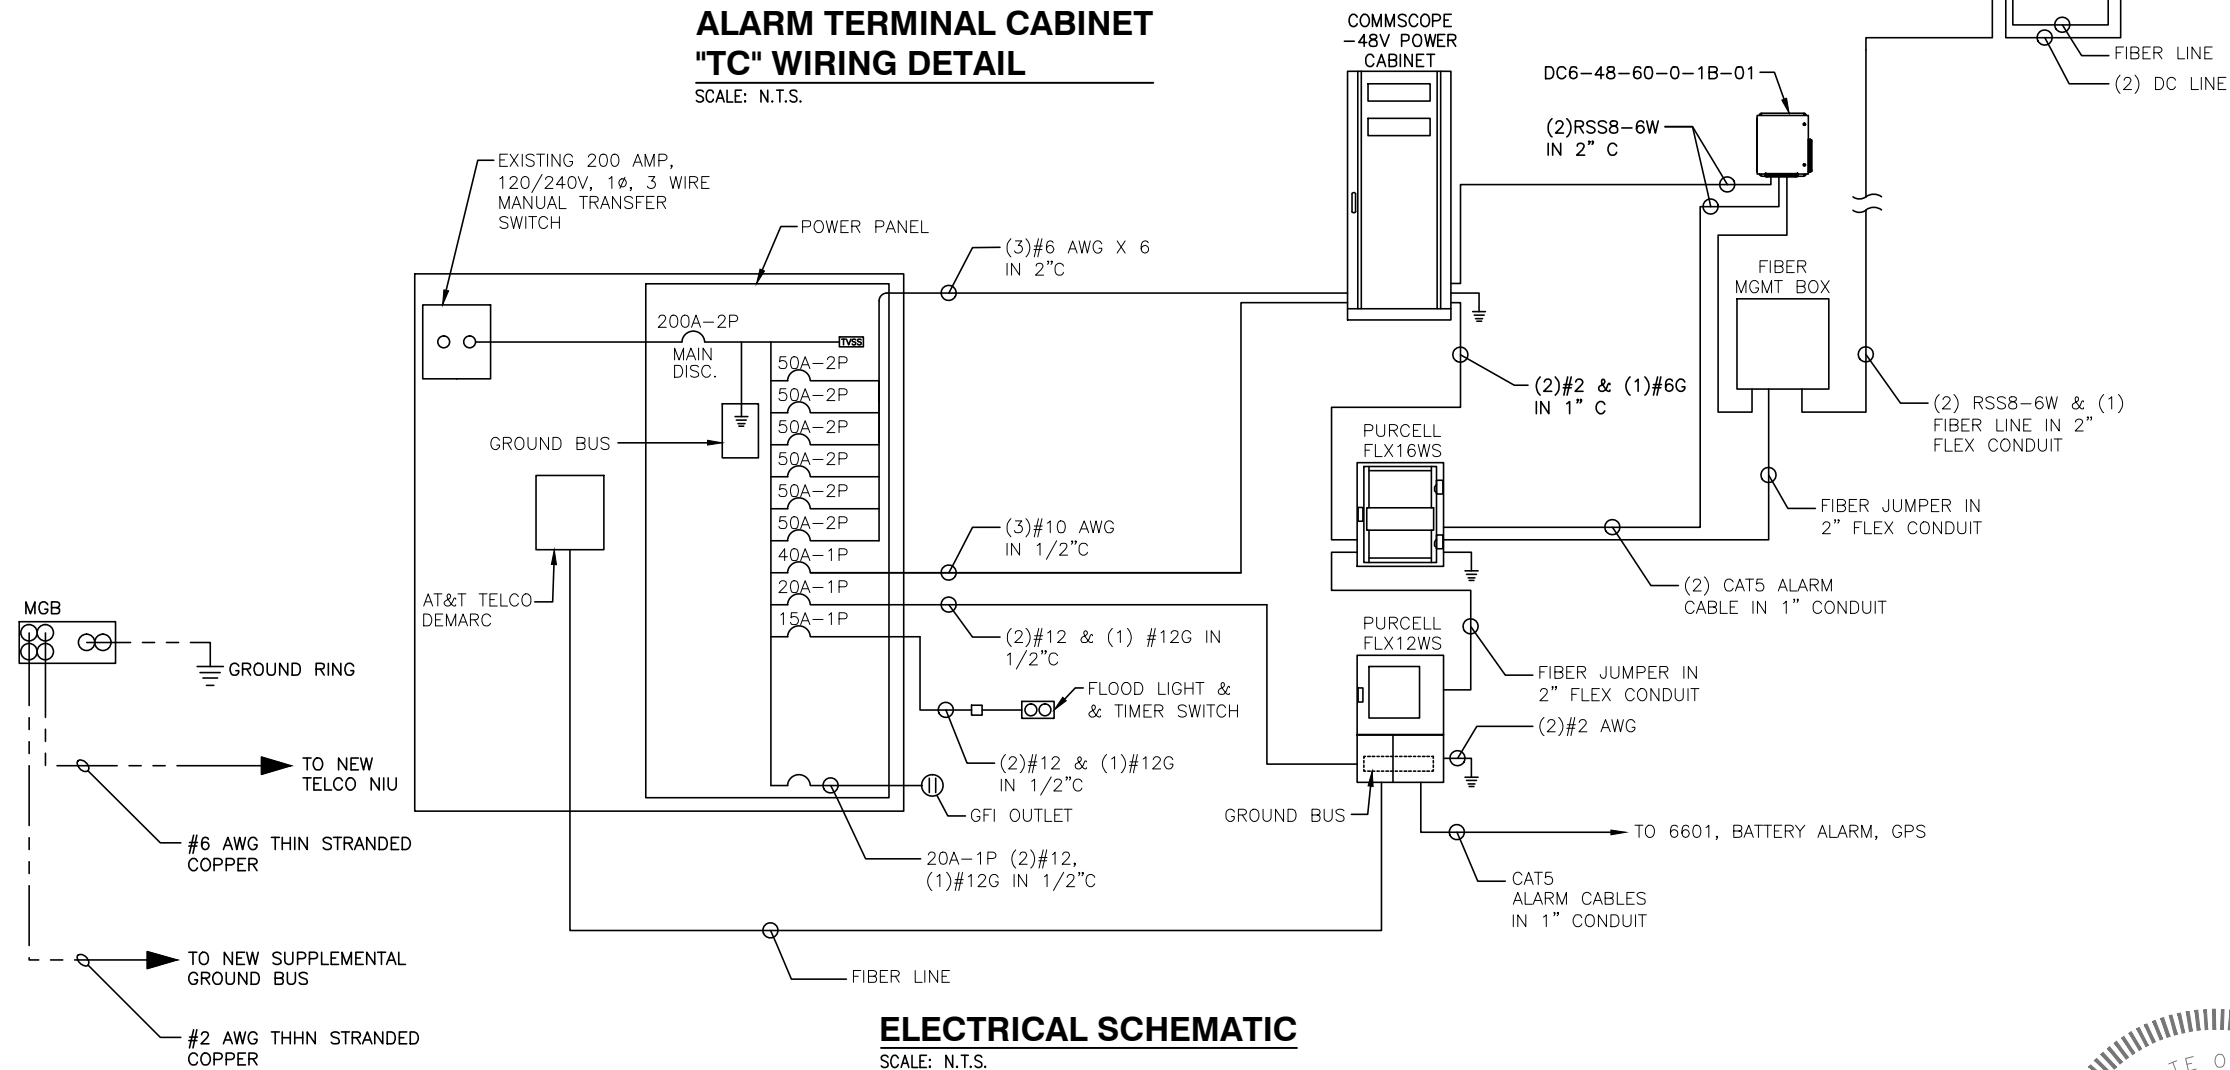

ELECTRICAL SCHEMATIC

SCALE: N.T.S.



1600 OSGOOD STREET
BUILDING 20 NORTH, SUITE 3090
N. ANDOVER, MA 01845
TEL: (978) 557-5553
FAX: (978) 336-5586

EMPIRE telecom
16 ESQUIRE ROAD
BILLERICA, MA 01862
TEL: (978) 608-8400


SITE NUMBER: ME5045
SITE NAME: PORTLAND USM

246 DEERING AVENUE
PORTLAND, ME 04102
CUMBERLAND COUNTY



550 COCHITUATE ROAD
FRAMINGHAM, MA 01701

NO.	DATE	REVISIONS	BY	CHK	APP
1	07/16/15	ISSUED FOR PERMITTING	HC	HC	DC
0	12/12/14	ISSUED FOR REVIEW	MR	HC	DC
NO.		REVISIONS		BY	
SCALE: AS SHOWN		DESIGNED BY: HC		DRAWN BY: MR	

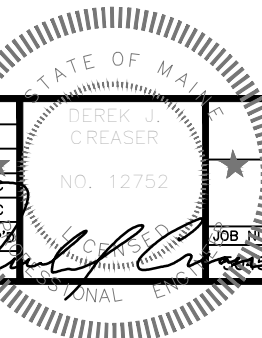

AT&T	
ELECTRICAL ONE-LINE DIAGRAM (LTE-3C 2015)	
JOB NUMBER	DRAWING NUMBER
15-01	E-1
REV	1