



2-25-2005 A 1 1/8" = 1'-0" 1 2 3 4 5 6 7 8 9 10


A1 MECHANICAL PIPING PLAN ~ SECOND FLOOR

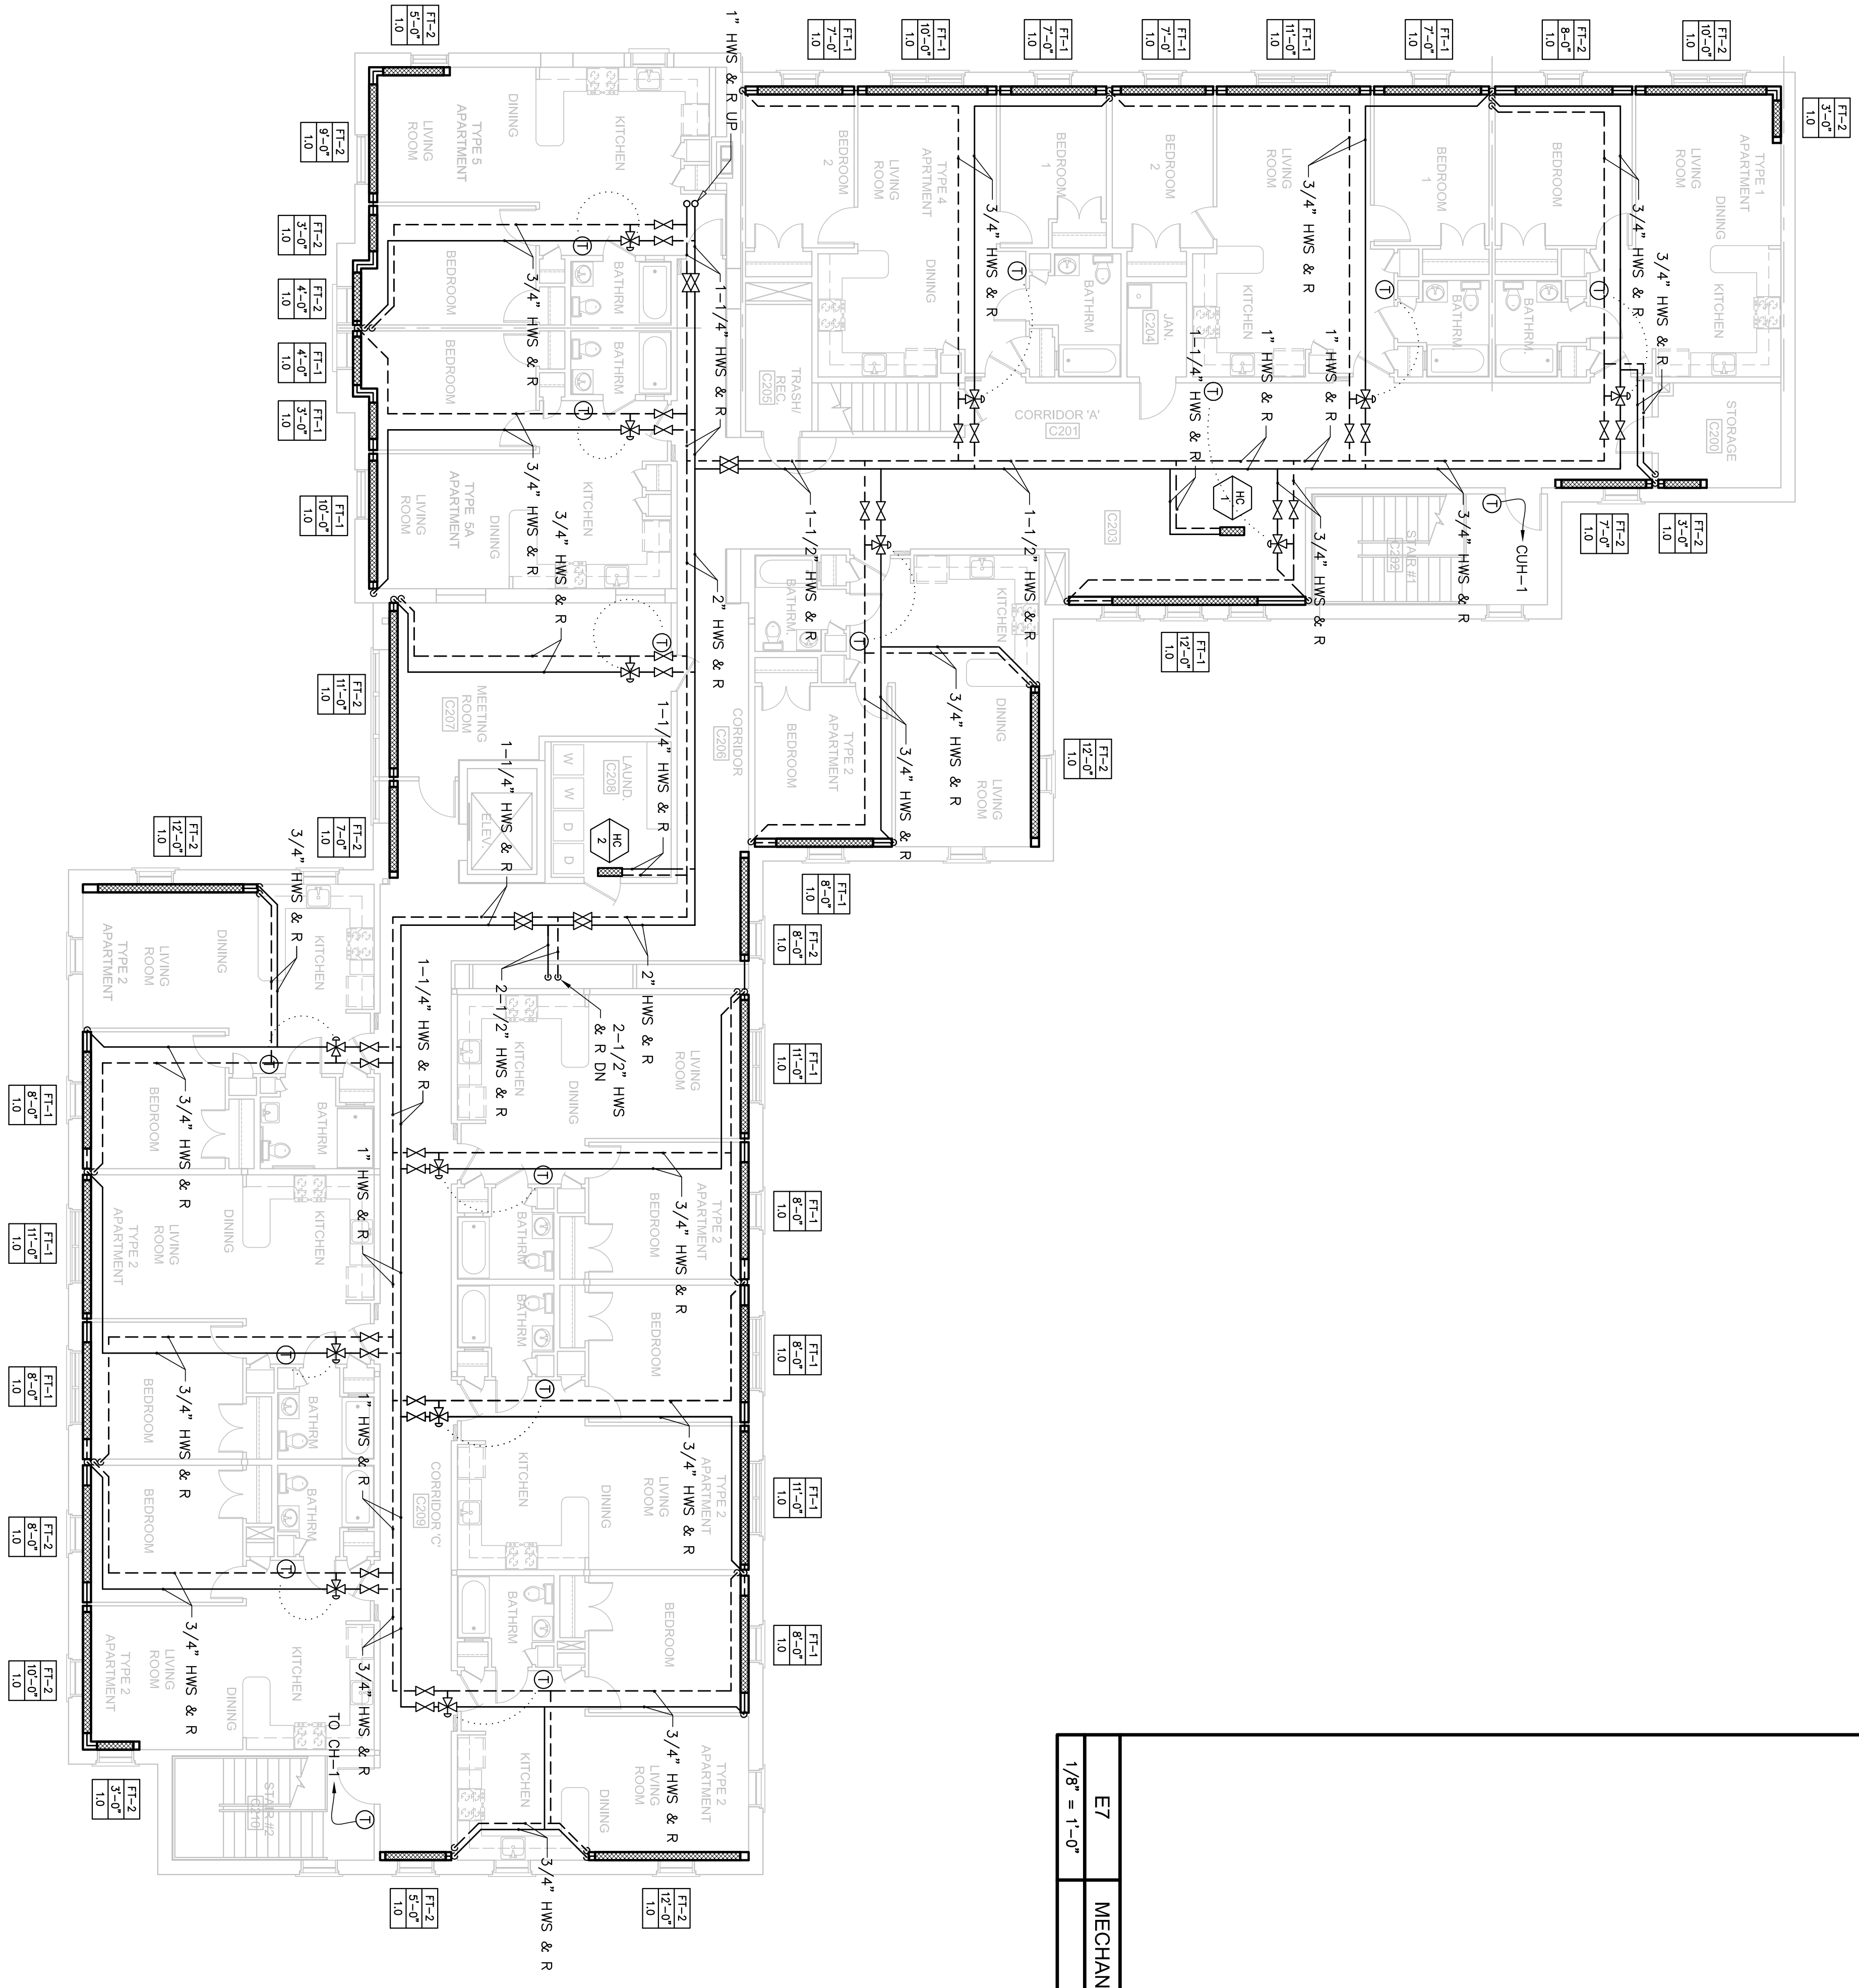

E7 MECHANICAL PIPING PLAN ~ THIRD FLOOR

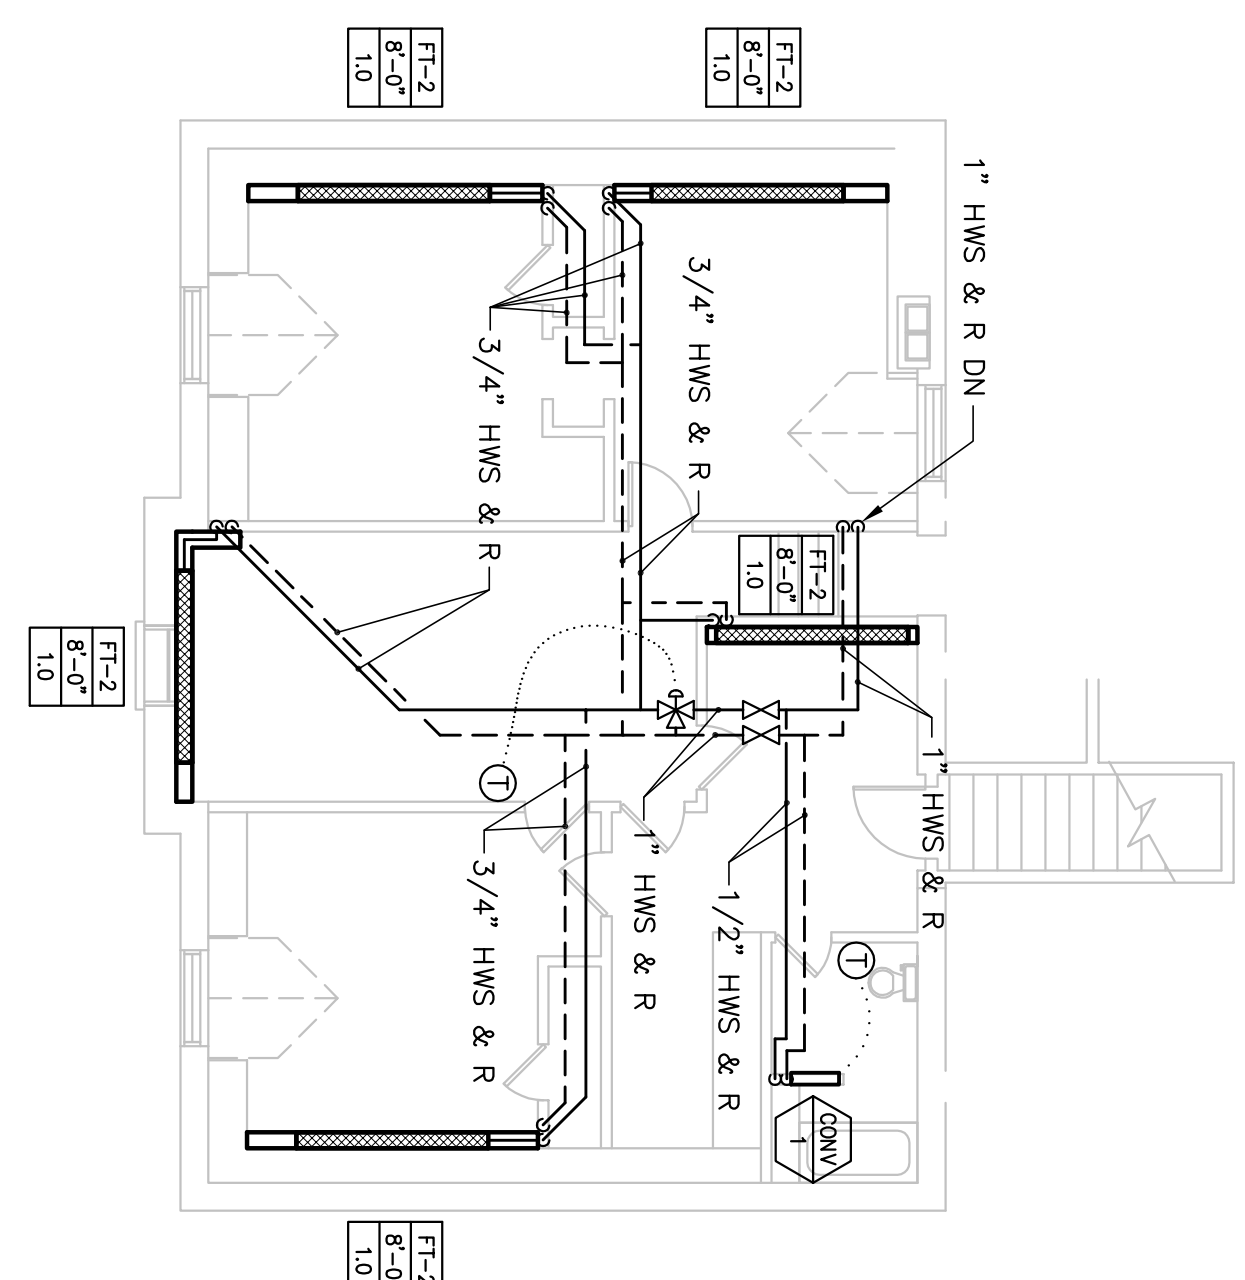

95% REVIEW
25 FEB 2005

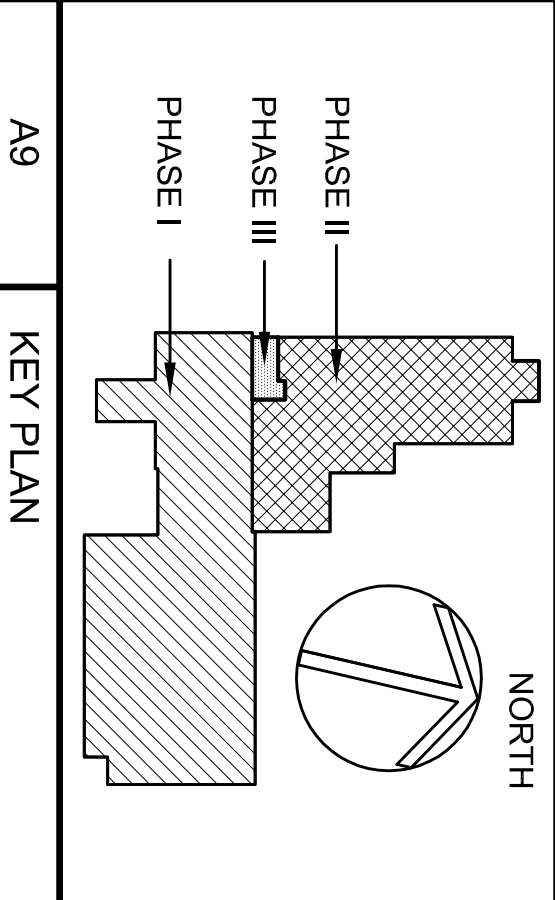

SHEET: MP-102	DRAWING: MECHANICAL PIPING PLAN ~ 2nd & 3rd FLOOR	PROJECT: IRIS PARK APARTMENTS RENOVATION & ADDITIONS PORTLAND, MAINE 04101	OWNER: IRIS NETWORK PORTLAND, MAINE 04101	ENGINEERING: allied engineering, inc. <small>Telephone No: 207-654-8120 • Fax No: 207-654-0803 EMail: info@alliedeng.com • www.alliedeng.com</small>	ARCHITECT: SEMPLE & DRANE ARCHITECTS 496 CONGRESS STREET PORTLAND, MAINE 04101 TEL: (207) 761-4231 FAX: 774-0152 sda@sempledrane.com
	SCALE: AS NOTED CAD FILE: 03066MP.DWG DATE: 2-25-05				