


September 04, 2014 - 2:41 PM
\\moss\shared\projects\1425 Ryan Building (RIS)\Drawings\1425 M-M.dwg

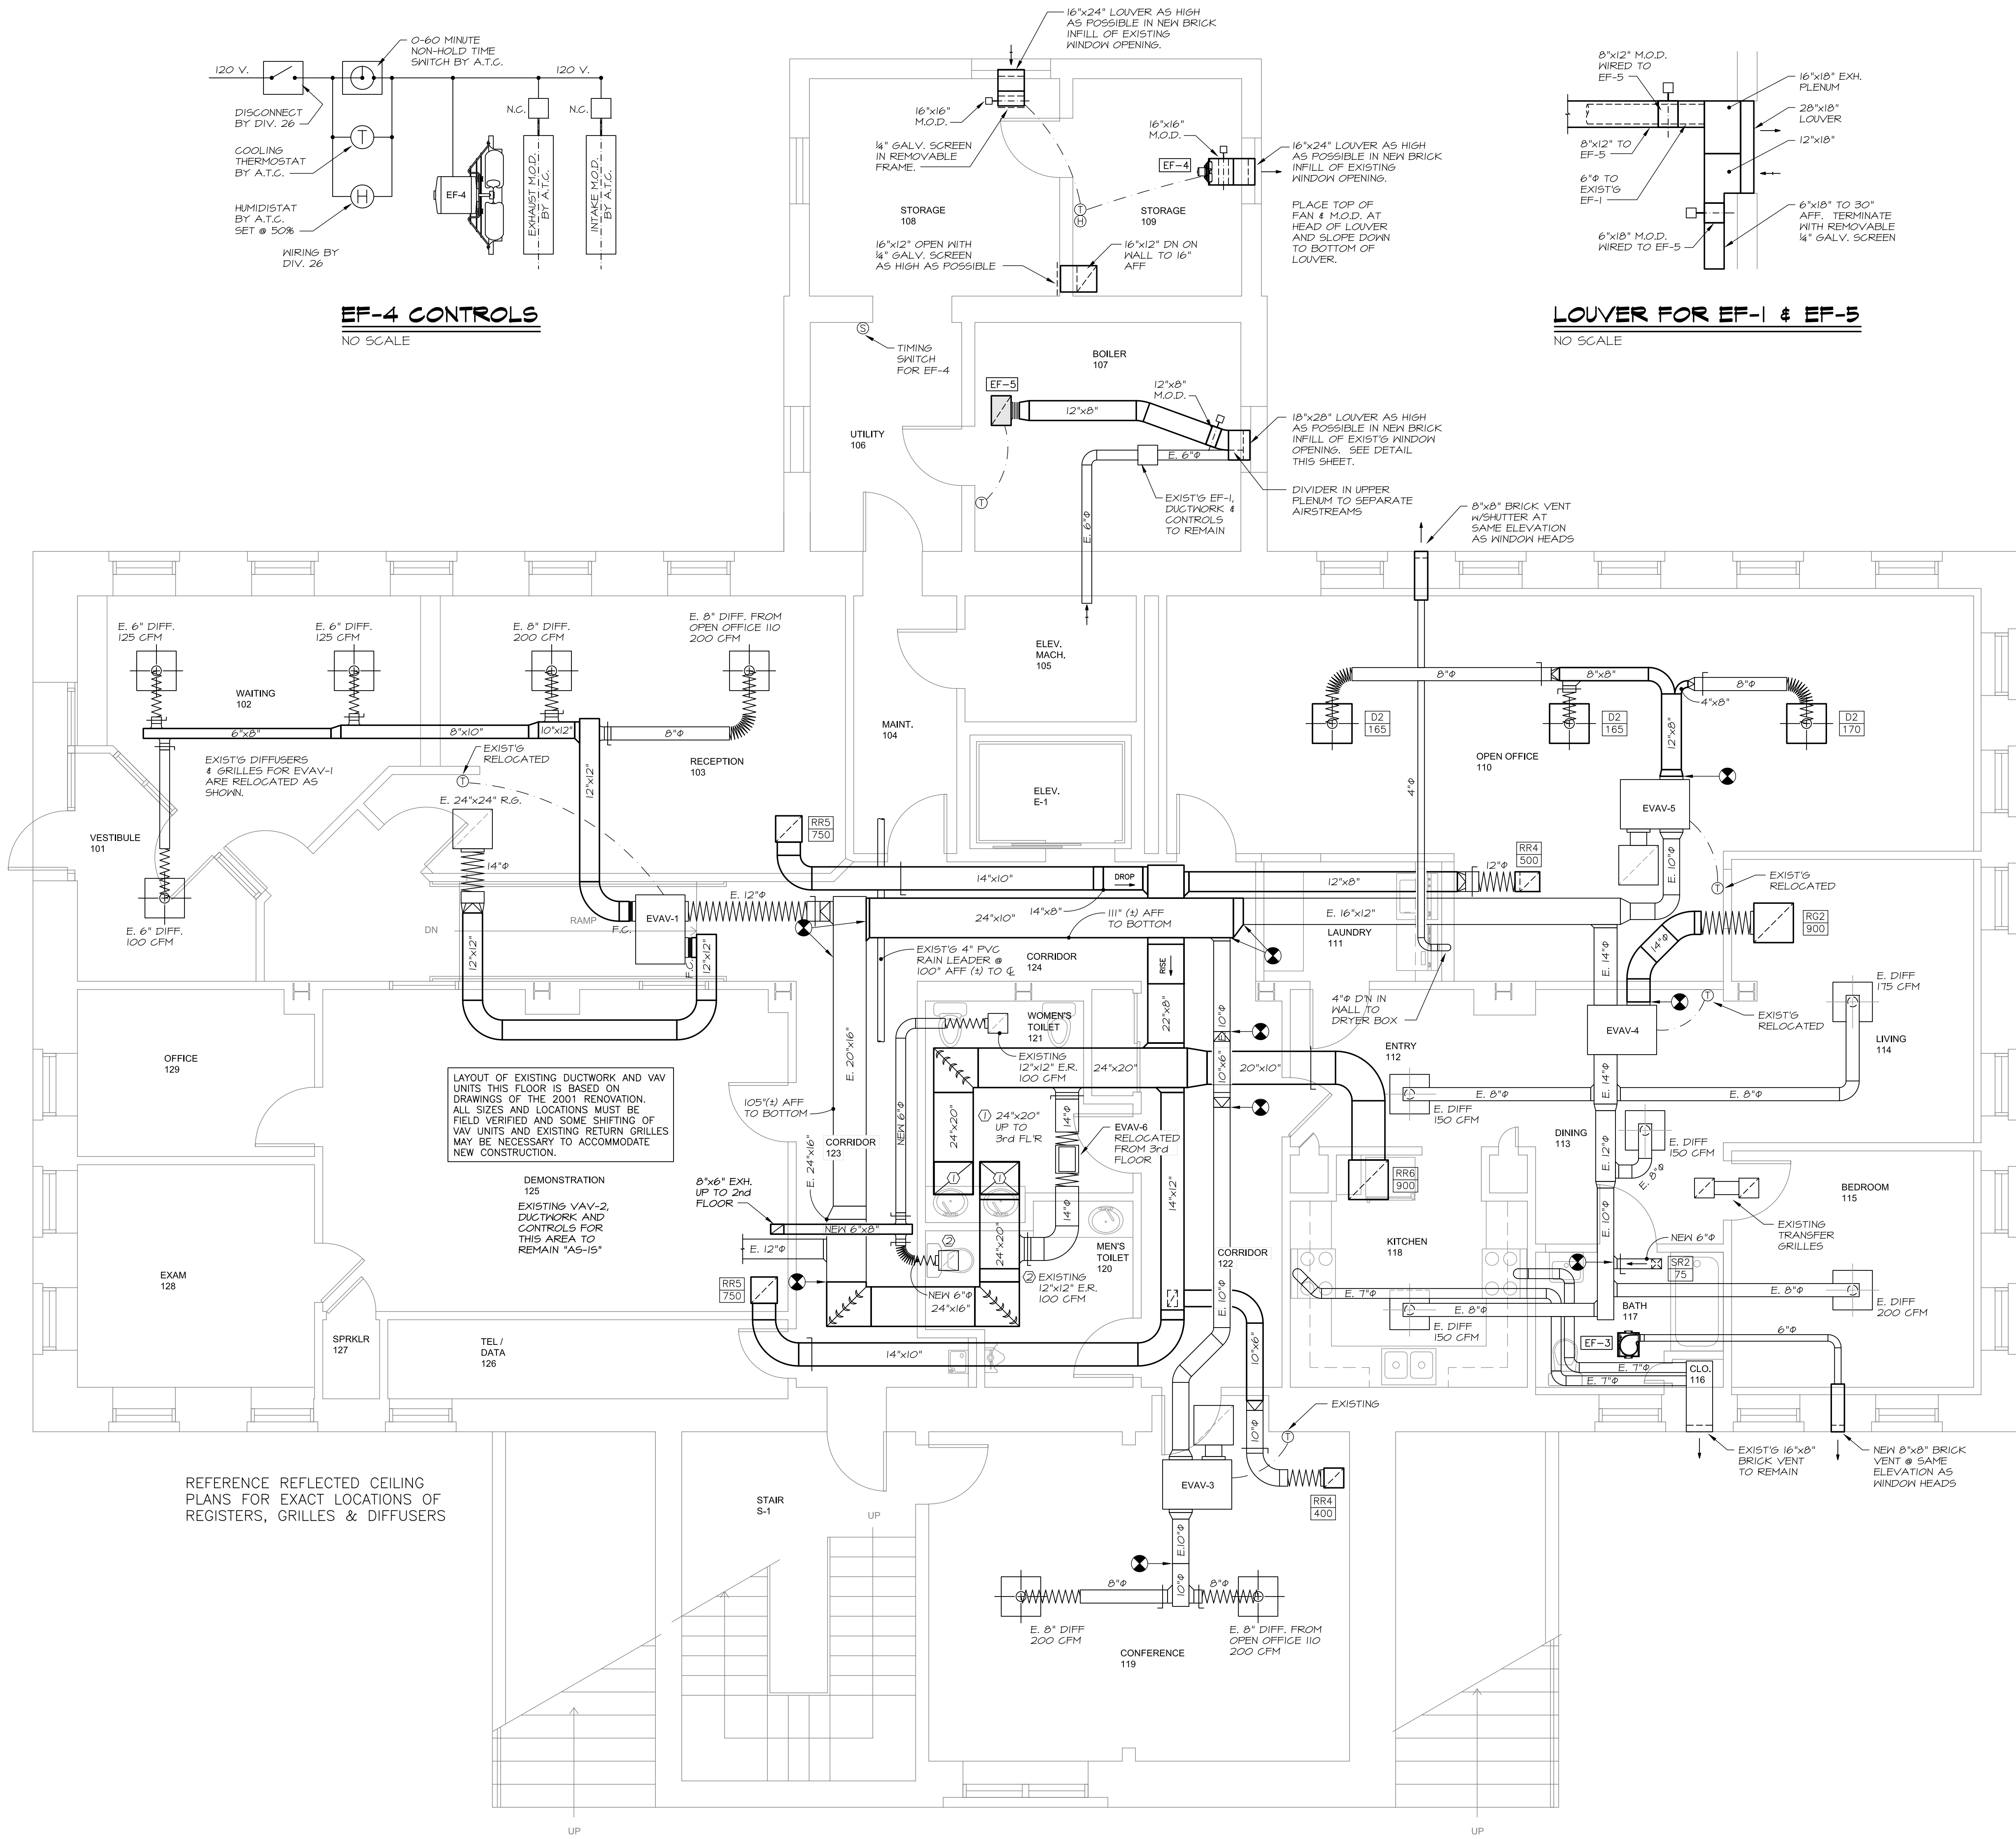

EF-4 CONTROLS
NO SCALE

LOUVER FOR EF-1 & EF-5
NO SCALE


LAYOUT OF EXISTING DUCTWORK AND VAV UNITS THIS FLOOR IS BASED ON DRAWINGS OF THE 2001 RENOVATION. ALL SIZES AND LOCATIONS MUST BE FIELD VERIFIED AND SOME SHIFTING OF VAV UNITS AND EXISTING RETURN GRILLES MAY BE NECESSARY TO ACCOMMODATE NEW CONSTRUCTION.

DEMONSTRATION 105
EXISTING VAV-2, DUCTWORK AND CONTROLS FOR THIS AREA TO REMAIN "AS-IS"


REFERENCE REFLECTED CEILING PLANS FOR EXACT LOCATIONS OF REGISTERS, GRILLES & DIFFUSERS

1/4" = 1'-0"

MECHANICAL SYSTEMS ENGINEERS
ROYAL RIVER CENTER, UNIT #108
10 FOREST FALLS DRIVE
YARMOUTH, MAINE 04096
FACEBOOK: MECHANICAL SYSTEMS ENGINEERS
207-846-1441
© COPYRIGHT 2014

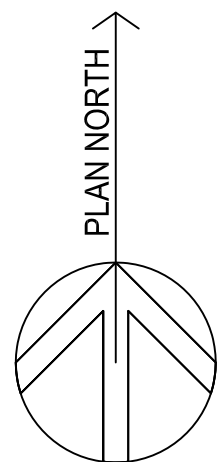

Michael R. Charek
Architects
25 Hartley Street
Portland, Maine 04103
(207) 761-0556

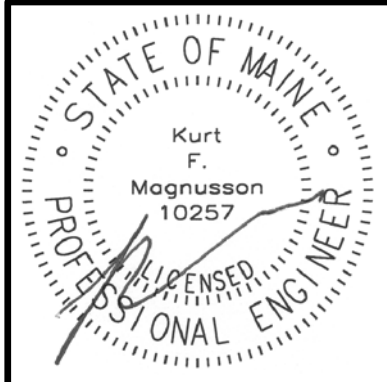

The IRIS Network
Ryan Building Renovations
189 Park Avenue
Portland, Maine 04102

Title
**FIRST FLOOR
MECHANICAL
DWG TITLE LINE 3**

Scale: 1/4" = 1'-0"

Date: 09/08/14

Revisions

Sheet

M1

MSE JOB NO. 1425