

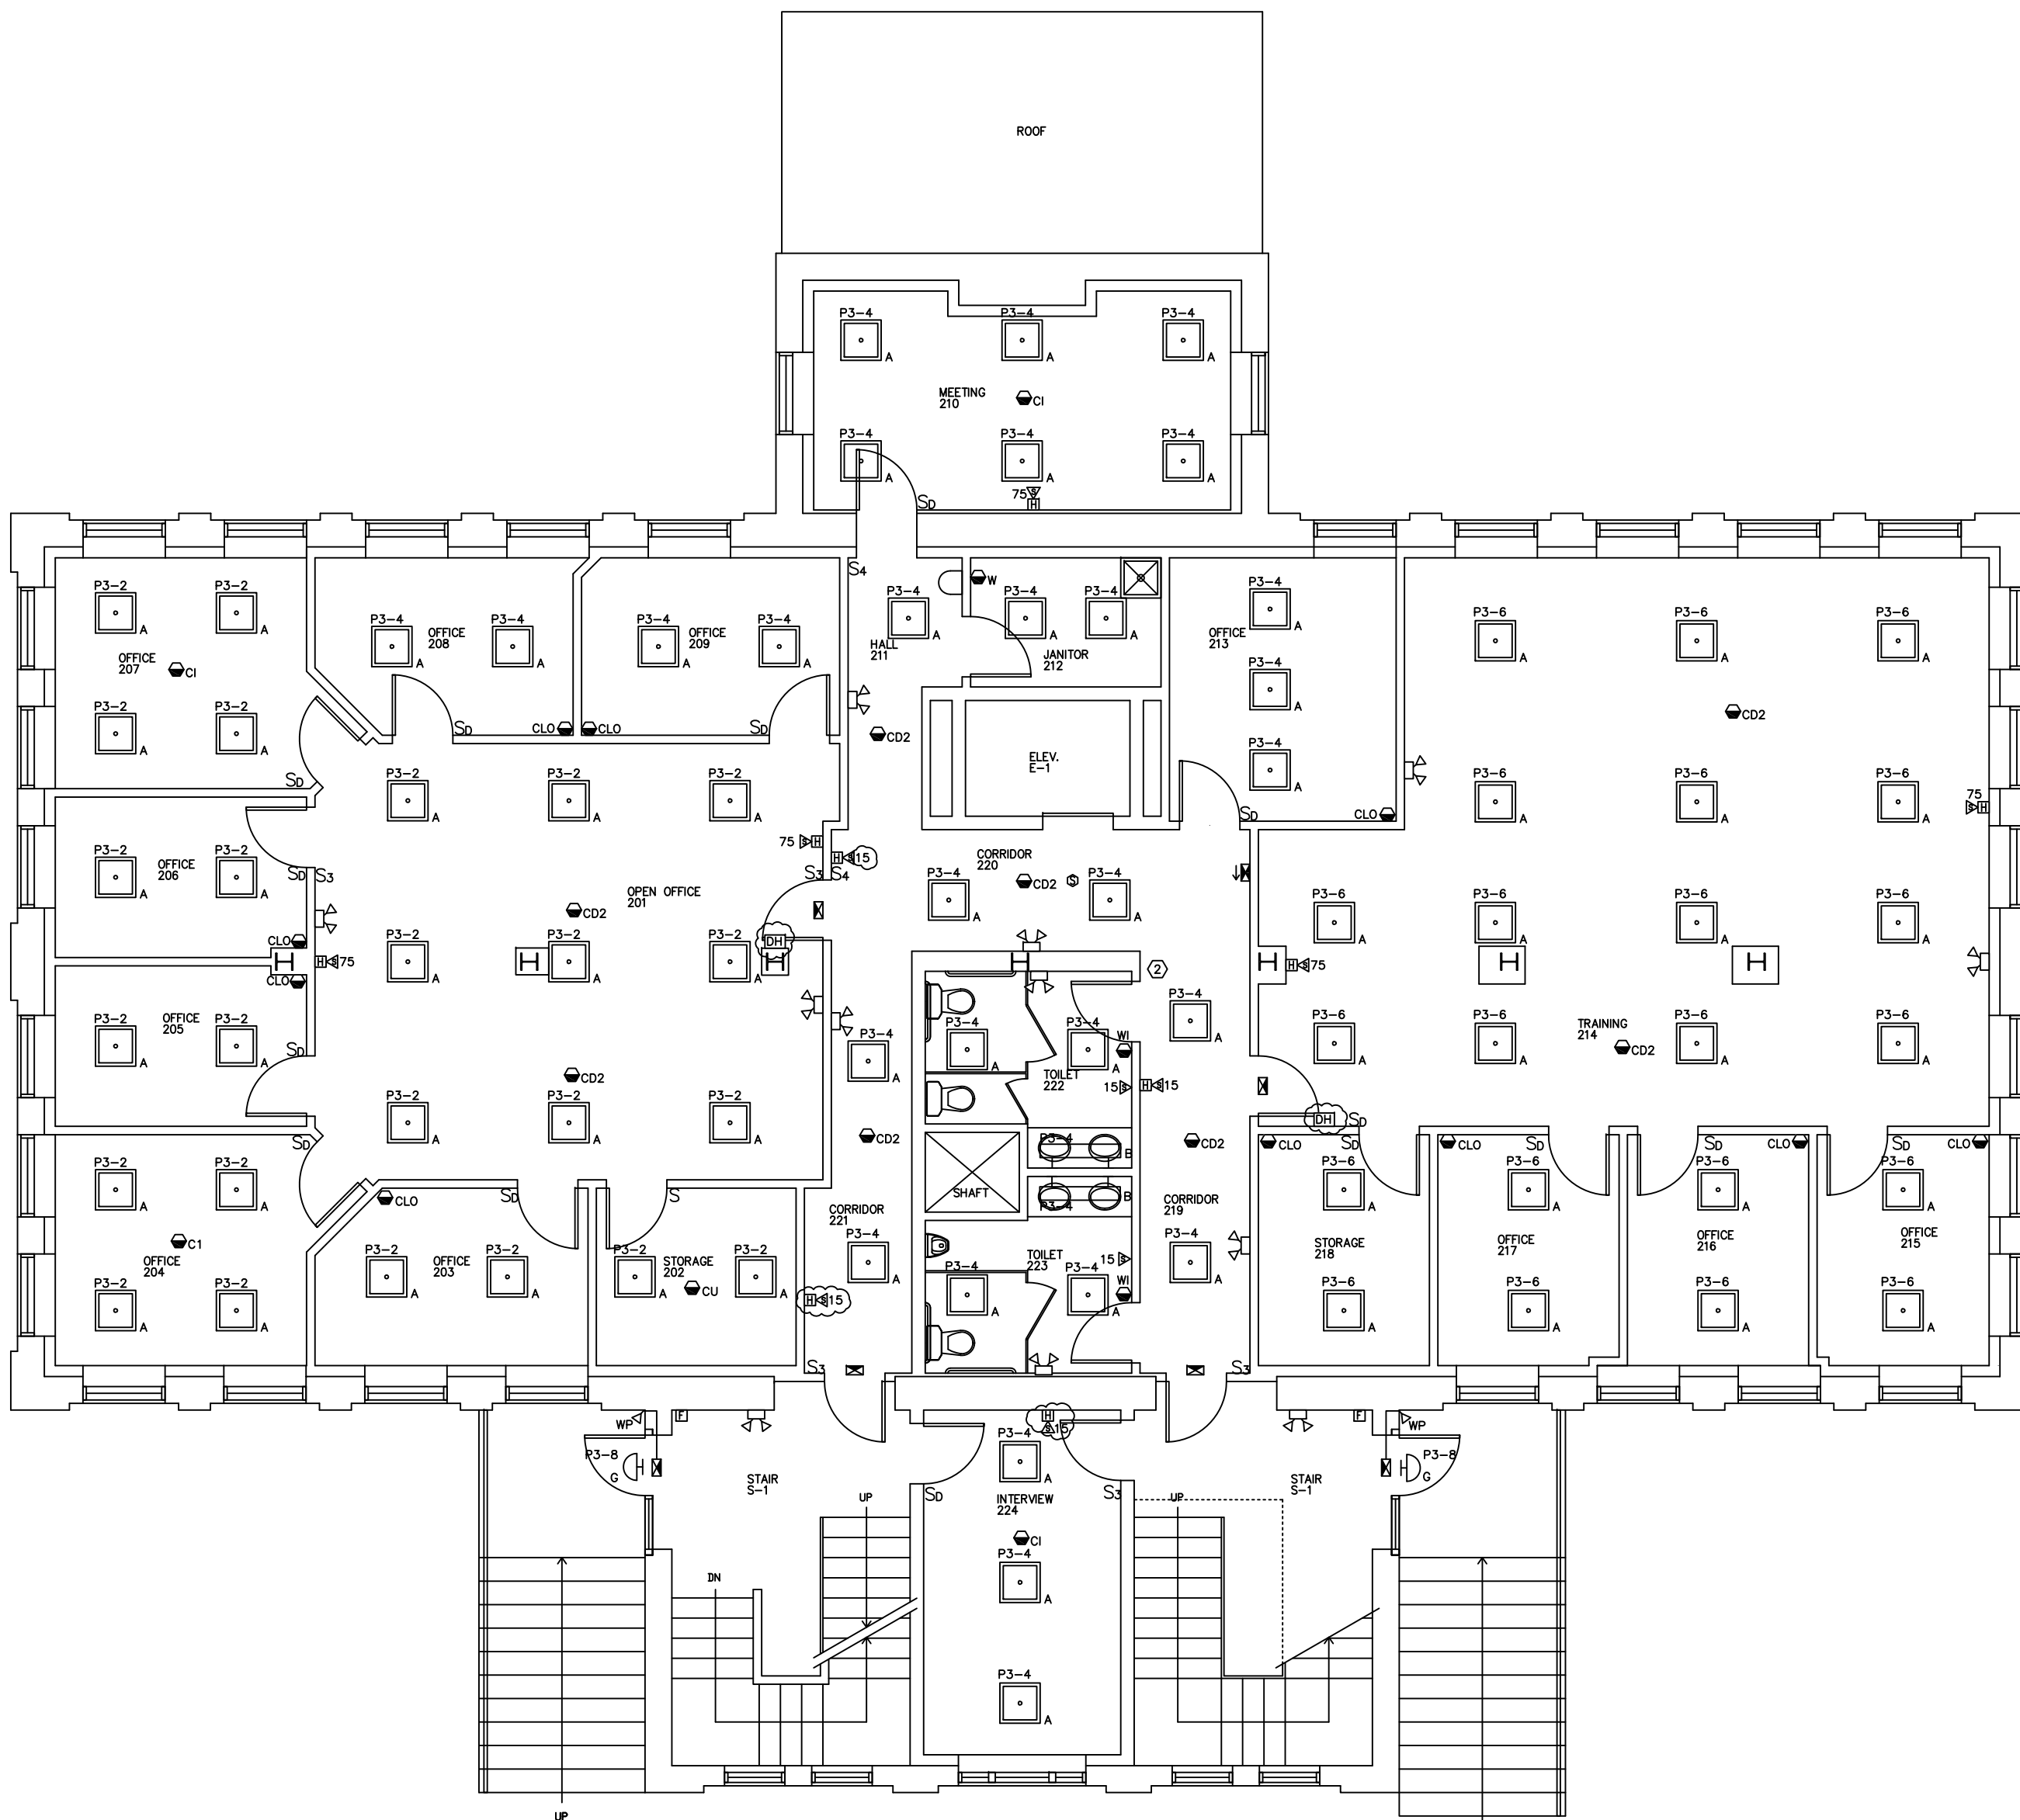


NOTES:
 1. SEE E.O.0 FOR LEGEND, ABBREVIATIONS AND GENERAL NOTES.

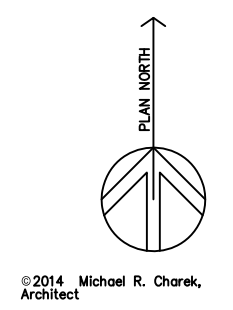

1 SECOND FLOOR ELECTRICAL LIGHTING AND FIRE ALARM PLAN
 SCALE: 1/4"=1'

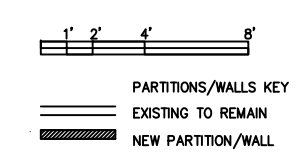

SWIFTCURRENT
 Engineering Services
 10 Forest Falls Dr.
 Unit 4b
 Yarmouth, ME 04096
 Tel: (207) 847-9280

Michael Charek
 Architects
 25 Hartley Street
 Portland, Maine 04103
 (207) 761-0556

The Iris Network
 Ryan Building
 Renovations
 189 Park Avenue
 Portland, ME
 04102

Title	SECOND FLOOR ELECTRICAL POWER AND SYSTEMS PLAN
Drawn By:	JMD
Checked By:	TDM
Scale:	AS NOTED
Date:	9/8/14
Revisions	
REV. B - FIRE ALARM REVISIONS	11/20/14
REV. A - LIGHT SWITCHES	10/3/14

ISSUED FOR CONSTRUCTION
 Sheet
 E2.1