




- GENERAL NOTES:**
- DO NOT SCALE THE DRAWINGS.
  - FIELD VERIFY ALL DIMENSIONS AND LOCATIONS PRIOR TO PROCEEDING WITH WORK. NOTIFY ARCHITECT IN WRITING OF ANY DISCREPANCIES OR INCONSIDERABLE FAILURE TO REPORT ANY DISCREPANCIES WITHIN THESE CONSTRUCTION DOCUMENTS. THE ARCHITECT'S WORK SHALL NOT BE GROUNDED FOR ADDITIONAL COST OR CHANGE ORDERS.
  - "PROVIDE" MEANS "FURNISH AND INSTALL."
  - THE CONTRACTOR SHALL BE RESPONSIBLE FOR PROVIDING ALL MATERIALS AND LABOR NECESSARY TO COMPLY WITH FEDERAL, STATE, CITY, AND LOCAL BUILDING CODES AND THEIR REQUIREMENTS.
  - THE CONTRACTOR AND ALL TRADES SHALL NOTE REQUIREMENTS OF "GENERAL NOTES" ON ALL SHEETS.
  - REFER TO LARGE SCALE PLANS FOR PARTITION TYPES AND DIMENSIONS IN AREAS WHICH ARE DETAILED AT A LARGER SCALE.
  - EACH TRADE TO PROVIDE SMOKE OR FIRE SEALANT AT PENETRATIONS AS SHOWN. ALL SEALANT SHALL BE UL RATED. FIRE STOPPING AND SMOKE STOPPING ASSEMBLIES SHALL BE UL RATED.
  - DIMENSIONS ARE FACE OF CONCRETE, FACE OF MASONRY, AND CENTERLINE OF INTERIOR STUD PARTITIONS. EXTERIOR STUD PARTITIONS ARE DIMENSIONED TO EXTERIOR FACE OF STUD, UNLESS INDICATED OTHERWISE.
  - REFER TO SHEET GRID FOR TYPICAL MOUNTING HEIGHTS OF PLUMBING FIXTURES & MISCELLANEOUS ITEMS.
  - REFER TO ALL CONSTRUCTION DOCUMENTS FOR REQUIREMENTS WHICH MAY AFFECT THE WORK AND COORDINATE SAME.
  - REFERENCE DETAILS AND ENLARGED PLANS FOR ADDITIONAL DIMENSIONAL INFORMATION.
  - DOOR JAMBS SHALL BE LOCATED 6" FROM CORNER IN STUD PARTITIONS AND 8" FROM CORNER IN MASONRY PARTITIONS, UNLESS INDICATED OTHERWISE.
  - REFERENCE STRUCTURAL DRAWINGS FOR LOCATIONS OF FLOOR OPENINGS FOR HANG DUCTS.
  - FLOOR CONSTRUCTION FUNCTIONS AS SMOKE BARRIER. DUCT PARTITIONS WHICH TERMINATE 6 INCHES ABOVE CEILING HEIGHT UNLESS NOTED OTHERWISE. DESIGN/BUILD MECHANICAL AND ELECTRICAL SHALL VERIFY ALL PENETRATIONS THROUGH FLOOR CONSTRUCTION AT FLOOR PENETRATIONS. DUCTS PENETRATING FLOOR ASSEMBLIES SHALL BE PROVIDED WITH SMOKE DAMPERS.

**PARTITION NOTES:**

- PARTITION TYPE DRAWINGS ARE DIAGRAMS ONLY, AND ARE NOT TO SCALE.
- ALL BATT INSULATION IS TO BE CONTINUOUS FULL THICKNESS AND FULL HEIGHT UNLESS NOTED OTHERWISE.
- NON-RATED PARTITIONS FOR DUCT ENCLOSURES TO TERMINATE 6" ABOVE CEILING; COORDINATE WITH TENANT IMPROVEMENTS.

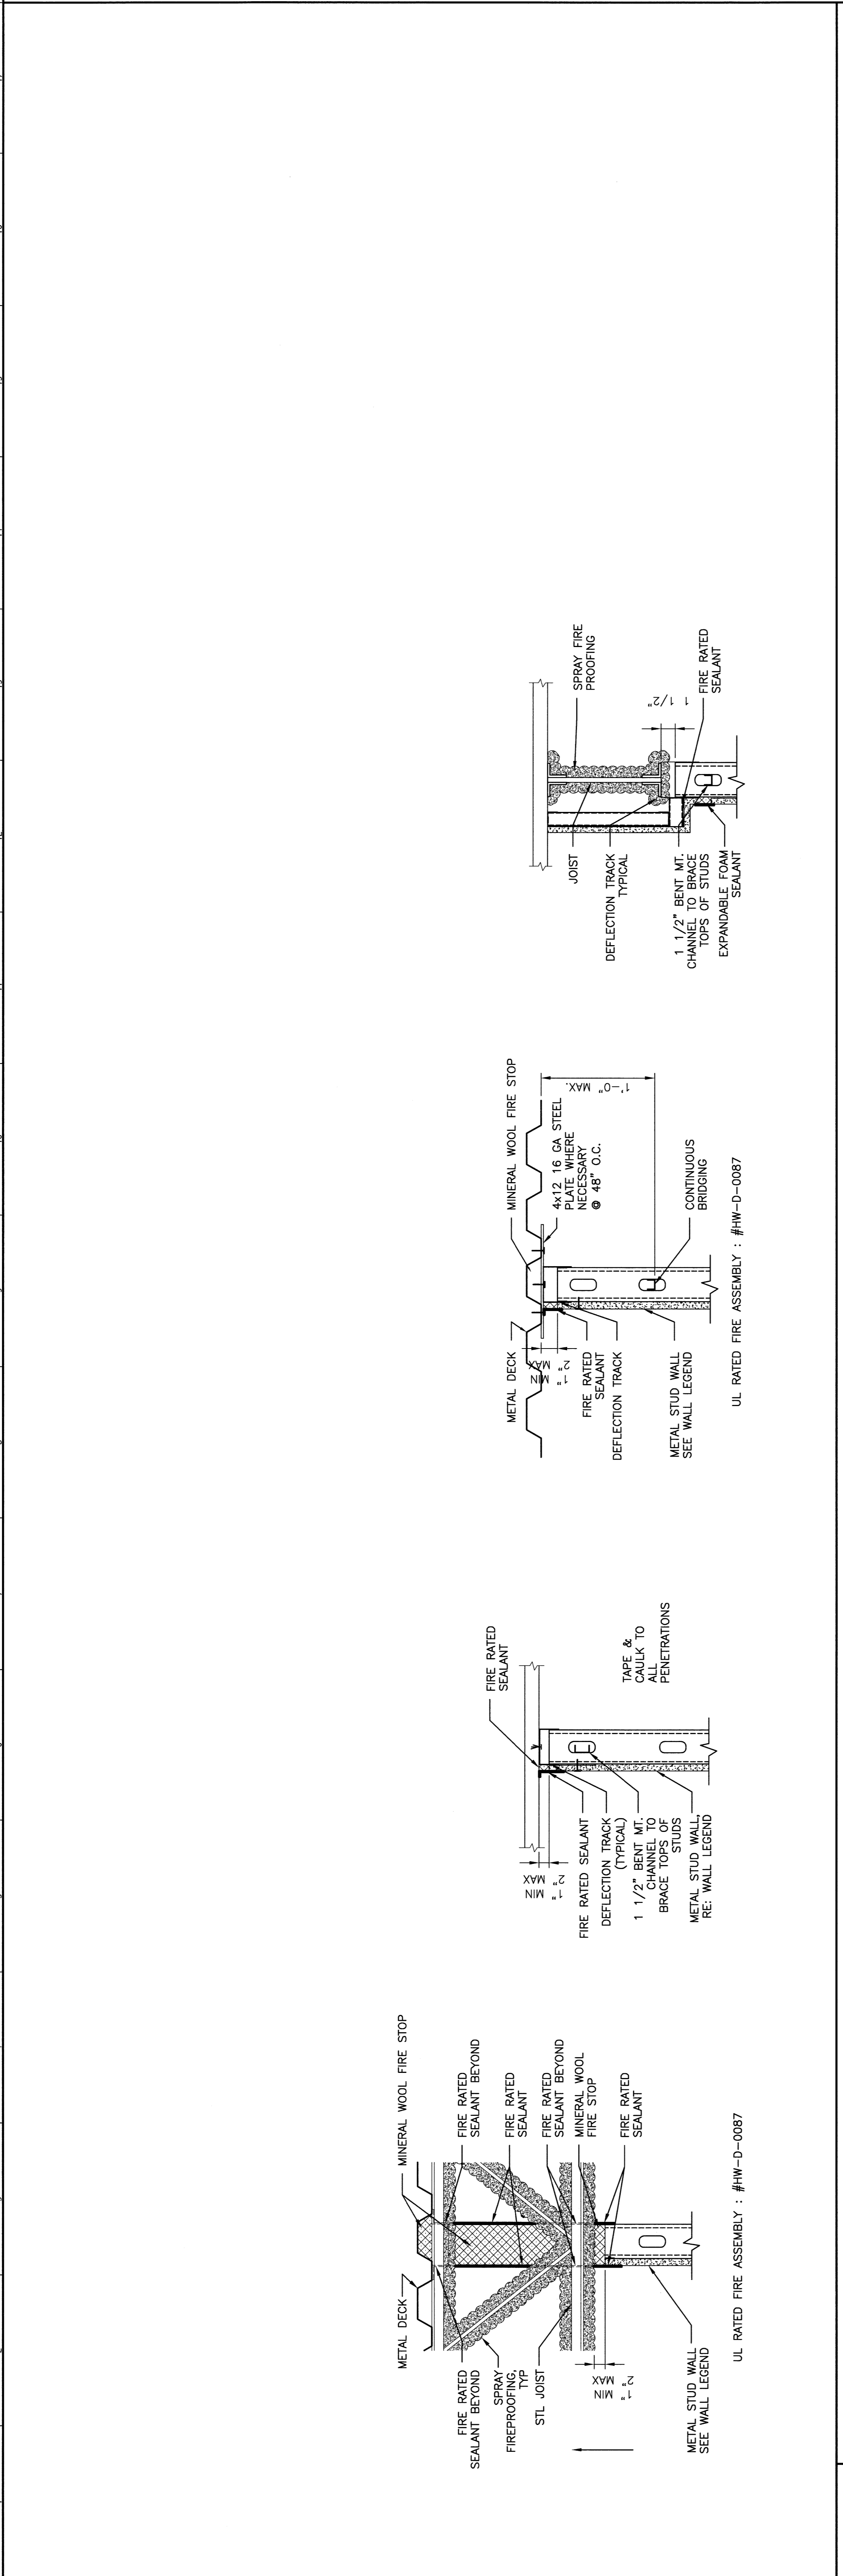

**A1 TOP OF WALL DETAILS**

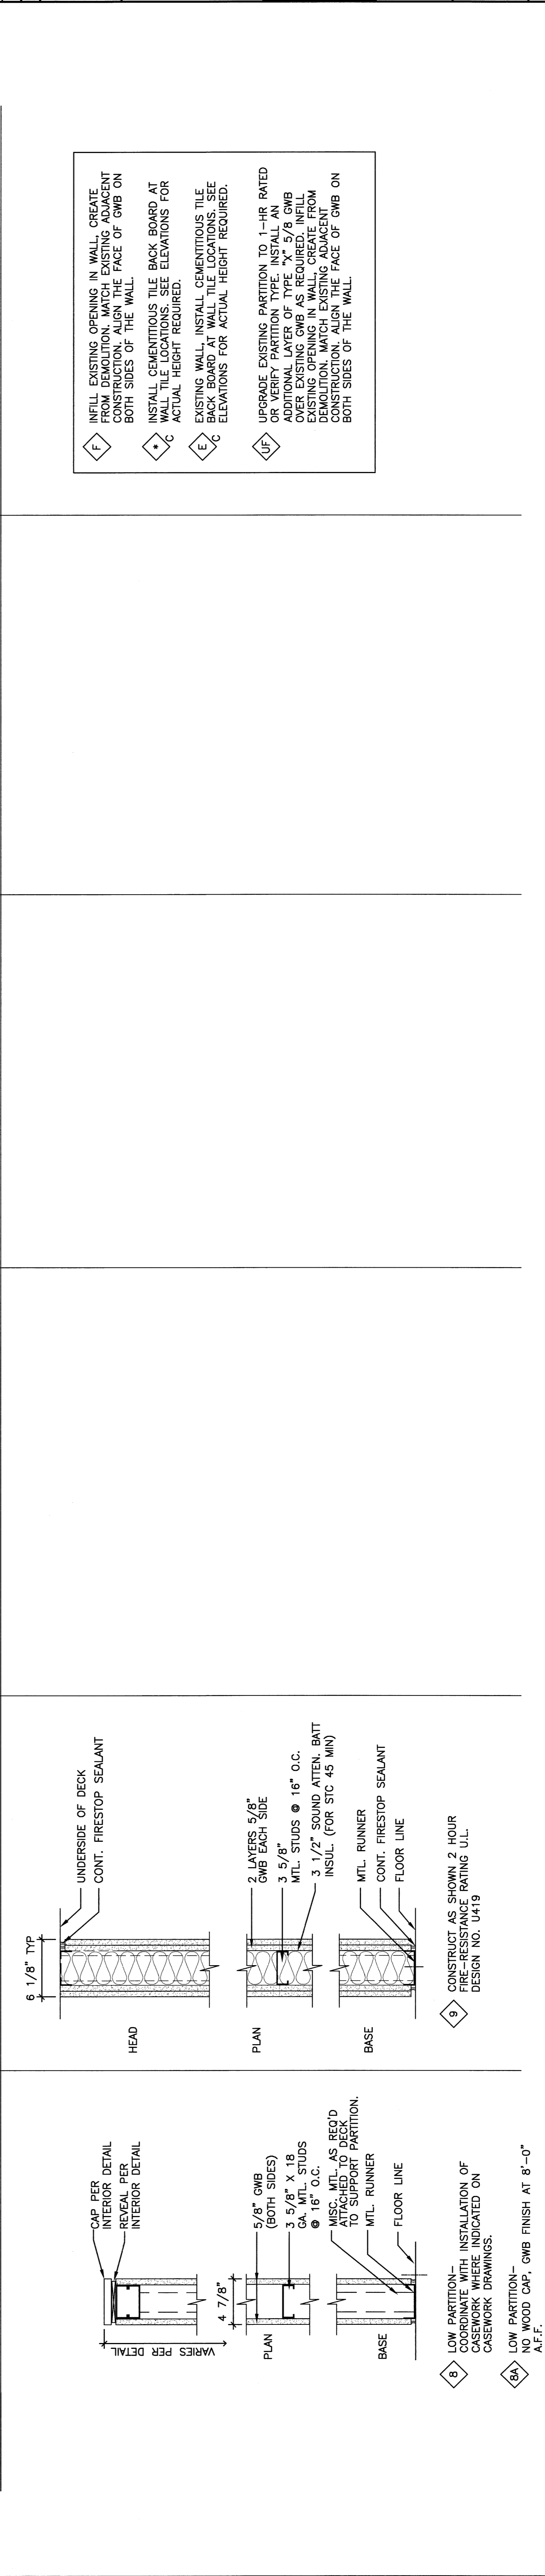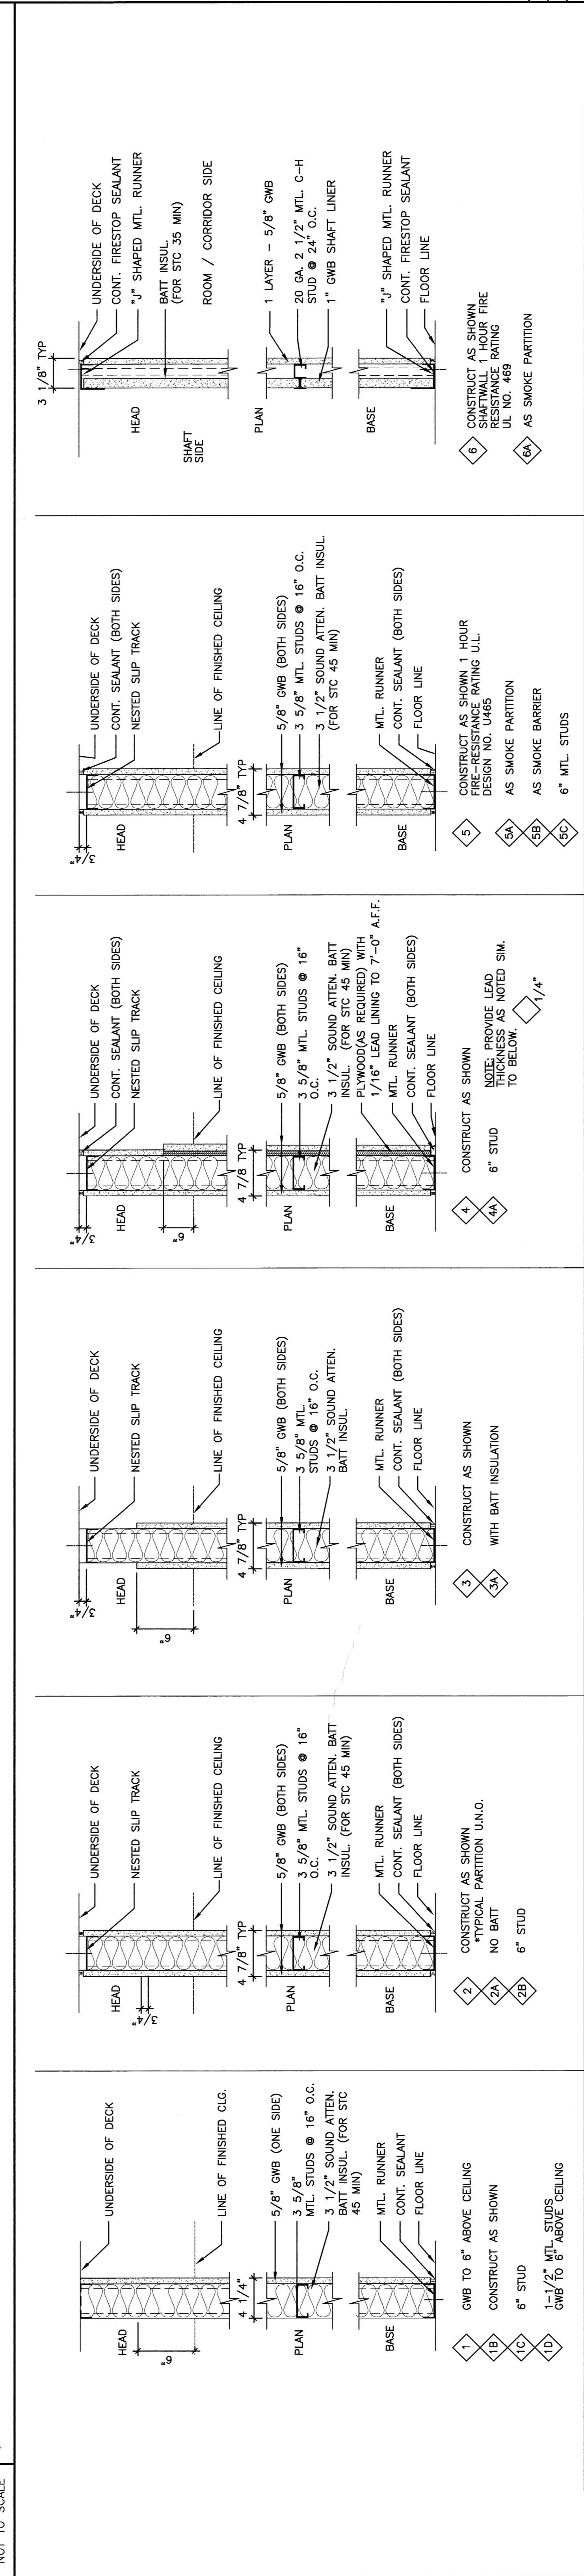


**PARTITION TYPES**

LOW PARTITION - INSULATION OF CASEWORK WHERE INDICATED ON CASEWORK DRAWINGS.

LOW PARTITION - NO WOOD CAP, GWB FINISH AT 8'-0\"/>

**A1**

**ISSUED FOR CONSTRUCTION**  
9-12-08

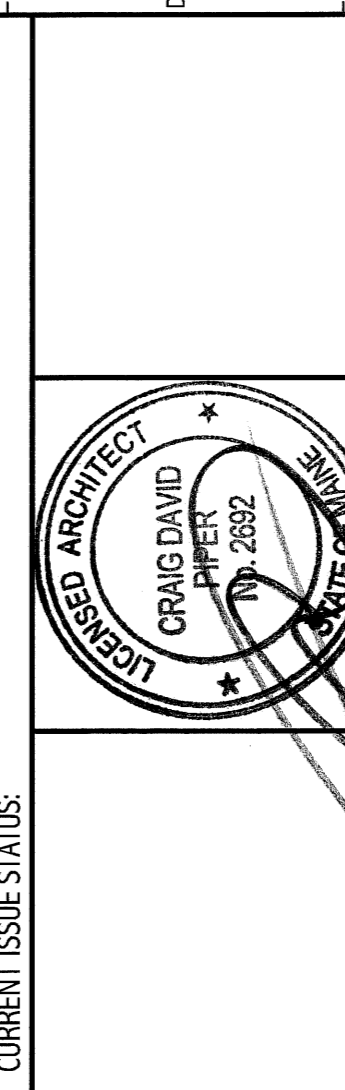

114 Fox Street, Box 818  
Portland, ME 04101  
Tel: (207) 733-3446  
Fax: (207) 732-8076  
www.craigd.com

ARCHITECTURE  
ENGINEERING  
PLANNING  
INTERIOR DESIGN  
COMMISSIONING

**SMRT**  
MAINE MEDICAL CENTER - RICHARDS WING 2ND FLOOR  
INPATIENT SERVICES  
PORTLAND, MAINE

**PARTITION SCHEDULE**

SHEET TITLE	AS NOTED	DATE	9-12-08
SCALE	1"	GRAPHIC SCALE	0'
PROJECT MANAGER	CDP	DATE	
DRAWN BY	CDP	DATE	
CHECKED BY	CDP	DATE	
DATE OF RECORD	CDP	DATE	
SHEET NO.	08103	SHEET No.	G1002
PROJECT No.	08103		