



**NOTE:**


- SEE SHEET FP01 FOR LEGEND AND ABBREVIATIONS.
- AREA IS CURRENTLY PART SPRINKLERED. CONTRACTOR SHALL EXTEND COVERAGE HORIZONTAL SIDEWALL HEADS FOR ASSOCIATED COMPONENTS BACK TO MAIN RISER. CONNECT TO EXISTING RISER WITH NEW SPRINKLER PIPING.
- PROVIDE SPRINKLER COVERAGE PER NFPA 13, LIGHT HAZARD OCCUPANCY.

**KEYED NOTE:**

- THE EXISTING CEILING WILL NOT BE REMOVED. UTILIZE EXTENDED COVERAGE HORIZONTAL SIDEWALL HEADS FOR COVERAGE IN THIS AREA.
- ROUTE SPRINKLER PIPING BELOW CEILING AND CONCEAL IN DECO-SHIELD.

REV.	ISSUED FOR CONSTRUCTION	DATE
0		9-12-08

**ISSUED FOR CONSTRUCTION**  
9-12-08

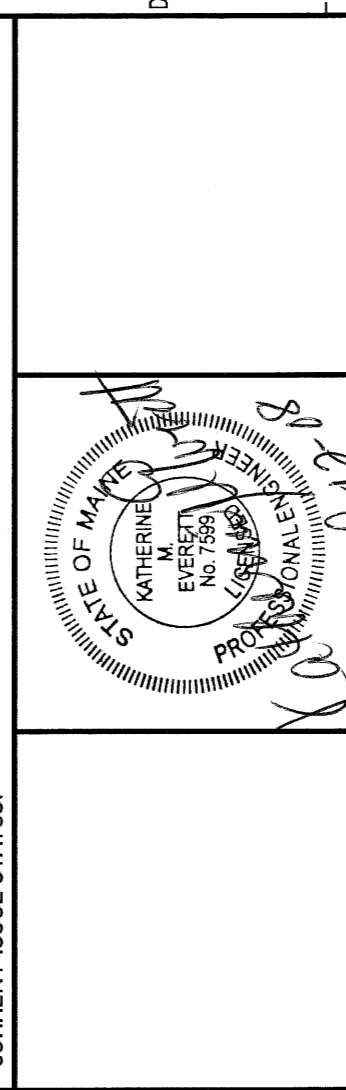

144 Fore Street, P.O. Box 618  
Portland, Maine 04104  
Tel. (603) 772-3846  
Fax. (603) 772-1070  
www.smrri.com

**SMRRI**  
ARCHITECTURE  
ENGINEERING  
PLANNING  
INTERIOR DESIGN  
COMMISSIONING

MAINE MEDICAL CENTER - RICHARDS WING 2ND FLOOR  
INPATIENT SERVICES  
PORTLAND, MAINE

**FIRE PROTECTION**  
**PART PLAN**

SHEET TITLE: FIRE PROTECTION PART PLAN  
SCALE: 1/4" = 1'-0"  
DATE: 9-12-08  
PROJECT MANAGER: MERRILL  
JOB CAP/DRAWN: MERRILL  
A/E OF RECORD: COP  
SHEET No.: FP101  
PROJECT No.: 08103

**A1** PARTIAL REFLECTED CEILING PLAN  
1/4" = 1'-0"