

NOTES:


1. SEE NOTES ON M-001 FOR LEGENDS AND ABBREVIATIONS.

KEYED NOTES:

- ① REMOVE EXISTING REGISTER/GRILLE/DIFFUSERS AS INDICATED. NEW REGISTER/GRILLE/DIFFUSERS TO BE INSTALLED ON NEW CONDITIONS PLAN. PROVIDE BRANCH/TEE OR DUCT AS NEEDED TO MEET THE NEW GRID. PROVIDE TRANSITIONS IF NECESSARY TO MATCH DIFFUSER NECK SIZE BELOW.
- ② HWS/R PIPING IS LOCATED ABOVE THE CEILING OF FLOOR BELOW.
- ③ EXISTING DIFFUSER, DUCTWORK AND ASSOCIATED HVAC SERVING ROOM SHALL REMAIN.

REV.	ISSUED FOR CONSTRUCTION	DATE
0		9-12-08

ISSUED FOR CONSTRUCTION
9-12-08

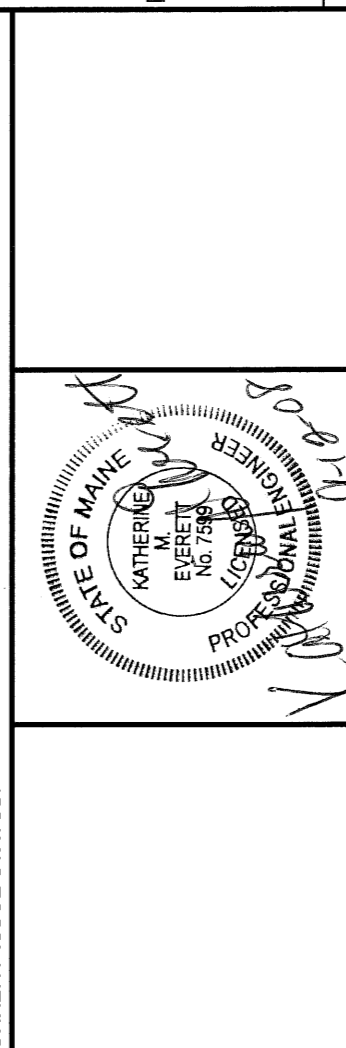

144 Fore Street, P.O. Box 618
Portland, Maine 04104
Tel: (207) 772-8846
Fax: (207) 772-6000
www.smrti.com

SMRTI
ARCHITECTURE
ENGINEERING
PLANNING
INTERIOR DESIGN
COMMISSIONING

**MAINE MEDICAL CENTER - RICHARDS WING 2ND FLOOR
INPATIENT SERVICES**
PORTLAND, MAINE

**PARTIAL SECOND FLOOR
HVAC DEMOLITION PLAN**
SHEET TITLE: 1/4" = 1'-0" DATE: 9-12-08
PROJECT MANAGER: COP GRAPHIC SCALE: 0'
JOB CAP/DRAWN: MORTUOL
DATE OF RECORD: KRE SHEET NO.:
SMRTI CAD FILE: MD101-08103
PROJECT NO.: MD101-08103

A1 PARTIAL FLOOR PLAN
1/4"=1'-0"