



NOTES:
 1. SEE NOTES ON P-001 FOR LEGENDS AND ABBREVIATIONS.
 2. EXISTING SANITARY PIPING IS LOCATED IN CEILING OF FLOOR BELOW.

KEYED NOTES:
 ① EXISTING FUTURE TO REMAIN.
 ② REMOVE EXISTING PLUMBING FIXTURE COMPLETE. REMOVE SLAB WASTE AND VENT PIPING COMPLETE. PATCH FLOOR/WALL TO MATCH EXISTING AS/IF NECESSARY.

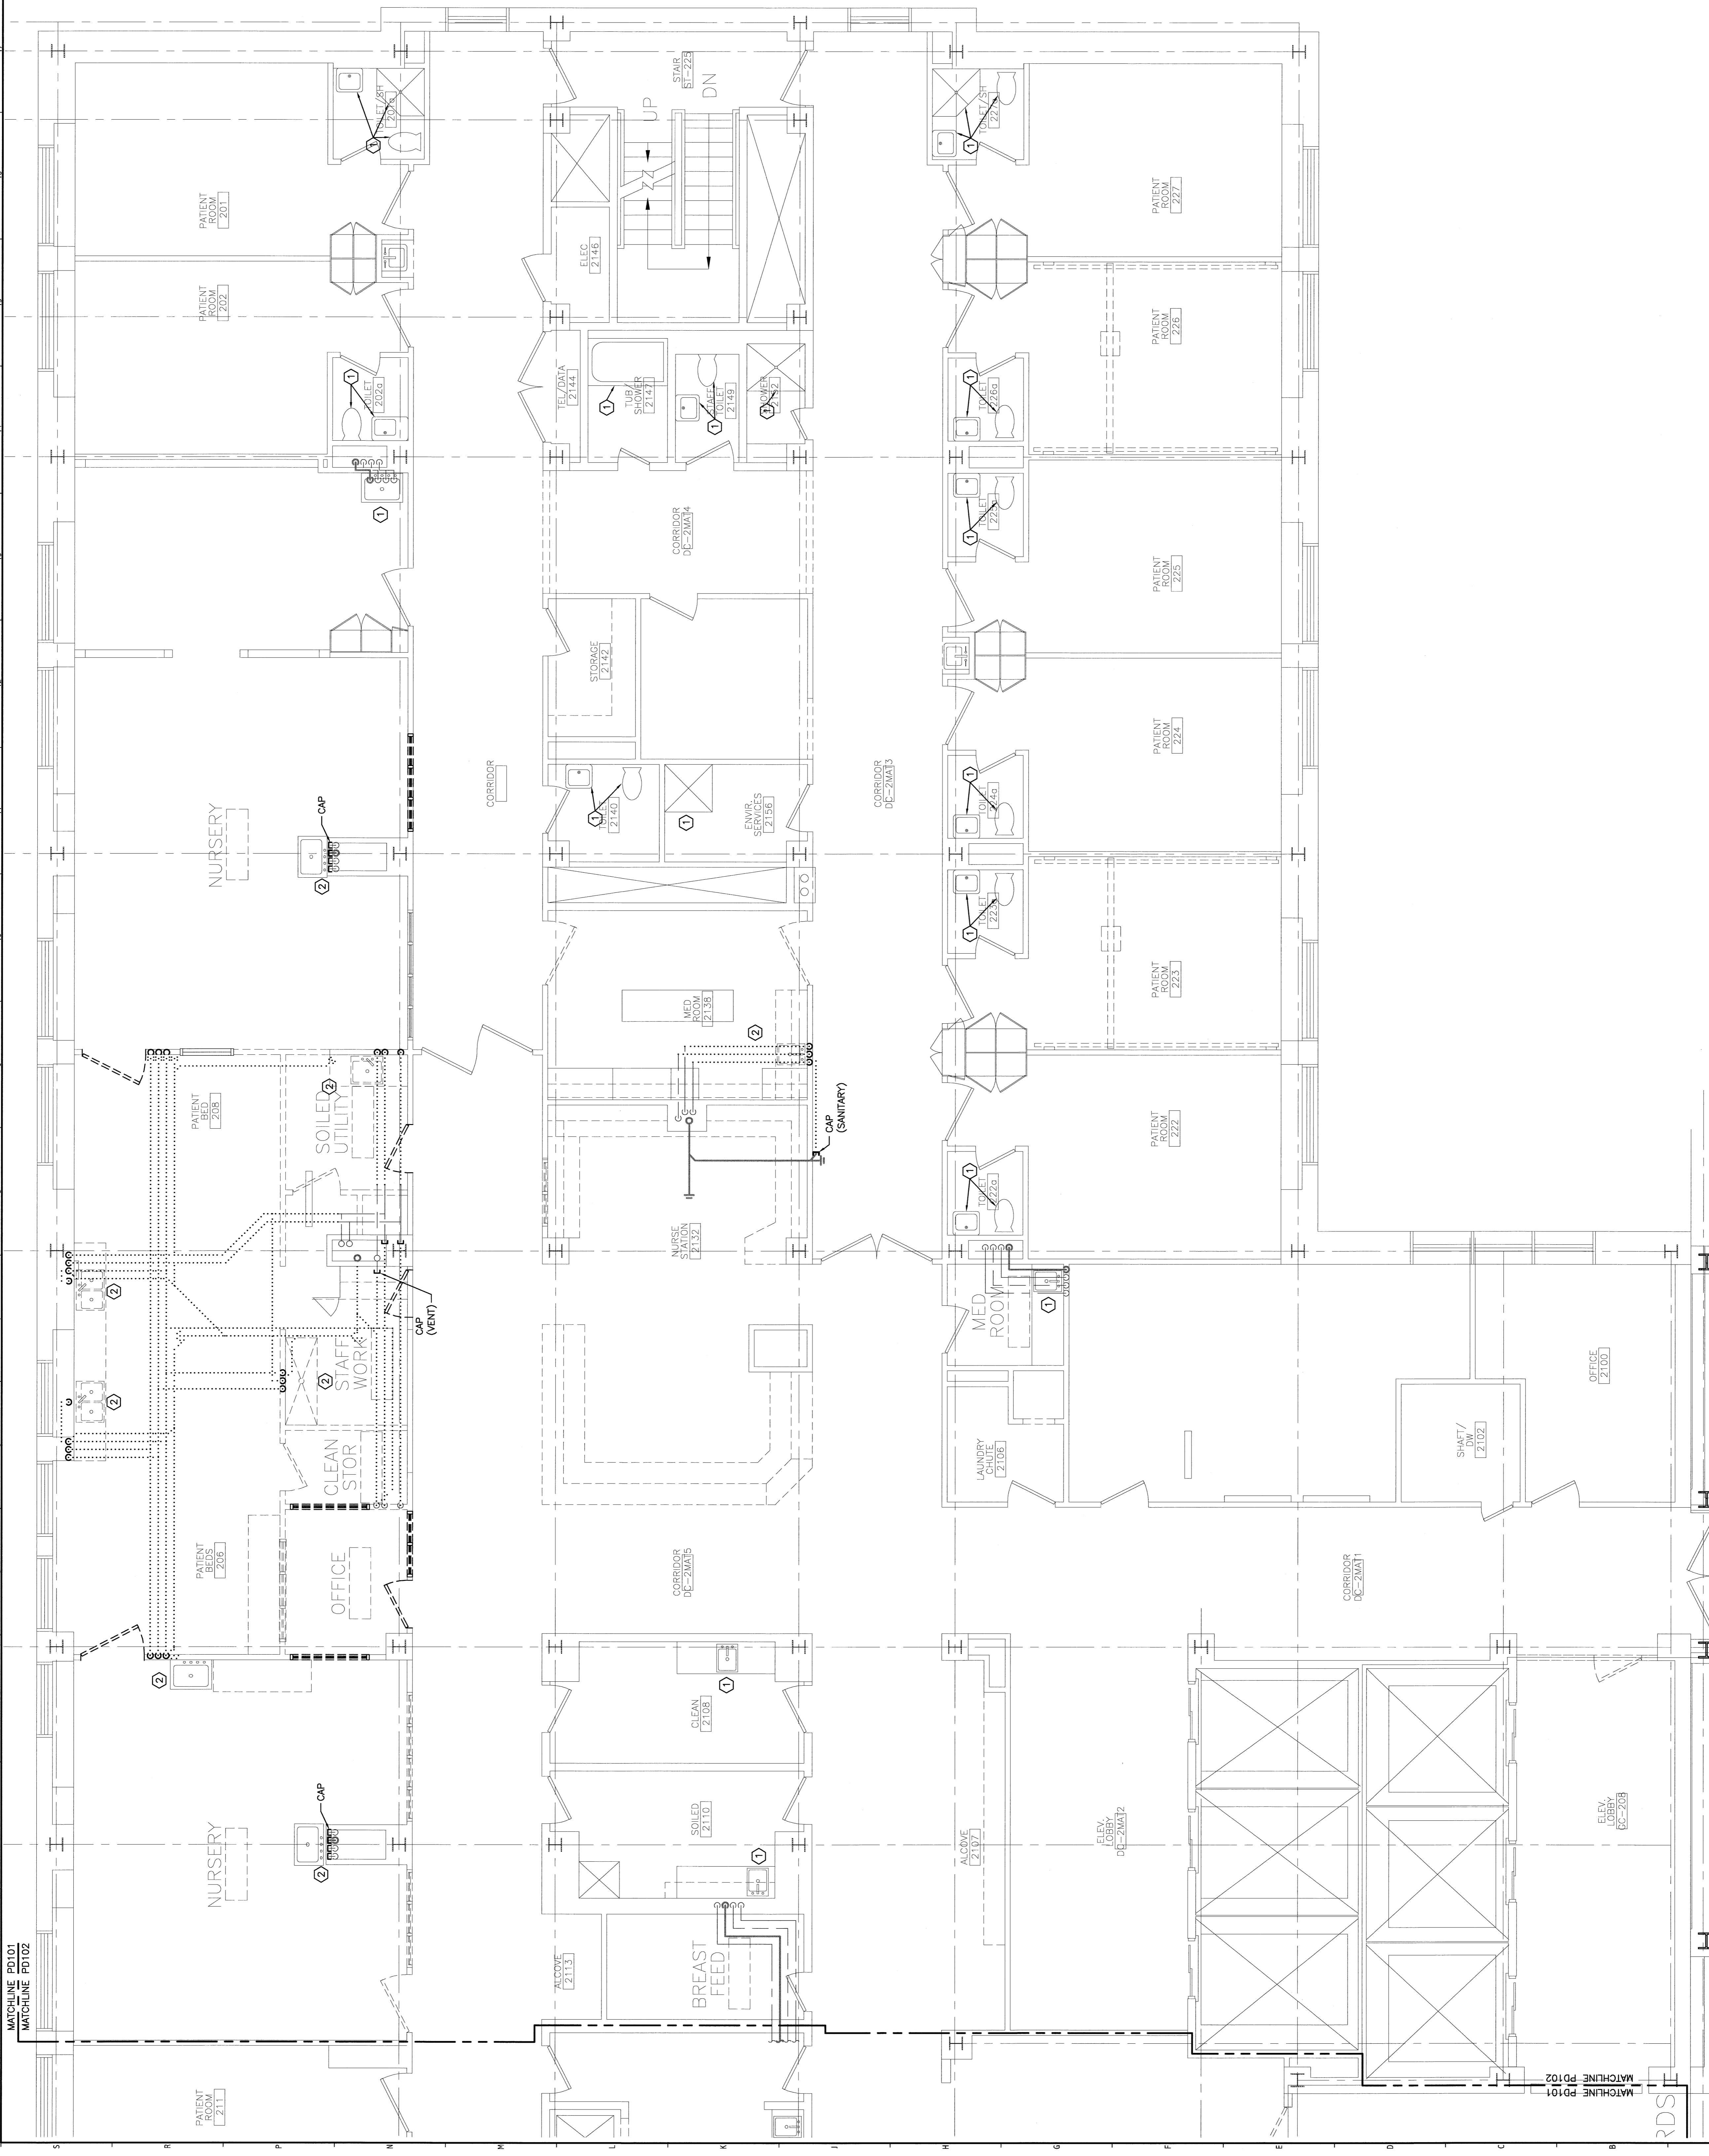

REV.	ISSUED FOR CONSTRUCTION	DATE
0		9-12-08

ISSUED FOR CONSTRUCTION
 9-12-08

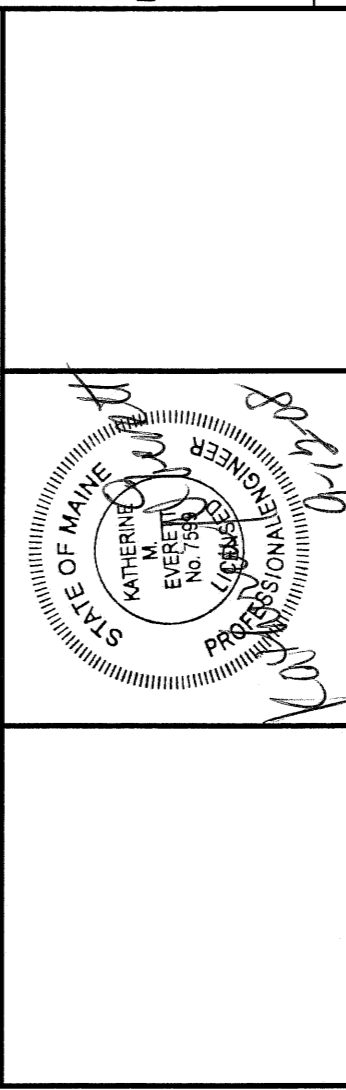

144 Fore Street, Suite 618
 Portland, Maine 04103
 Tel: (207) 772-2846
 Fax: (207) 772-2846
 www.smrtd.com



SMRT
 MAINE MEDICAL CENTER - RICHARDS WING 2ND FLOOR
 INPATIENT SERVICES

PARTIAL SECOND FLOOR
 DWY DEMOLITION PART PLAN

SCALE	DATE	GRAPHIC SCALE
1/4" = 1'-0"	9-12-08	

PROJECT NO. 08103
 SHEET NO. PD102

MATCHLINE PD101
 MATCHLINE PD102

PARTIAL FLOOR PLAN

A1
 1/4" = 1'-0"