


**NOTES:**  
 1. SEE NOTES ON P-001 FOR LEGENDS AND ABBREVIATIONS.

**KEYED NOTES:**  
 ① EXISTING MED GAS OUTLETS TO REMAIN.

ISSUED FOR CONSTRUCTION  
 9-12-08  
 DATE

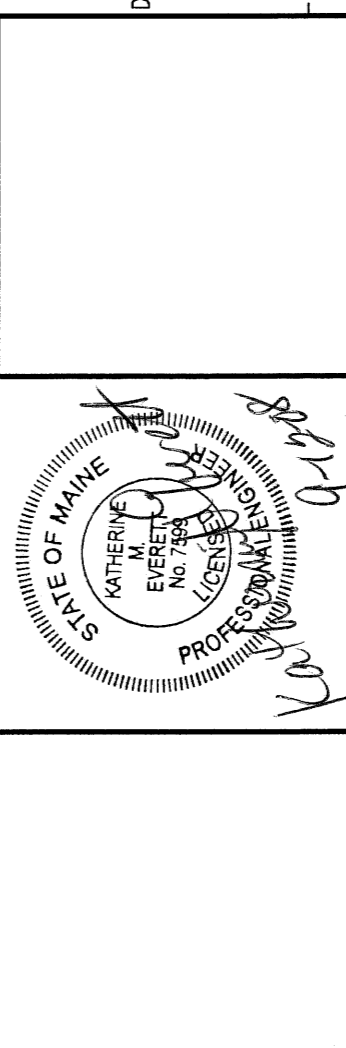

144 Fore Street, Suite 208  
 Portland, ME 04101  
 Tel: (207) 773-3646  
 Fax: (207) 772-8075  
 www.smrtinc.com

**SMRT**  
 ARCHITECTURE  
 ENGINEERING  
 PLANNING  
 INTERIOR DESIGN  
 COMMISSIONING

MAINE MEDICAL CENTER - RICHARDS WING 2ND FLOOR  
 INPATIENT SERVICES  
 PORTLAND, MAINE

PARTIAL SECOND FLOOR  
 MED GAS DEMOLITION PART PLAN

SHEET TITLE: PARTIAL SECOND FLOOR  
 MED GAS DEMOLITION PART PLAN  
 SCALE: 1/4" = 1'-0" DATE: 9-12-08  
 PROJECT NUMBER: 08103  
 JOB CAPTION: MED GAS DEMOLITION PART PLAN  
 DATE OF RECORD: 08103  
 SHEET NUMBER: PD111-08103  
 SHEET TITLE: PD111  
 PROJECT NO.: 08103

A1 PARTIAL FLOOR PLAN  
 1/4" = 1'-0"