


**NOTES:**  
 1. SEE NOTES ON P-001 FOR LEGENDS AND ABBREVIATIONS.  
 2. EXISTING MEDICAL GAS TO REMAIN. THERE IS NO NEW WORK IN THIS AREA.

| REV | ISSUED FOR CONSTRUCTION | DESCRIPTION | DATE    |
|-----|-------------------------|-------------|---------|
| 0   |                         |             | 9-12-08 |

**ISSUED FOR CONSTRUCTION**  
 9-12-08

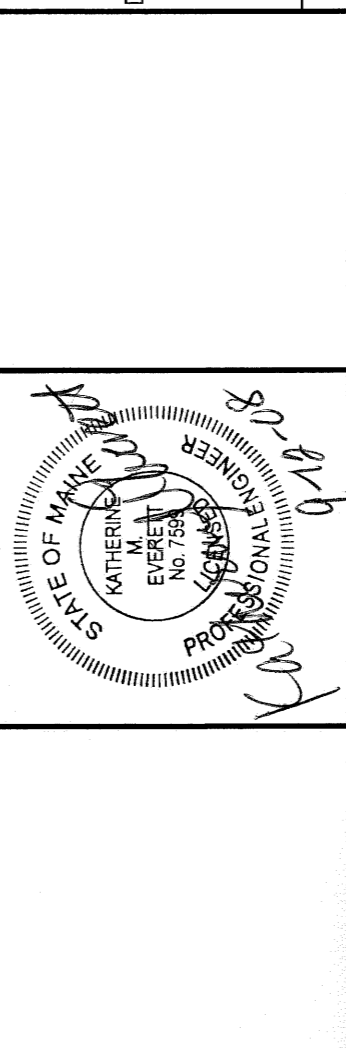

145 Park Street, 20th Floor  
 Portland, Maine 04104  
 Tel: (207) 773-5846  
 Fax: (207) 773-5079  
 www.smrtinc.com

**SMRT**  
 ARCHITECTURE  
 ENGINEERING  
 PLANNING  
 INTERIOR DESIGN  
 COMMISSIONING

MAINE MEDICAL CENTER - RICHARDS WING 2ND FLOOR  
 INPATIENT SERVICES  
 PORTLAND, MAINE

**PARTIAL SECOND FLOOR  
 MED GAS PART PLAN**

SCALE: 1/4" = 1'-0"  
 DATE: 9-12-08  
 PROJECT MANAGER: MERRILL  
 ARCHITECT: SMRT  
 SHEET NO.: PL111

**A1 PARTIAL FLOOR PLAN**

1/2" = 1'-0"