


NOTES:

1. SEE NOTES ON P-001 FOR LEGENDS AND ABBREVIATIONS.


KEYED NOTES:

- ① NOT USED.
- ② INSTALL LOCKABLE SERVICE VALVE.

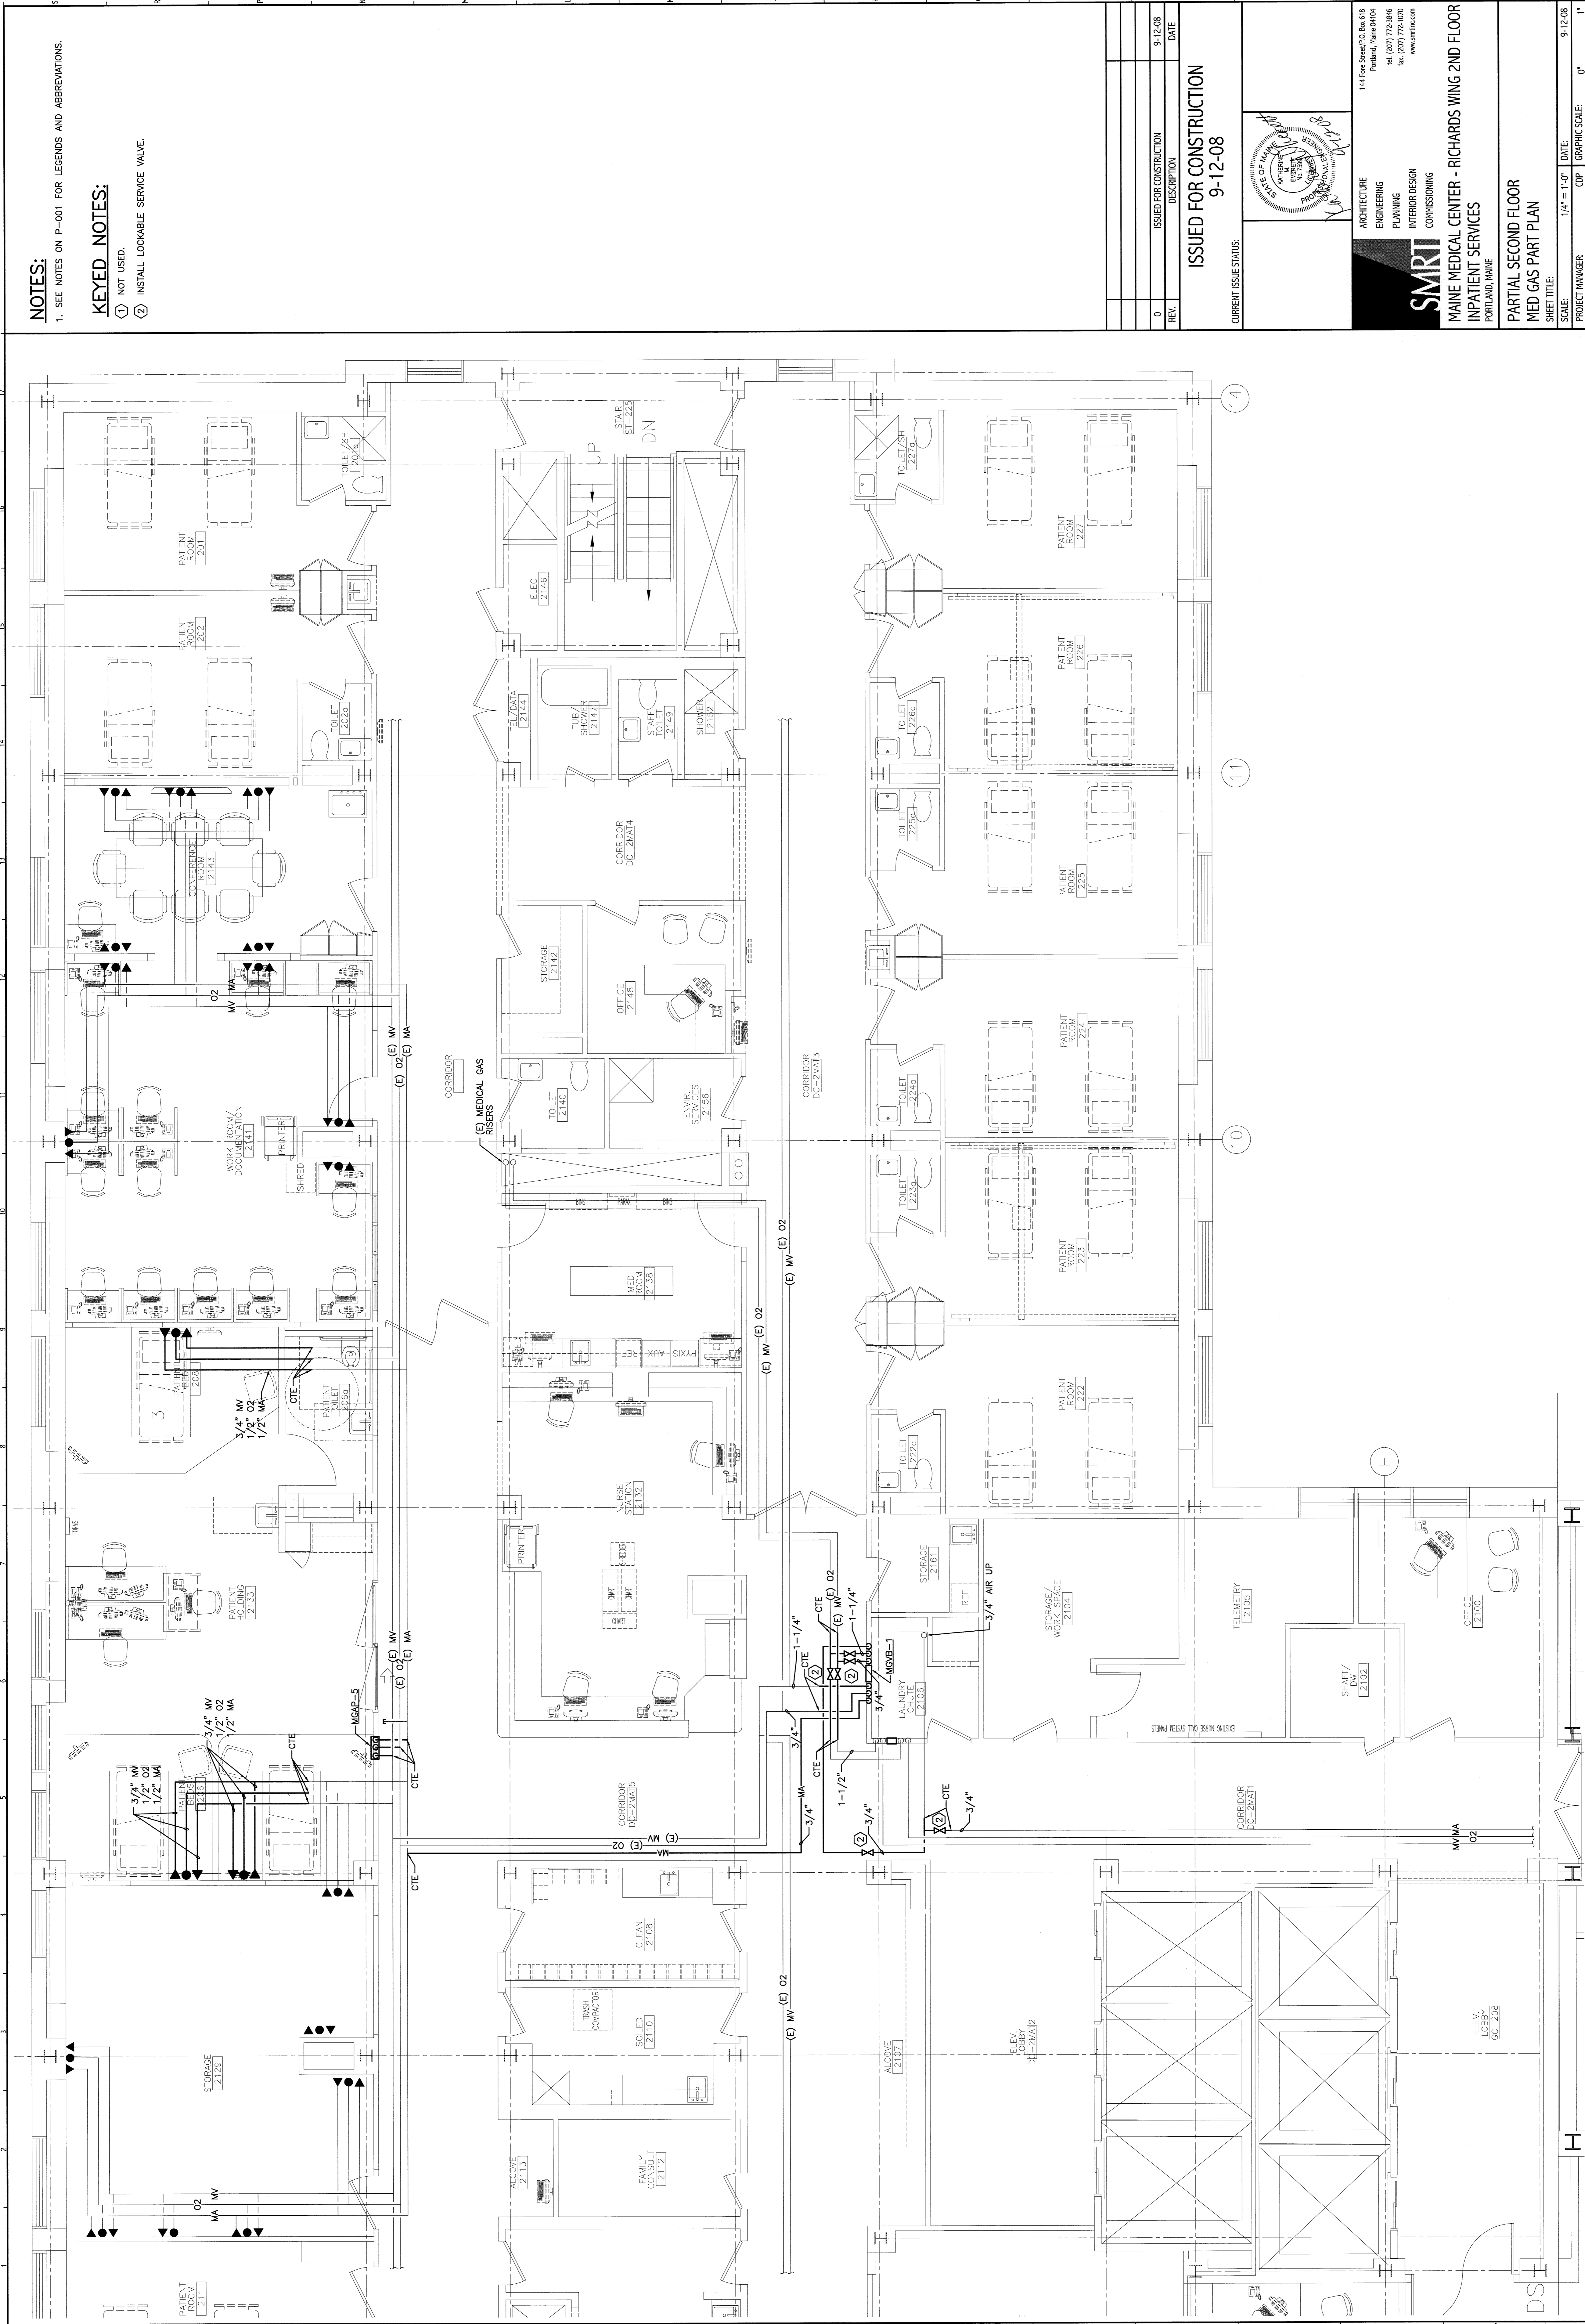

REV.	ISSUED FOR CONSTRUCTION	DESCRIPTION	DATE
0			9-12-08

ISSUED FOR CONSTRUCTION
9-12-08

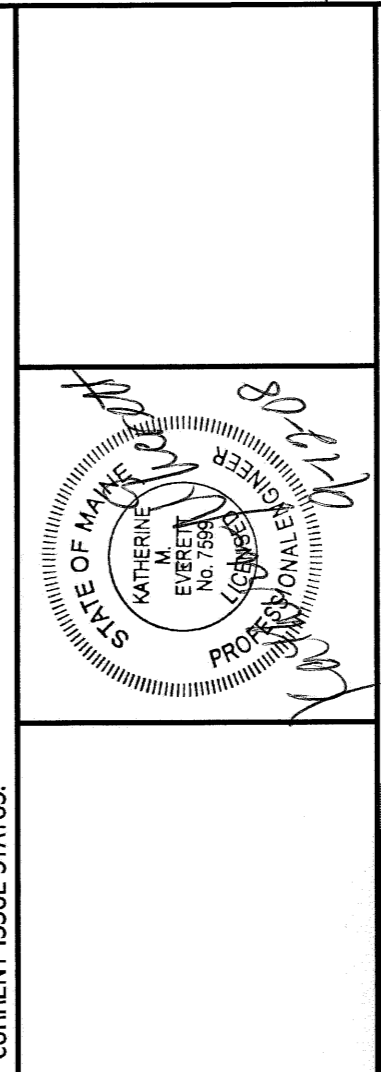

144 Pine Street, 2nd Floor
Portland, Maine 04104
Tel: (207) 772-8486
Fax: (207) 772-0070
www.smrinc.com

SMR INC.
ARCHITECTURE
ENGINEERING
PLANNING
INTERIOR DESIGN
COMMISSIONING

MAINE MEDICAL CENTER - RICHARDS WING 2ND FLOOR
INPATIENT SERVICES
PORTLAND, MAINE

PARTIAL SECOND FLOOR
MED GAS PART PLAN

SCALE:	1/4" = 1'-0"	DATE:	9-12-08
PROJECT MANAGER:	CP	GRAPHIC SCALE:	0'
JOB CAPTAIN:	MERRILL		
DATE OF RECORD:	KNE	SHEET No.	PL112
START CAD FILE:	PL112-08-03	PROJECT No.	08-03

A1 PARTIAL FLOOR PLAN

1/4" = 1'-0"