

NOTE:

1. SEE SHEET E-01 FOR LEGEND AND GENERAL NOTES.
2. ALL CORRIDOR LIGHT FIXTURES SHALL BE CONNECTED TO THE EXISTING NORMAL OR EMERGENCY BRANCH CIRCUITS SERVING THE SPACE. ALL SWITCHING SHALL BE MAINTAINED IN THE EXISTING SPACE. ALL SWITCHING SHALL BE PROVIDED AS-BUILT INFORMATION OF ACTUAL CIRCUIT NUMBERS AND SWITCHING USED.


KEYED NOTE:

- ① PROVIDE NEW LOCAL SWITCH FOR EXISTING LIGHT FIXTURES. INTERCEPT AND EXTEND EXISTING NORMAL LIGHTING BRANCH CIRCUIT SERVING THE SPACE AHEAD OF SWITCHING AND REMOVE FIXTURES AS REQUIRED.
- ② PROVIDE NEW LOCAL SWITCH FOR EXISTING LIGHT FIXTURES. REMOVE EXISTING LOCAL SWITCH AND INTERCEPT AND EXTEND EXISTING NORMAL LIGHTING BRANCH CIRCUIT SERVING THE AREA AHEAD OF SWITCHING AND REMOVE FIXTURES AS REQUIRED.
- ③ REINSTALL 1"x4", 2-LAMP LENSED TROFFER REMOVED DURING DEMOLITION. PROVIDE NEW SWITCHING AND BRANCH CIRCUIT SERVING THE AREA.
- ④ REMOVE EXISTING LIGHT SWITCH AND REMOVE AND REMOVE BRANCH CIRCUIT WIRING AS REQUIRED.
- ⑤ CONNECT TO EXISTING NORMAL LIGHTING BRANCH CIRCUIT SERVING THE SPACE.

REV.	DESCRIPTION	DATE
0	ISSUED FOR CONSTRUCTION	9-12-08

ISSUED FOR CONSTRUCTION
9-12-08

CURRENT ISSUE STATUS:

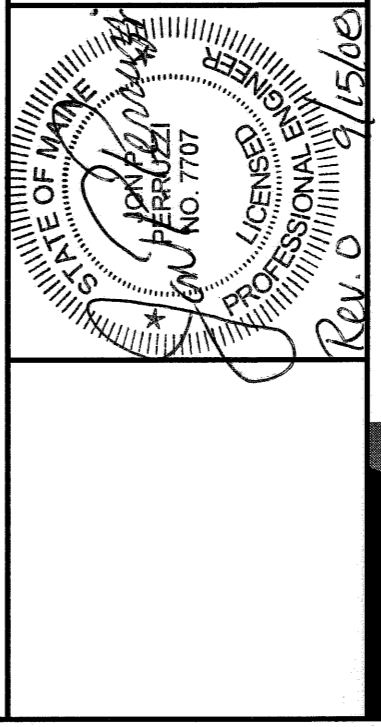

144 Pine Street, 6th Fl. 618
Portland, Maine 04104
Tel: (207) 773-3846
Fax: (207) 773-0070
www.smartinc.com



SMART
ARCHITECTURE
ENGINEERING
PLANNING
INTERIOR DESIGN
COMMISSIONING

MAINE MEDICAL CENTER - RICHARDS WING 2ND FLOOR
INPATIENT SERVICES
PORTLAND, MAINE

LIGHTING
PARTIAL FLOOR PLAN SHEET 1

SHEET TITLE	DATE	9-12-08
SCALE	GRAPHIC SCALE	0"
PROJECT MANAGER	CDP	
JOB CAP/DRAWING	MARK/CD	
DATE OF RECORD	APP	
SMART CAD FILE	ELI01-08103	
PROJECT No.	08103	
SHEET No.	EL101	

A1 PARTIAL FLOOR PLAN

1/4"=1'-0"