

- REFLECTED CEILING NOTES**
- FIRE SPRINKLERS SHALL BE LOCATED IN ALIGNMENT WITH OTHER CEILING ITEMS, TYPICALLY.
 - FIRE SPRINKLERS SHALL BE CENTERED IN CEILING TILE. LIGHT FIXTURE POSITIONS INDICATED.
 - FIRE SPRINKLERS SHALL BE PLACED TO COORDINATE WITH LIGHT FIXTURE POSITIONS INDICATED.
 - ALIGN CEILING ITEMS AS SHOWN, WITH COMMON CENTERLINES, UNLESS OTHERWISE NOTED. DIMS IN CEILINGS, OR IN AREAS UNLESS INDICATED OTHERWISE.
 - REFER TO ROOM FINISH SCHEDULE FOR CEILING HEIGHTS AND CEILING FINISHES TO BE PROVIDED.
 - EXCEPT WHERE INDICATED, CENTER CEILING GRIDS IN ROOMS. USE HALF TILES OR GREATER PERIMETERS AS POSSIBLE.
 - PROVIDE ACCESS PANELS, AS REQUIRED IN OMB CEILINGS FOR ACCESS TO MECHANICAL VALVES/ CONTROLS. REFERENCE MECHANICAL.


- KEYED NOTES:**
- BOTTOM OF SOFFIT TO BE 3" LOWER THEN LOWEST ADJACENT CEILING AS SCHEDULED.
 - CURTAIN TRACK
 - CEILING MOUNTED PROJECTOR
 - W TRACK - "J" CONFIGURATION.
 - CURTAIN ROD
 - CEILING MOUNTED OR LIGHT, OWNER PROVIDE/CONTRACTOR INSTALLER.

- SYMBOL LEGEND**
- 2x2 SUSPENDED CEILING PANEL AND GRID ASSEMBLY.
 - 2x4 SUSPENDED CEILING PANEL AND GRID ASSEMBLY.
 - 2x2 SUSPENDED ACT 5 ("WOOD LOOK") CEILING PANEL AND GRID ASSEMBLY.
 - OMB CEILING.
 - 2x4 LAY-IN LIGHT FIXTURE.
 - 1x4 PENDANT LIGHT FIXTURE.
 - DOWN LIGHT.
 - CEILING MOUNTED EXIT LIGHT.
 - RETURN AIR GRILLE.
 - SUPPLY AIR GRILLE.
 - EXHAUST AIR GRILLE.
 - RADIANT CEILING PANEL. SEE MECH.
 - CEILING MOUNTED SMOKE DETECTOR.
 - ACCESS PANEL - FINAL QUANTITIES, SIZES AND LOCATIONS TO BE DETERMINED IN FIELD.

REV.	ISSUED FOR CONSTRUCTION	DATE
0		9-12-08

ISSUED FOR CONSTRUCTION
9-12-08

CURRENT ISSUE STATUS:

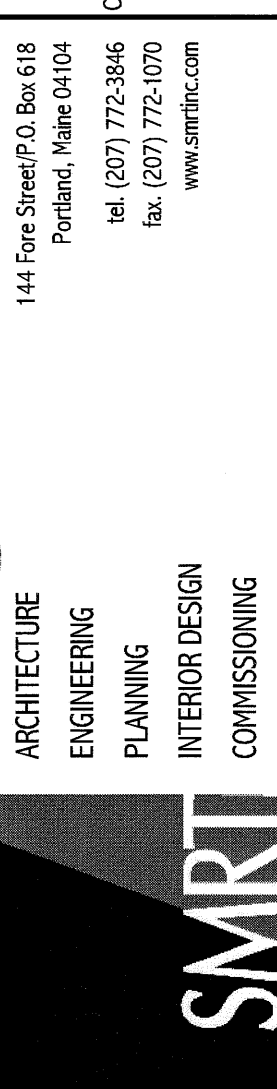

144 Free Street P.O. Box 618
Portland, Maine 04104
Tel: (207) 772-3846
Tel: (207) 772-1070
www.smrta.com

SMRTA
ARCHITECTURE
ENGINEERING
PLANNING
INTERIOR DESIGN
COMMISSIONING

MAINE MEDICAL CENTER - LL BEAN WING 2ND FLOOR
SURGICAL SERVICES
PORTLAND, MAINE

PARTIAL REFLECTED CEILING PLAN

SHEET TITLE	DATE
SCALE: 1/4" = 1'-0"	9-12-08
PROJECT MANAGER: COP	GRAPHIC SCALE: 0'
DWG. CDR/DRAWN: MHR	
DATE OF RECORD: COP	
SHEET NO.: AE103	
PROJECT No.: 08008	

