

NOTE:
1. SEE SHEET E-001 FOR LEGEND AND GENERAL NOTES.


KEYED NOTE:

- ① ALL EXISTING RECESSED LIGHT FIXTURES TO BE REMOVED AND MULTIPLE BRANCH CIRCUITS TO BE CEASED AS SHOWN ON EP101 OR REMOVED BACK TO SOURCE PANELBOARD IN UTILITY CLOSET 208B AND LABELED "SPARE".
- ② MOTORIZED DOOR OPERATOR TO BE REMOVED AND RELOCATED AS INDICATED ON EP101.
- ③ EXISTING 2"x2" LENSED TROFFER TO BE REMOVED AND REINSTALLED AS INDICATED ON LIGHTING PLANS.
- ④ EXISTING OPERATING ROOM RECESSED LIGHT FIXTURES TO BE REMOVED CAREFULLY STORED AND REINSTALLED AS INDICATED ON LIGHTING PLANS.
- ⑤ EXISTING WALL CLOCK AND ELAPSE TIME CLOCK TO BE REMOVED AND REINSTALLED AS INDICATED ON SYSTEMS PLANS.
- ⑥ EXISTING INSULATED GROUND RECEPTACLE TO BE REMOVED AND REINSTALLED AS INDICATED ON POWER PLANS.
- ⑦ EXISTING 2"x4" LENSED TROFFER TO BE REMOVED AND REINSTALLED AS INDICATED ON LIGHTING PLANS.
- ⑧ EXISTING 1"x4" LENSED TROFFER TO BE REMOVED AND REINSTALLED AS INDICATED ON LIGHTING PLANS.
- ⑨ EXISTING LIGHT SWITCHES TO BE REMOVED AND RELOCATED AS INDICATED ON LIGHTING PLANS.
- ⑩ EXISTING SMOKE DAMPER TO BE REMOVED OR ABANDONED AS SHOWN ON MECHANICAL PLANS. NEW SMOKE DETECTOR AND ASSOCIATED CONTROLS AND RELocate TO NEW DAMPER LOCATIONS AS INDICATED ON MECHANICAL AND SYSTEMS PLANS.

REV.	DESCRIPTION	DATE
0	ISSUED FOR CONSTRUCTION	9-12-08

ISSUED FOR CONSTRUCTION
9-12-08

CURRENT ISSUE STATUS:

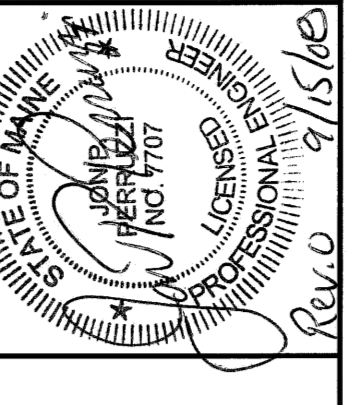


144 Free Street, 2nd Floor
Portland, Maine 04104
Tel: (207) 772-3846
Fax: (207) 772-0070
www.smrtinc.com

SMRT
ARCHITECTURE
ENGINEERING
PLANNING
INTERIOR DESIGN
COMMISSIONING

MAINE MEDICAL CENTER - L.L. BEAN WING 2ND FLOOR
SURGICAL SERVICES
PORTLAND, MAINE

ELECTRICAL
DEMOLITION PLAN

SHEET TITLE	DATE	GRAPHIC SCALE	9-12-08
SCALE: 1/8" = 1'-0"	DATE	GRAPHIC SCALE	9-12-08
PROJECT MANAGER	DATE	GRAPHIC SCALE	9-12-08
JOB CAPTAIN/INCH	DATE	GRAPHIC SCALE	9-12-08
DATE OF RECORD	DATE	GRAPHIC SCALE	9-12-08
SMRT CAD FILE	DATE	GRAPHIC SCALE	9-12-08
PROJECT No.	DATE	GRAPHIC SCALE	9-12-08

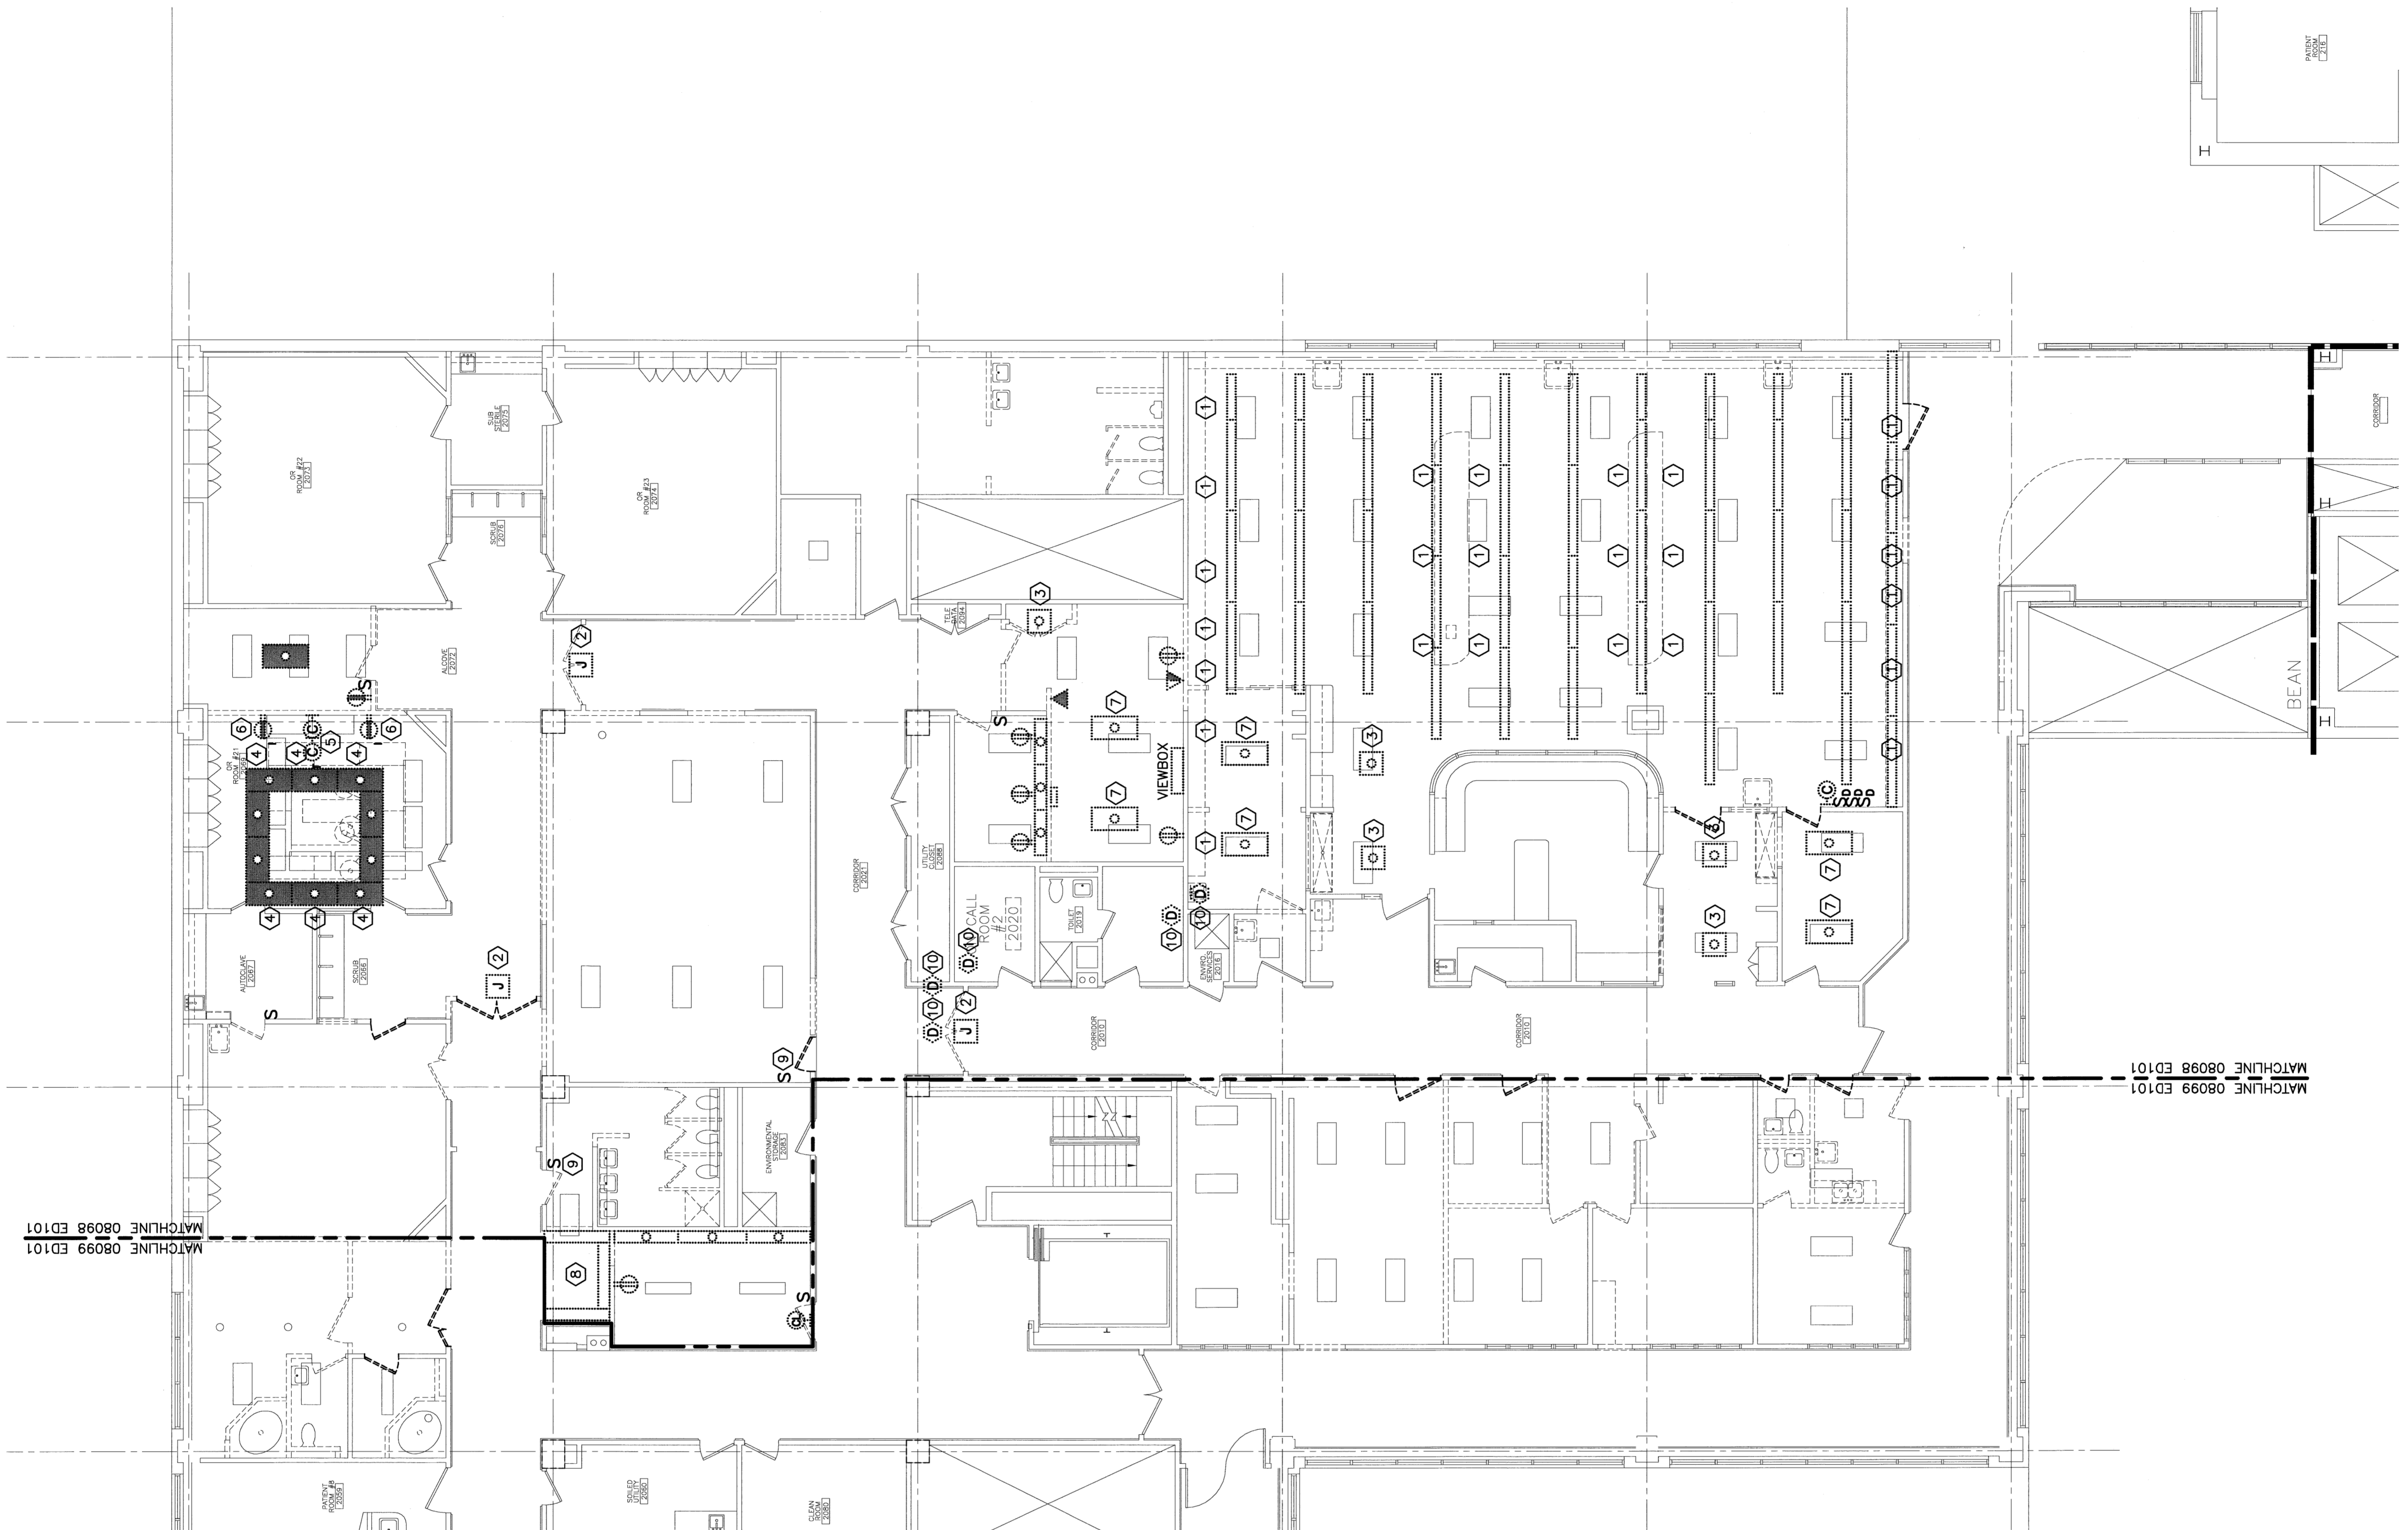

A9 DEMOLITION PLAN

1/8" = 1'-0"

ED101

08098

08098