


NOTE:

1. SEE SHEET E-001 FOR LEGEND AND GENERAL NOTES.
2. ALL LIGHT FIXTURES, BRACKETS, ETC. SHOWN WITH LIGHT LINE WEIGHTS ARE EXISTING TO BE MAINTAINED UNLESS OTHERWISE NOTED.
3. ALL NEW EXIT SIGNS SHALL BE CONNECTED TO NEAREST LIFE SAFETY LIGHTING BRANCH CIRCUIT.

KEYED NOTE:

- ① REINSTALL 2'X2' LENSED TROFFER REMOVED DURING INSTALLATION. CLEAN AND RELAMP FIXTURE BEFORE INSTALLATION.
- ② CONNECT TO EXISTING CRITICAL LIGHTING BRANCH CIRCUIT SERVING THE AREA VIA NEW SWITCHING AS INDICATED.
- ③ CONNECT TO EXISTING NORMAL LIGHTING BRANCH CIRCUIT SERVING THE AREA VIA NEW SWITCHING AS INDICATED.
- ④ NOT USED
- ⑤ CONNECT TO EXISTING SWITCHED CORRIDOR NORMAL LIGHTING BRANCH CIRCUIT.
- ⑥ REINSTALL EXISTING OPERATING ROOM LIGHT FIXTURE REMOVED DURING INSTALLATION AND RECONNECT TO EXISTING SWITCHING AS REQUIRED.
- ⑦ INSTALL NEW OPERATING ROOM LIGHT FIXTURE AND CONNECT TO EXISTING SWITCHED LIGHTING BRANCH AS REQUIRED.
- ⑧ CONNECT TO EXISTING 120V RECEPTACLE BRANCH CIRCUIT SERVING THE ALCOVE AS INDICATED ON EP101.
- ⑨ REINSTALL 2'X4' LENSED TROFFER REMOVED DURING DEMOLITION. CLEAN AND RELAMP FIXTURE BEFORE INSTALLATION.
- ⑩ PROVIDE NEW SWITCH DEVICE FOR MODIFIED CONTROL OF EXISTING ROOM LIGHTING. REWIRE AS NECESSARY FOR SWITCHING AS INDICATED.

ISSUED FOR CONSTRUCTION
9-12-08

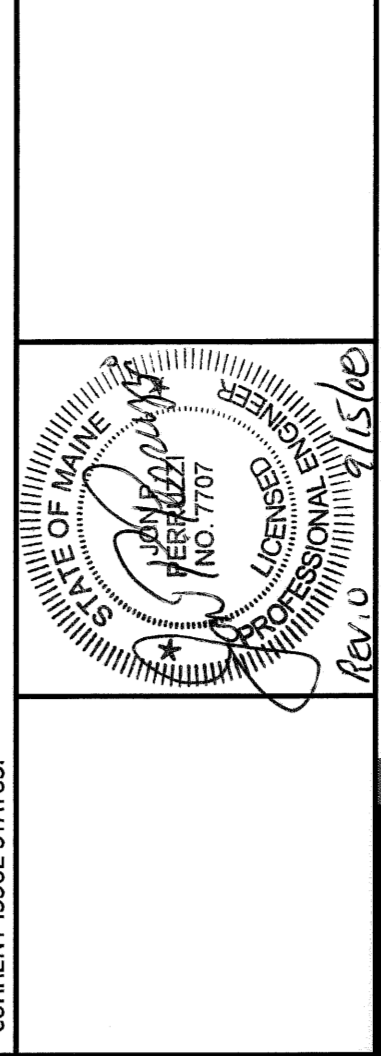

144 Pine Street, 6th Fl. Box 618
Portland, Maine 04104
Tel: (207) 772-3846
Fax: (207) 772-0270
www.smrinc.com

SMR INC.
ARCHITECTURE
ENGINEERING
PLANNING
INTERIOR DESIGN
COMMISSIONING

MAINE MEDICAL CENTER - L.L. BEAN WING 2ND FLOOR
SURGICAL SERVICES
PORTLAND, MAINE

LIGHTING	
PARTIAL FLOOR PLAN SHEET 1	
SHEET TITLE	DATE: 9-12-08
SCALE: 1/4" = 1'-0"	GRAPHIC SCALE: 0'
PROJECT MANAGER: JRS CAPORASO	DATE: 9-12-08
DATE OF RECORD: 9-12-08	GRAPHIC SCALE: 0'
SHEET CAD FILE: EL101-0809B	PROJECT No. EL101
PROJECT No. 0809B	SHEET No. EL101

