



**NOTE:**

1. SEE SHEET M-001 FOR LEGEND AND ABBREVIATIONS.
2. PROVIDE NEW CONTROLS FOR ALL EXISTING TO REMAIN TERMINAL BOXES, INCLUDING CONTROL VALVE, DAMPER ACTUATORS AND ROOM TEMPERATURE SENSORS. TIE-IN TO EXISTING HONEYWELL EBI DDC SYSTEM.

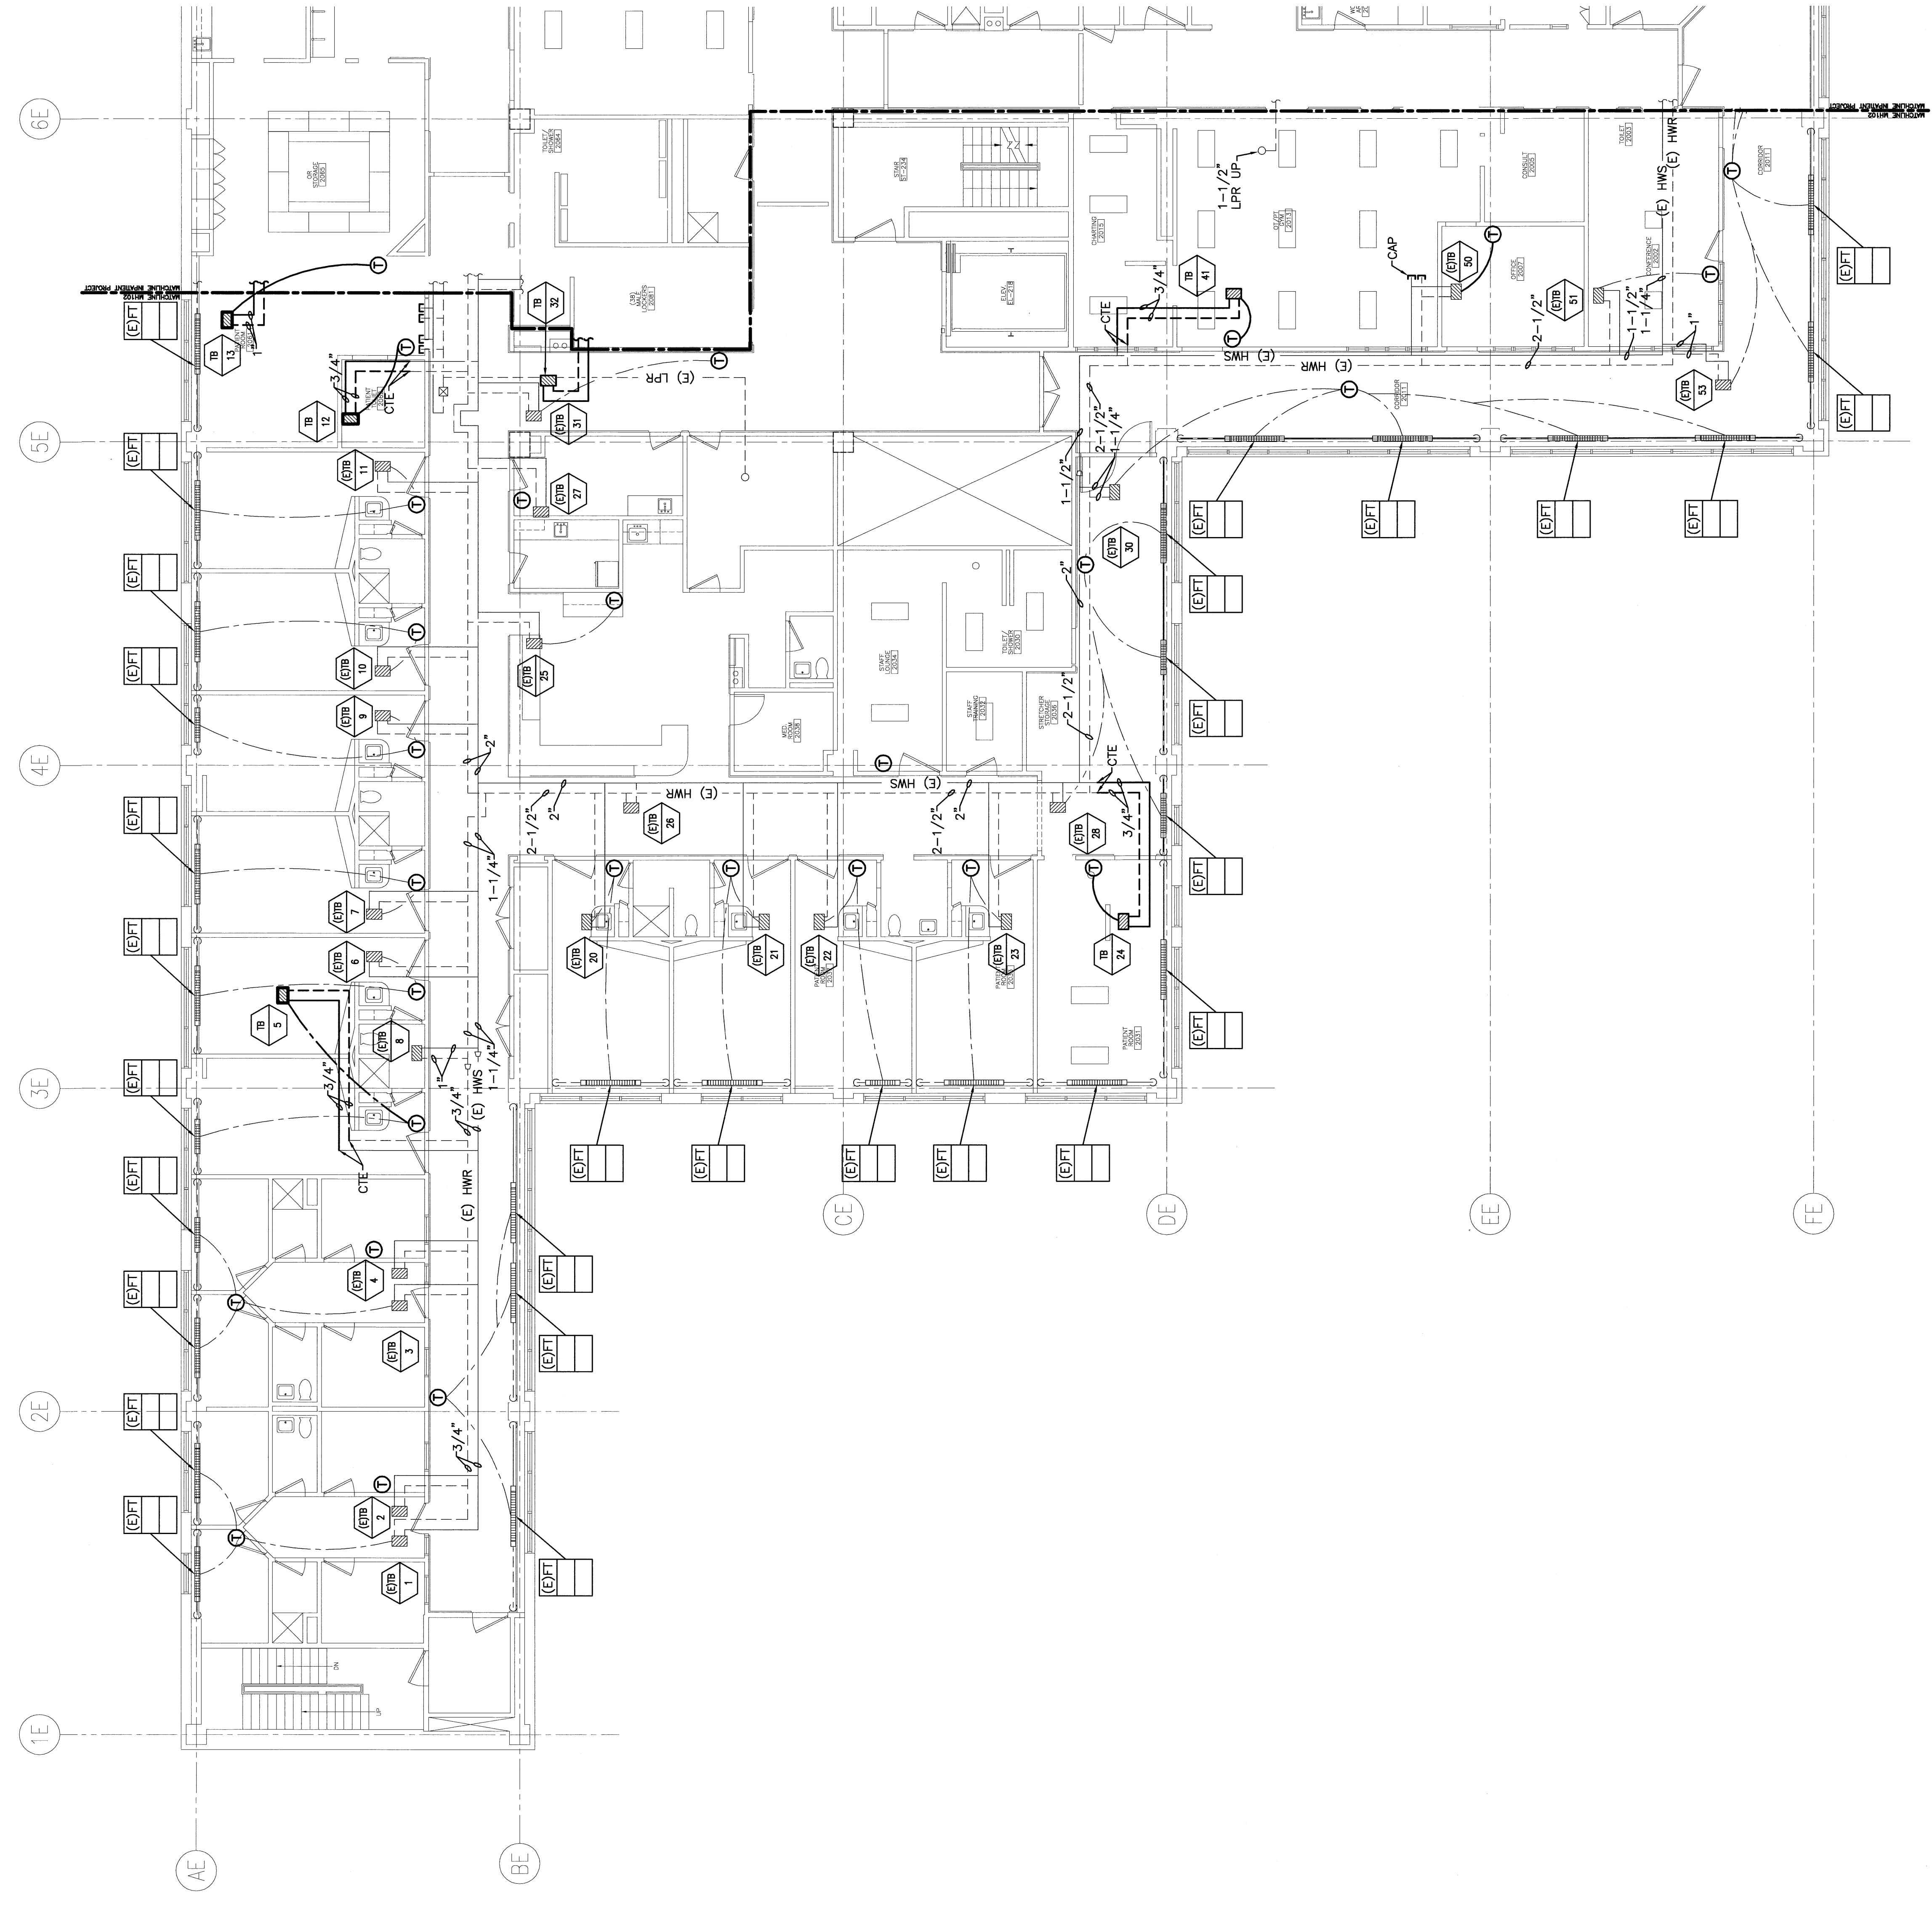

REV.	ISSUED FOR CONSTRUCTION	DESCRIPTION	DATE
0			9-12-08

ISSUED FOR CONSTRUCTION  
9-12-08

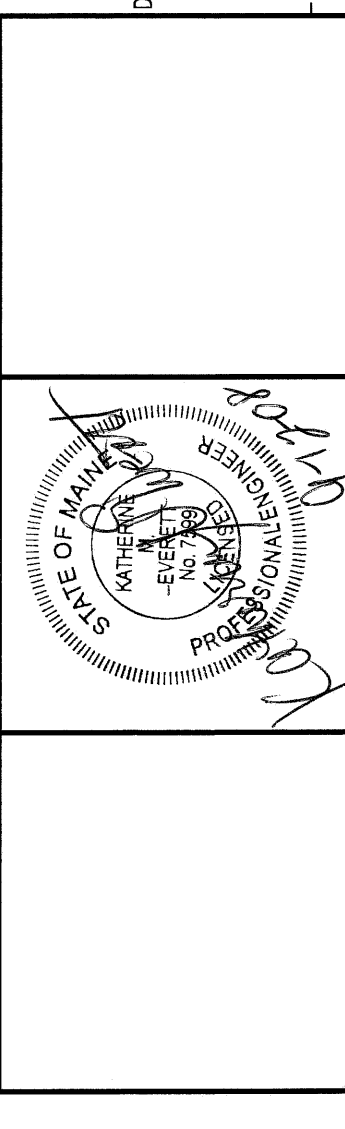

144 Fore Street, Box 818  
Portland, Maine 04104  
Tel: (207) 772-8800  
Fax: (207) 772-8805  
www.smrtinc.com



ARCHITECTURE  
ENGINEERING  
PLANNING  
INTERIOR DESIGN  
COMMISSIONING

MAINE MEDICAL CENTER - L.L. BEAN WING 2ND FLOOR  
INPATIENT SERVICES

PORTLAND, MAINE  
HVAC  
PIPING PLAN

SHEET TITLE	SCALE	DATE	GRAPHIC SCALE
PIPING PLAN	1/8" = 1'-0"	9-12-08	0'

PROJECT MANAGER	DIL	SHEET No.
		MP101

DATE OF RECORD	RME	SHEET No.
		MP101

SMRT CAD FILE	PROJECT No.
MP101-08059	08059