


**NOTE:**  
 1. SEE SHEET P-001 FOR LEGEND AND ABBREVIATIONS.

**KEYED NOTES:**  
 ① 1-1/2" V-RISE, 2" W-DN, 1/2" CW AND 1/2" HW-DROP.  
 ② 1-1/2" CW DROP, PROVIDE SHOCK ABSORBER WITH SHUT-OFF VALVE AT TOP OF DROP-ACCESSIBLE, 2" V-RISE, 4" S-DN.  
 ③ 1-1/2" V-RISE, 1/2" CW AND 1/2" HW-DROP, 2" W-RUN S-DN.  
 ④ OFFSET EXISTING 4" STACK INTO NEW CHASE WALL AS REQUIRED.  
 ⑤ TUB SHALL NOT BE PLUMBED.

**ISSUED FOR CONSTRUCTION**  
 9-12-08  
**DATE**

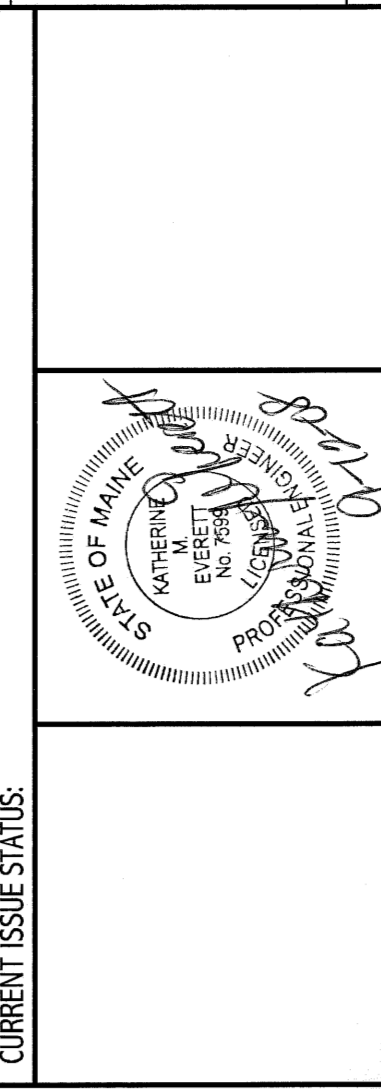

144 Fore Street, 2nd Floor  
 Portland, Maine 04103  
 Tel: (207) 776-1100  
 Fax: (207) 772-8079  
 www.smrtpc.com

**SMRTI**  
 ARCHITECTURE  
 ENGINEERING  
 PLANNING  
 INTERIOR DESIGN  
 COMMISSIONING

**MAINE MEDICAL CENTER - L.L. BEAN WING 2ND FLOOR**  
 INPATIENT SERVICES  
 PORTLAND, MAINE

**PLUMBING AND MED GAS**  
**PART PLAN**

SCALE:	1/4" = 1'-0"	DATE:	9-12-08
PROJECT MANAGER:	CPD	GRAPHIC SCALE:	0' 1'
DATE OF RECORD:	MDR/BBG	CHE	SHEET No.
SMRTI CAD FILE:	PL102-08099	PROJECT No.:	08099
PROJECT No.:	08099		

**A8 PARTIAL FLOOR PLAN**

1/4" = 1'-0"

**A1 \***