

NOTE:


1. SEE SHEET E-001 FOR LEGEND AND GENERAL NOTES.
2. BRANCH CIRCUIT NUMBERS INDICATED ARE FOR CIRCUIT ORGANIZATION ONLY UNLESS SPECIFICALLY NOTED OTHERWISE. ACTUAL BRANCH CIRCUIT NUMBERS SHALL BE DETERMINED BY THE ELECTRICAL CONTRACTOR AFTER DEMOLITION AND DOCUMENTED WITH AS-BUILT DRAWINGS. (EX. LCP-2-1-1 EQUALS THE FIRST AVAILABLE SPARE CIRCUIT IN PANELBOARD LCP-2-1).

KEYED NOTE:

- ① MOUNT 42" AFT TO CENTER OF DEVICE
- ② CONNECT TO EXISTING NORMAL POWER BRANCH CIRCUIT SERVING THE SPACE
- ③ CONNECT TO EXISTING CRITICAL POWER BRANCH CIRCUIT SERVING SPACE.
- ④ CHANGE EXISTING RECEPTACLE DEVICE TO GFCI.
- ⑤ MOUNT 6" ABOVE COUNTER TO CENTER OF DEVICE.
- ⑥ COORDINATE MOUNTING HEIGHT W/ ARCHITECT AND OWNER

REV.	DESCRIPTION	DATE
0	ISSUED FOR CONSTRUCTION	9-12-08

ISSUED FOR CONSTRUCTION
9-12-08

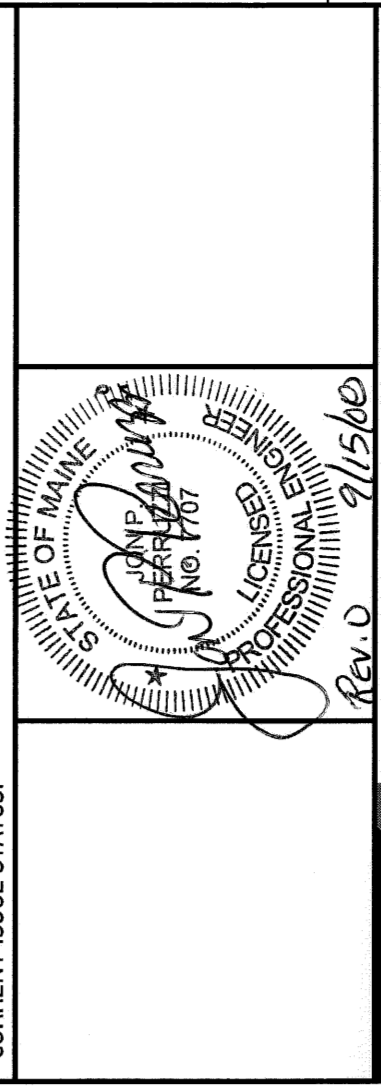

SMRTI
ARCHITECTURE
ENGINEERING
PLANNING
INTERIOR DESIGN
COMMISSIONING

144 Free Street, 6th Fl.
Portland, Maine 04104
Tel: (207) 772-3846
Fax: (207) 772-0070
www.smrti.com

MAINE MEDICAL CENTER - LL BEAN WING 2ND FLOOR
INPATIENT SERVICES
PORTLAND, MAINE

POWER	
PARTIAL FLOOR PLAN SHEET 1	
SHEET TITLE	DATE: 9-12-08
SCALE: 1/4" = 1'-0"	GRAPHIC SCALE: 0'
PROJECT MANAGER: CJP	DATE: 9-12-08
DATE OF RECORDING: JPT	SHEET NO.: EP101
SMRTI CAD FILE: EP101-08099	PROJECT No.: 08099

A1 PARTIAL FLOOR PLAN

1/4"=1'-0"