
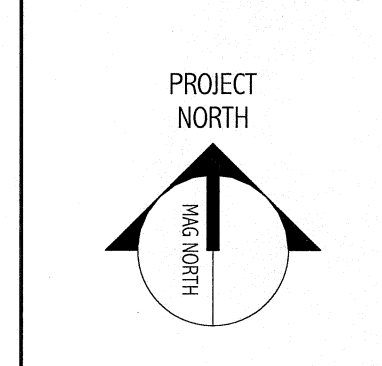
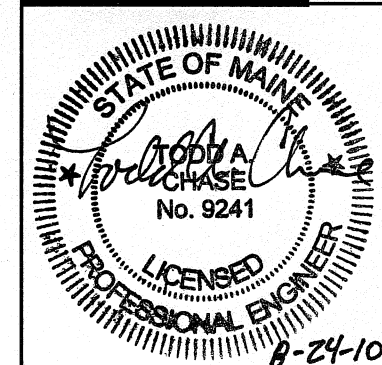


144 Fox Street P.O. Box 618
 Portland, Maine 04104
 Tel: (207) 772-3846
 Fax: (207) 772-1070
 www.lummc.com

ARCHITECTURE
 ENGINEERING
 PLANNING
 INTERIOR DESIGN
 COMMISSIONING

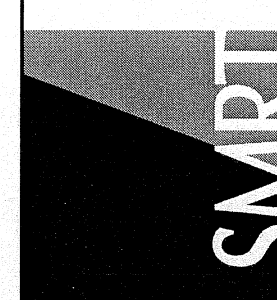

Bramhall Radiology
FLUORO RENOVATIONS
 PORTLAND, ME

ISSUED FOR CONSTRUCTION
 08.24.10

CURRENT ISSUE STATUS


REV	DESCRIPTION	DATE
0	ISSUED FOR CONSTRUCTION	8-24-10

GRAPHIC SCALE:
 0" = 1"

SCALE: 1/8" = 1'-0"
 PROJECT MANAGER: DIV
 ICDRAWN BY: KPB
 A/E OF RECORD: TAC
 PROJECT NO: 09022-02
 DATE: 08.24.10

SHEET TITLE:
**FLUORO MECHANICAL
 DUCTWORK PLAN**

SHEET No:
MH 101

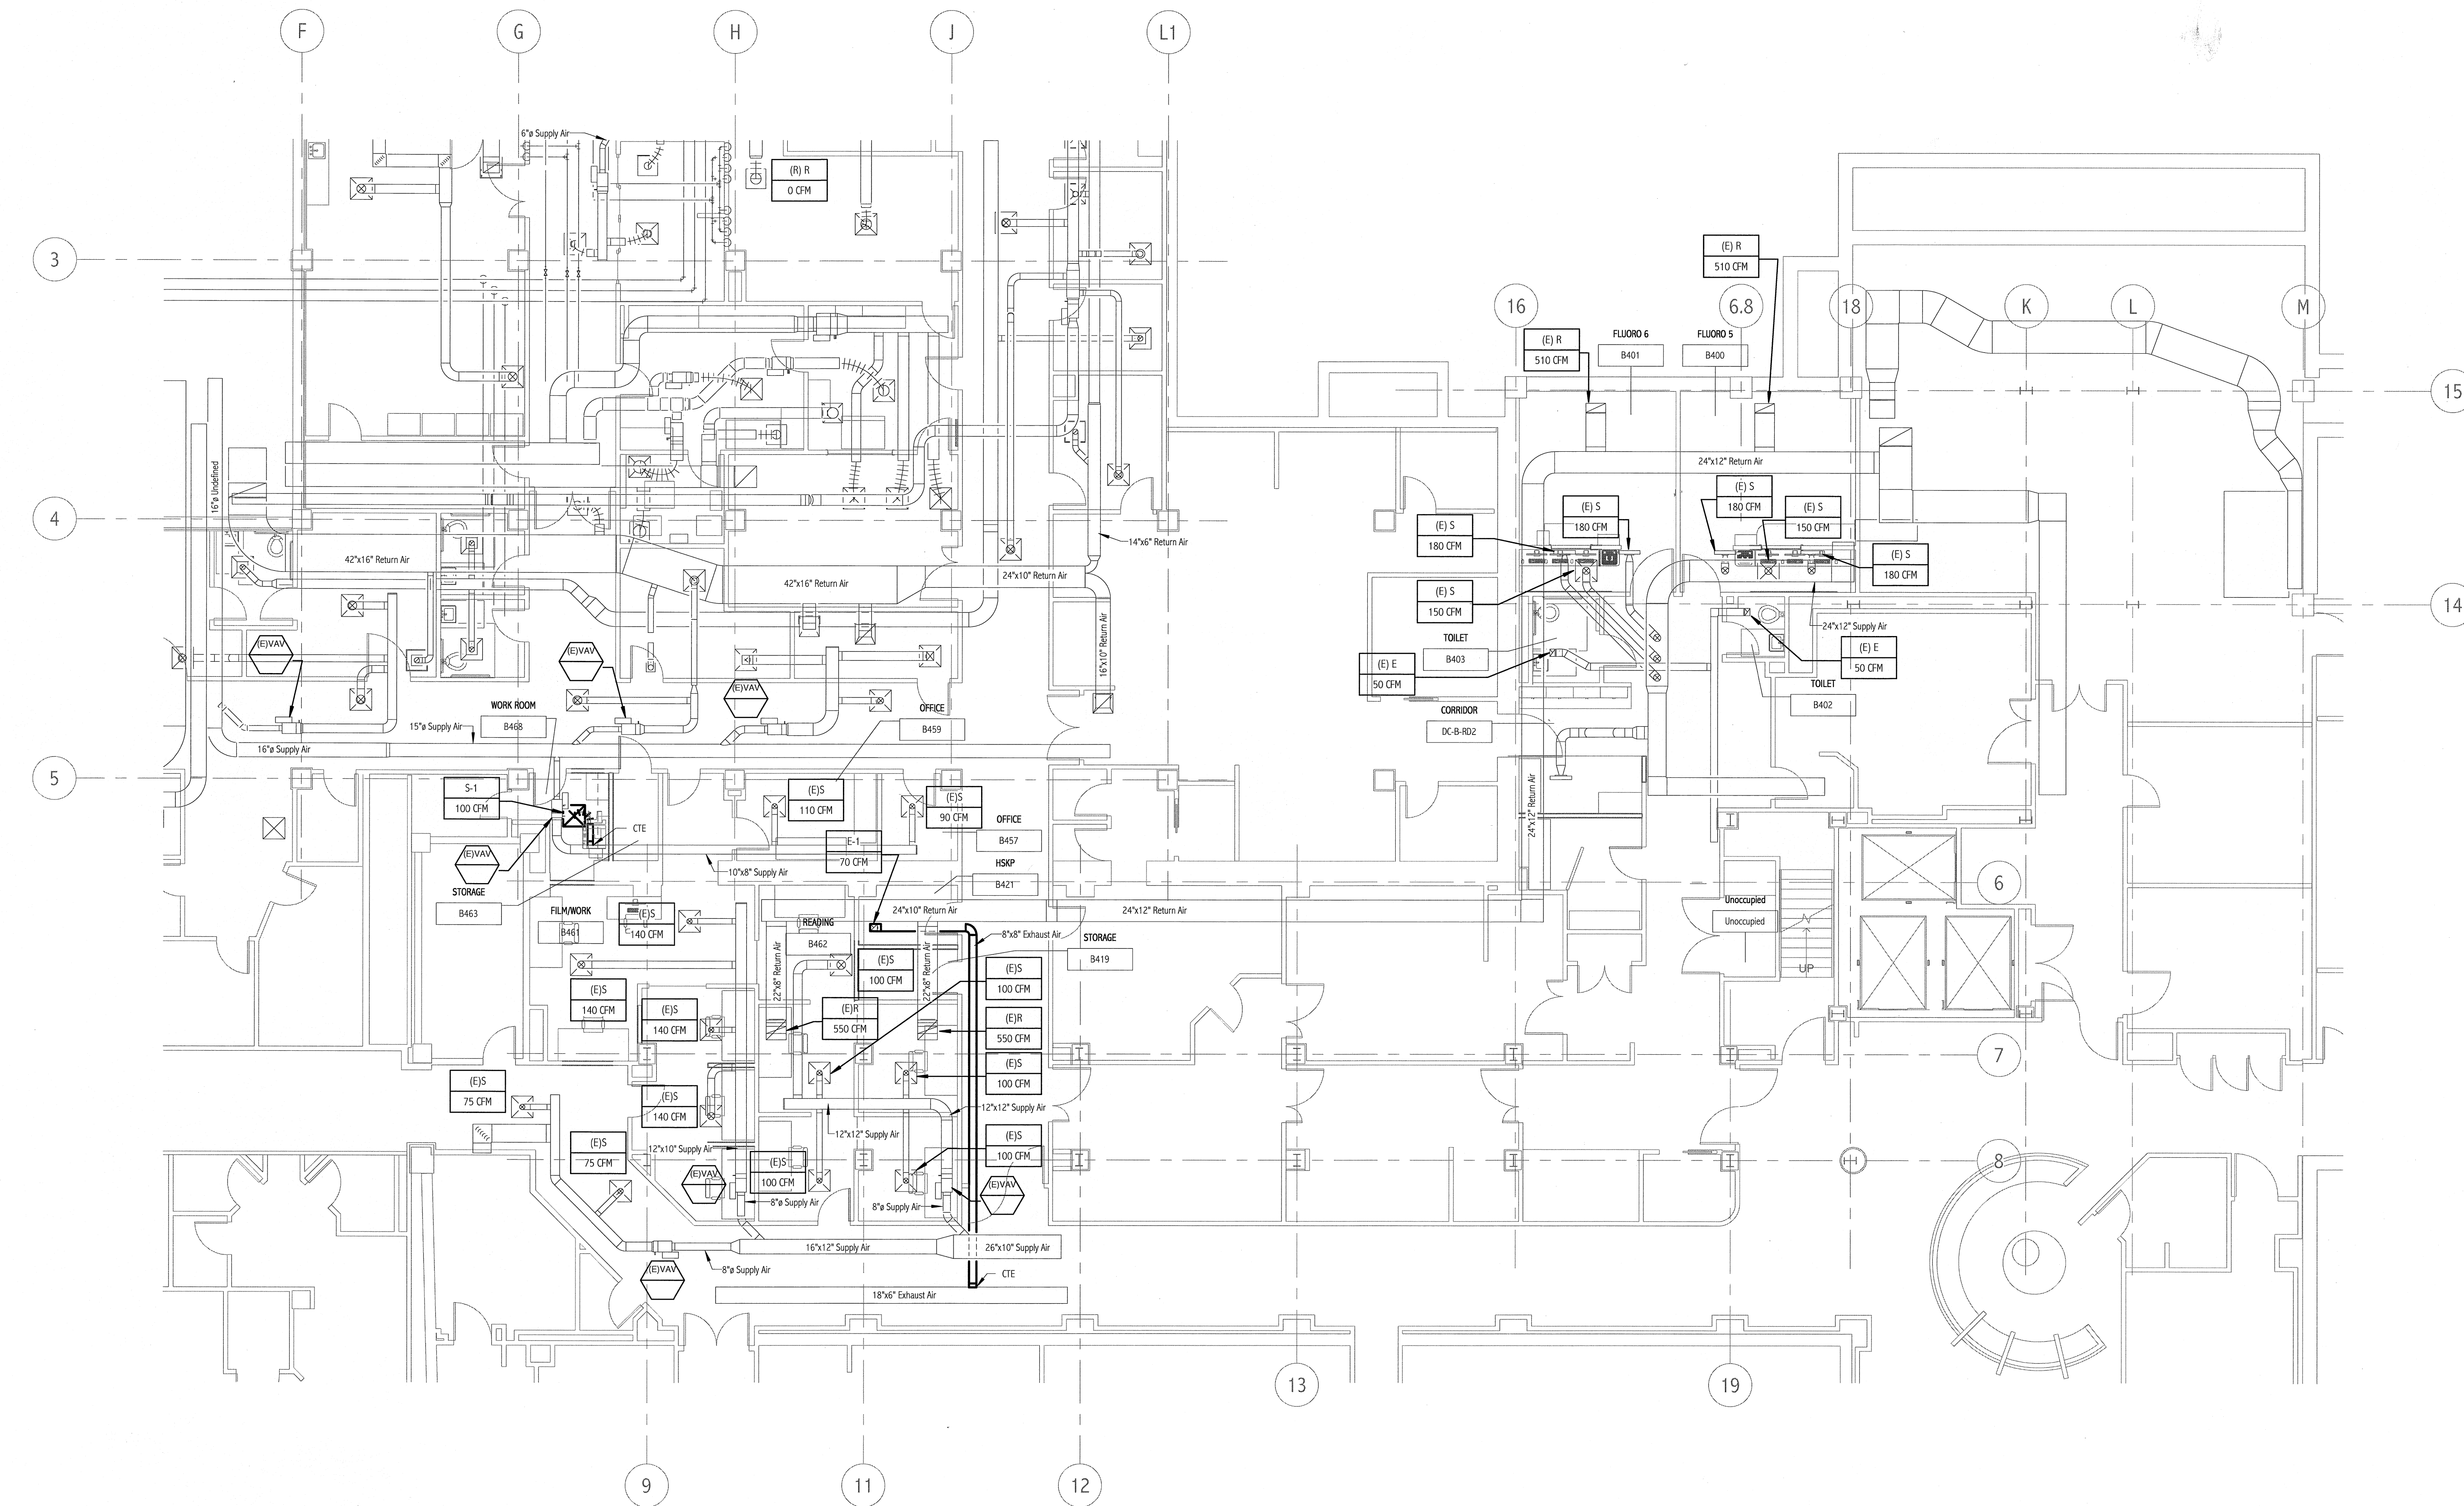

1 FLUORO HVAC DUCTWORK PLAN
 1/8" = 1'-0"