


**NOTE:**

1. SEE M-001 FOR LEGEND, ABBREVIATIONS AND GENERAL NOTES.

**KEYED NOTES:**



① CONNECT 1" CHWSR TO EXISTING CHILLED WATER SYSTEM. VERIFY EXACT LOCATION IN FIELD.

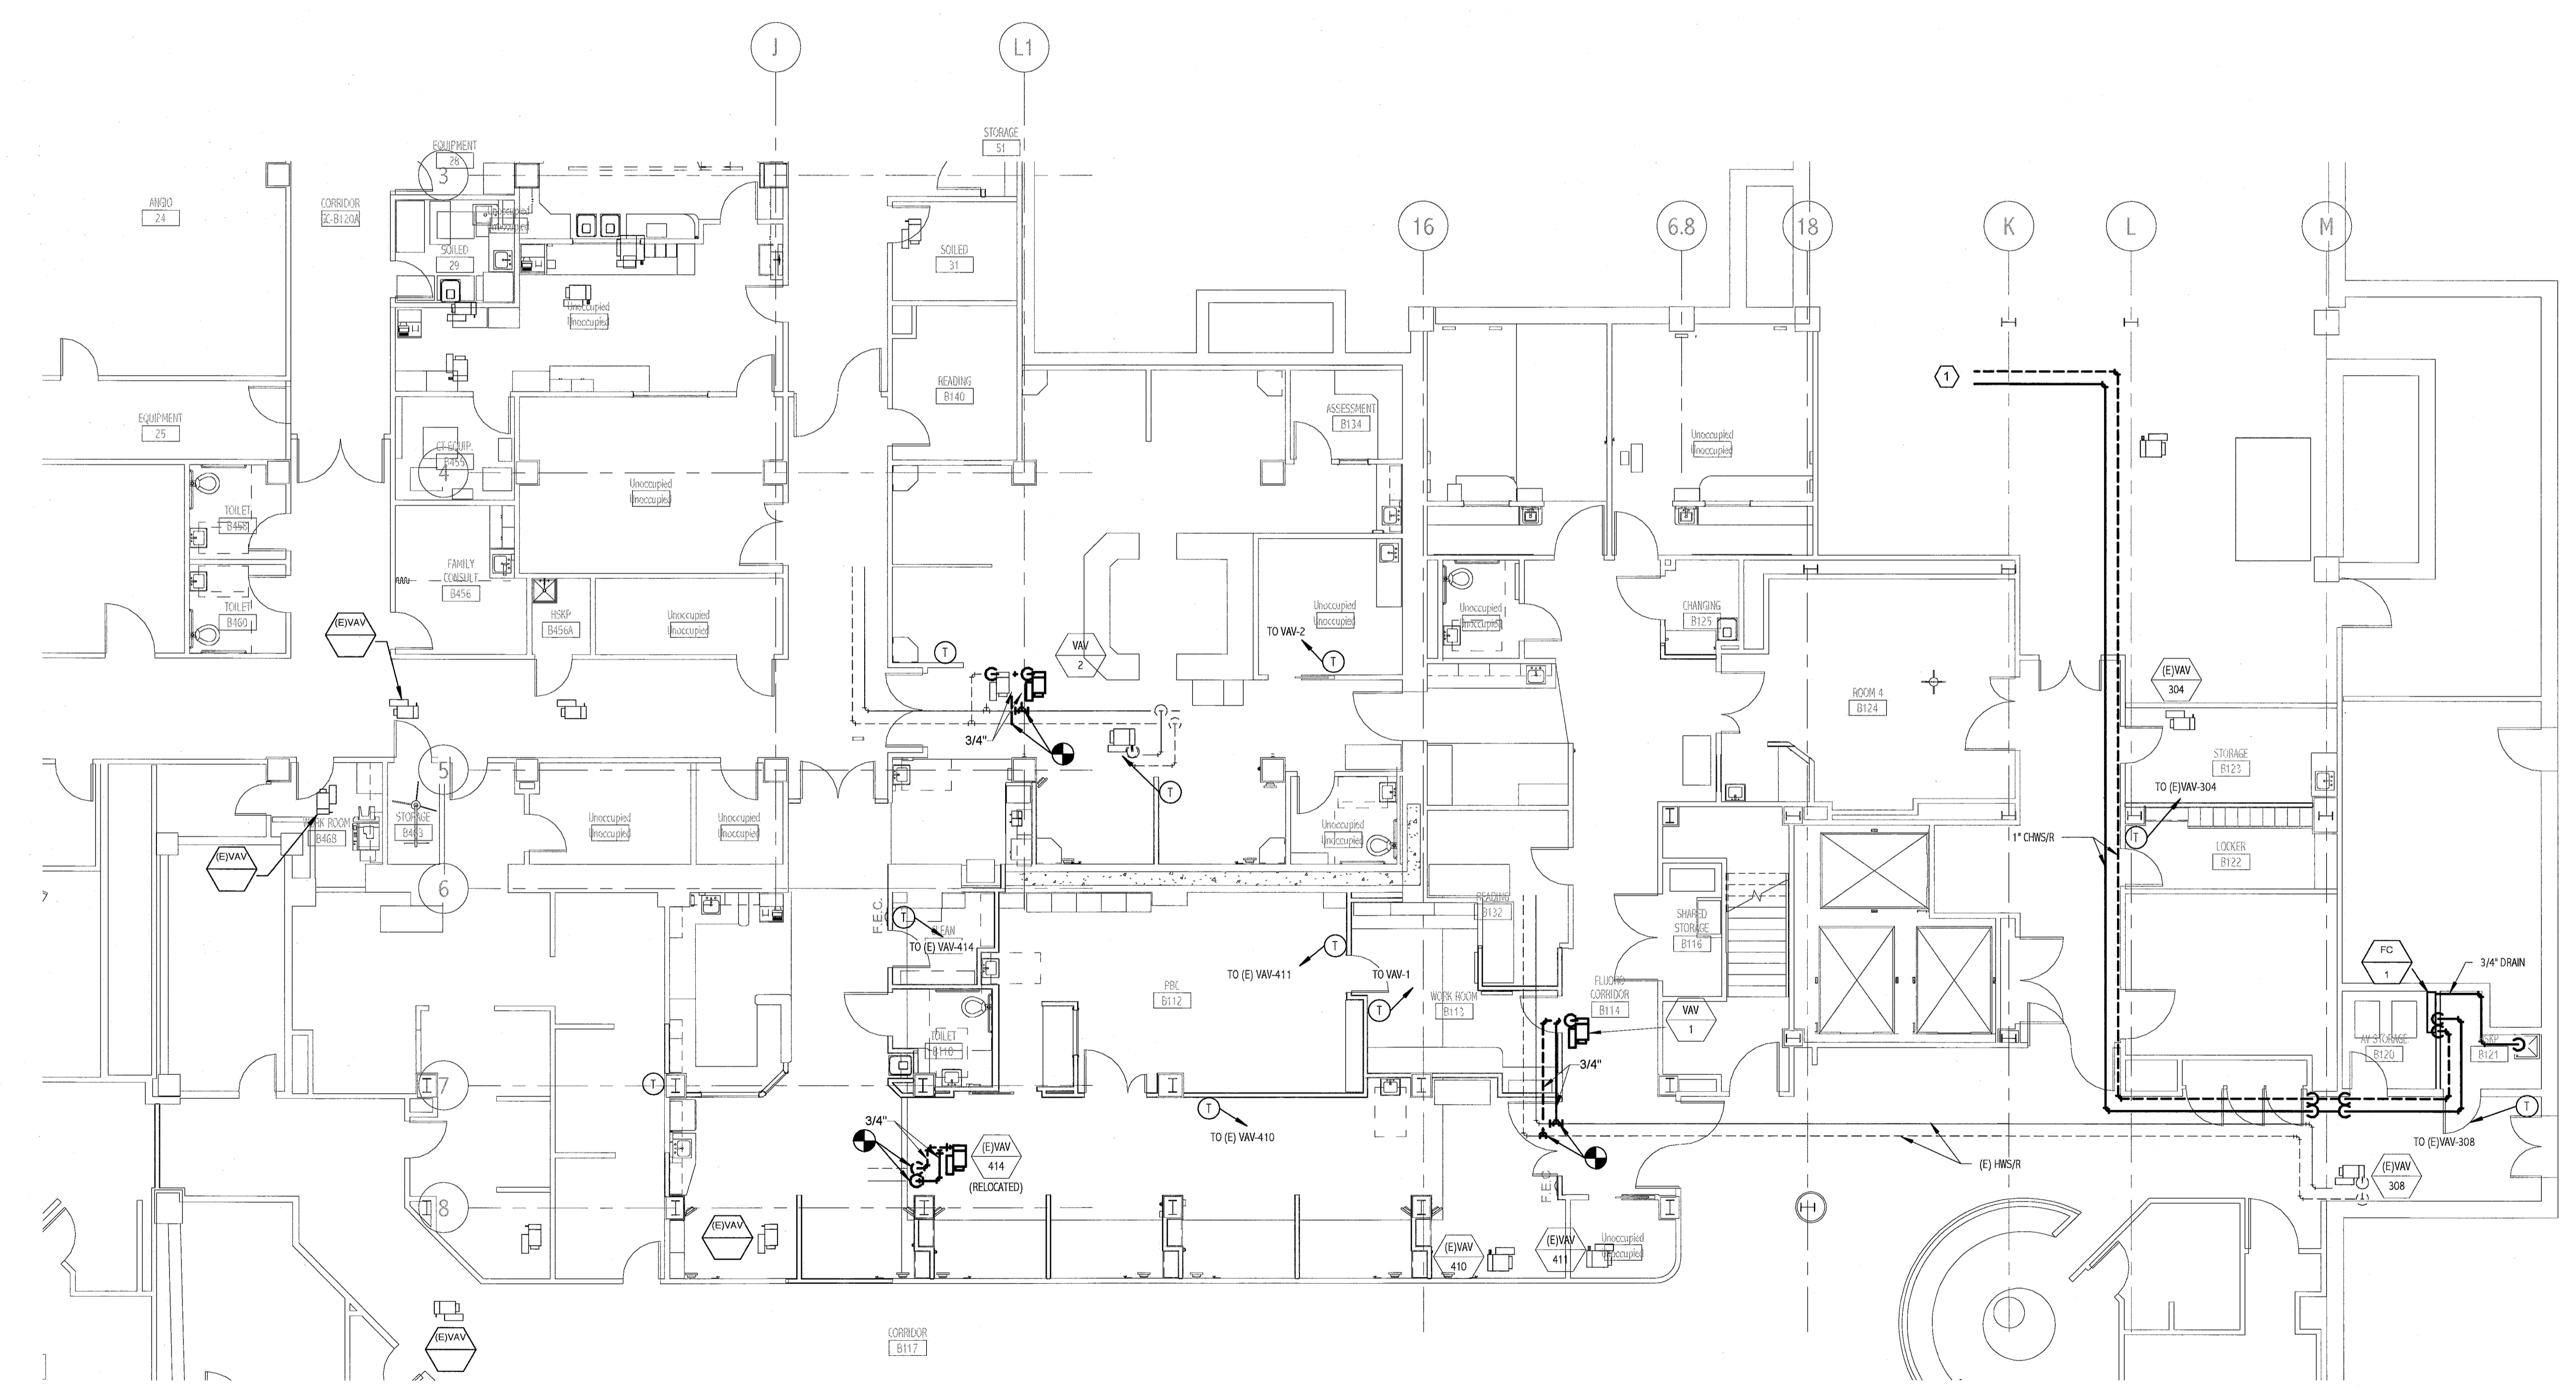

① BASEMENT LEVEL PIPING PLAN  
1/8" = 1'-0"

144 Free Street/P.O. Box 618  
Portland, Maine 04104  
Tel: (207) 773-3846  
Fax: (207) 773-1070  
www.smartinc.com

ARCHITECTURE  
ENGINEERING  
PLANNING  
INTERIOR DESIGN  
COMMISSIONING

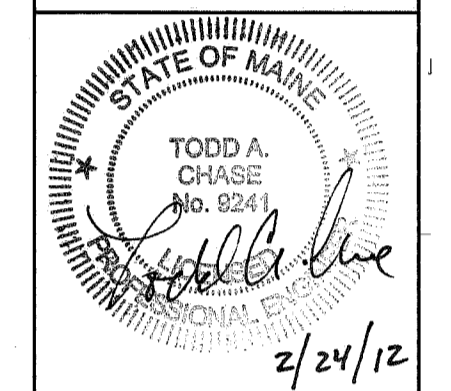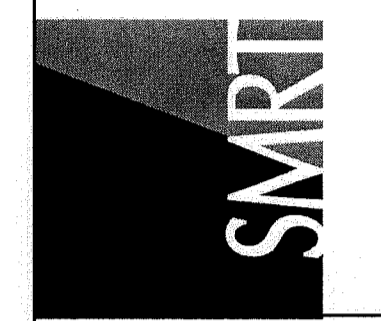

MAINE MEDICAL CENTER  
HOLDING, RADCU & PBC RENOVATION  
ISSUED FOR CONSTRUCTION  
02.24.12

REV	DATE	DESCRIPTION
0	2.24.12	ISSUED FOR CONSTRUCTION

GRAPHIC SCALE:  
0" 1"  
SCALE: 1/8" = 1'-0"  
PROJECT MANAGER: DIV  
I.C./DRAWN BY: BAL  
A/E OF RECORD: TAC  
PROJECT NO: 11063  
DATE: 02.24.12

SHEET TITLE:  
BASEMENT LEVEL  
HVAC PIPING PLAN

SHEET NO.  
MP101