


Legend

Room #	Room Name
4301	Storage
4301A	Staff Bathroom
4307	Environmental Service
4309	Kitchen
4315	Electrical Closet
4317	Nursing Station
4319	Charting
4321	Telecom
4323	Meds Room
4323A	Nurse Call Closet
4325	Clean Utility
4328	Waiting
4329	Consult
4329A	Closet
4330	H.C. Bathroom
4401	H.C. Shower Room
4402	Soiled Utility
4403	Head Nurse
4404	Shower Room
4405	Office
4406	Staff Room
4408	Vacant
4410	" "
4412	" "
4414	" "
4422	" "


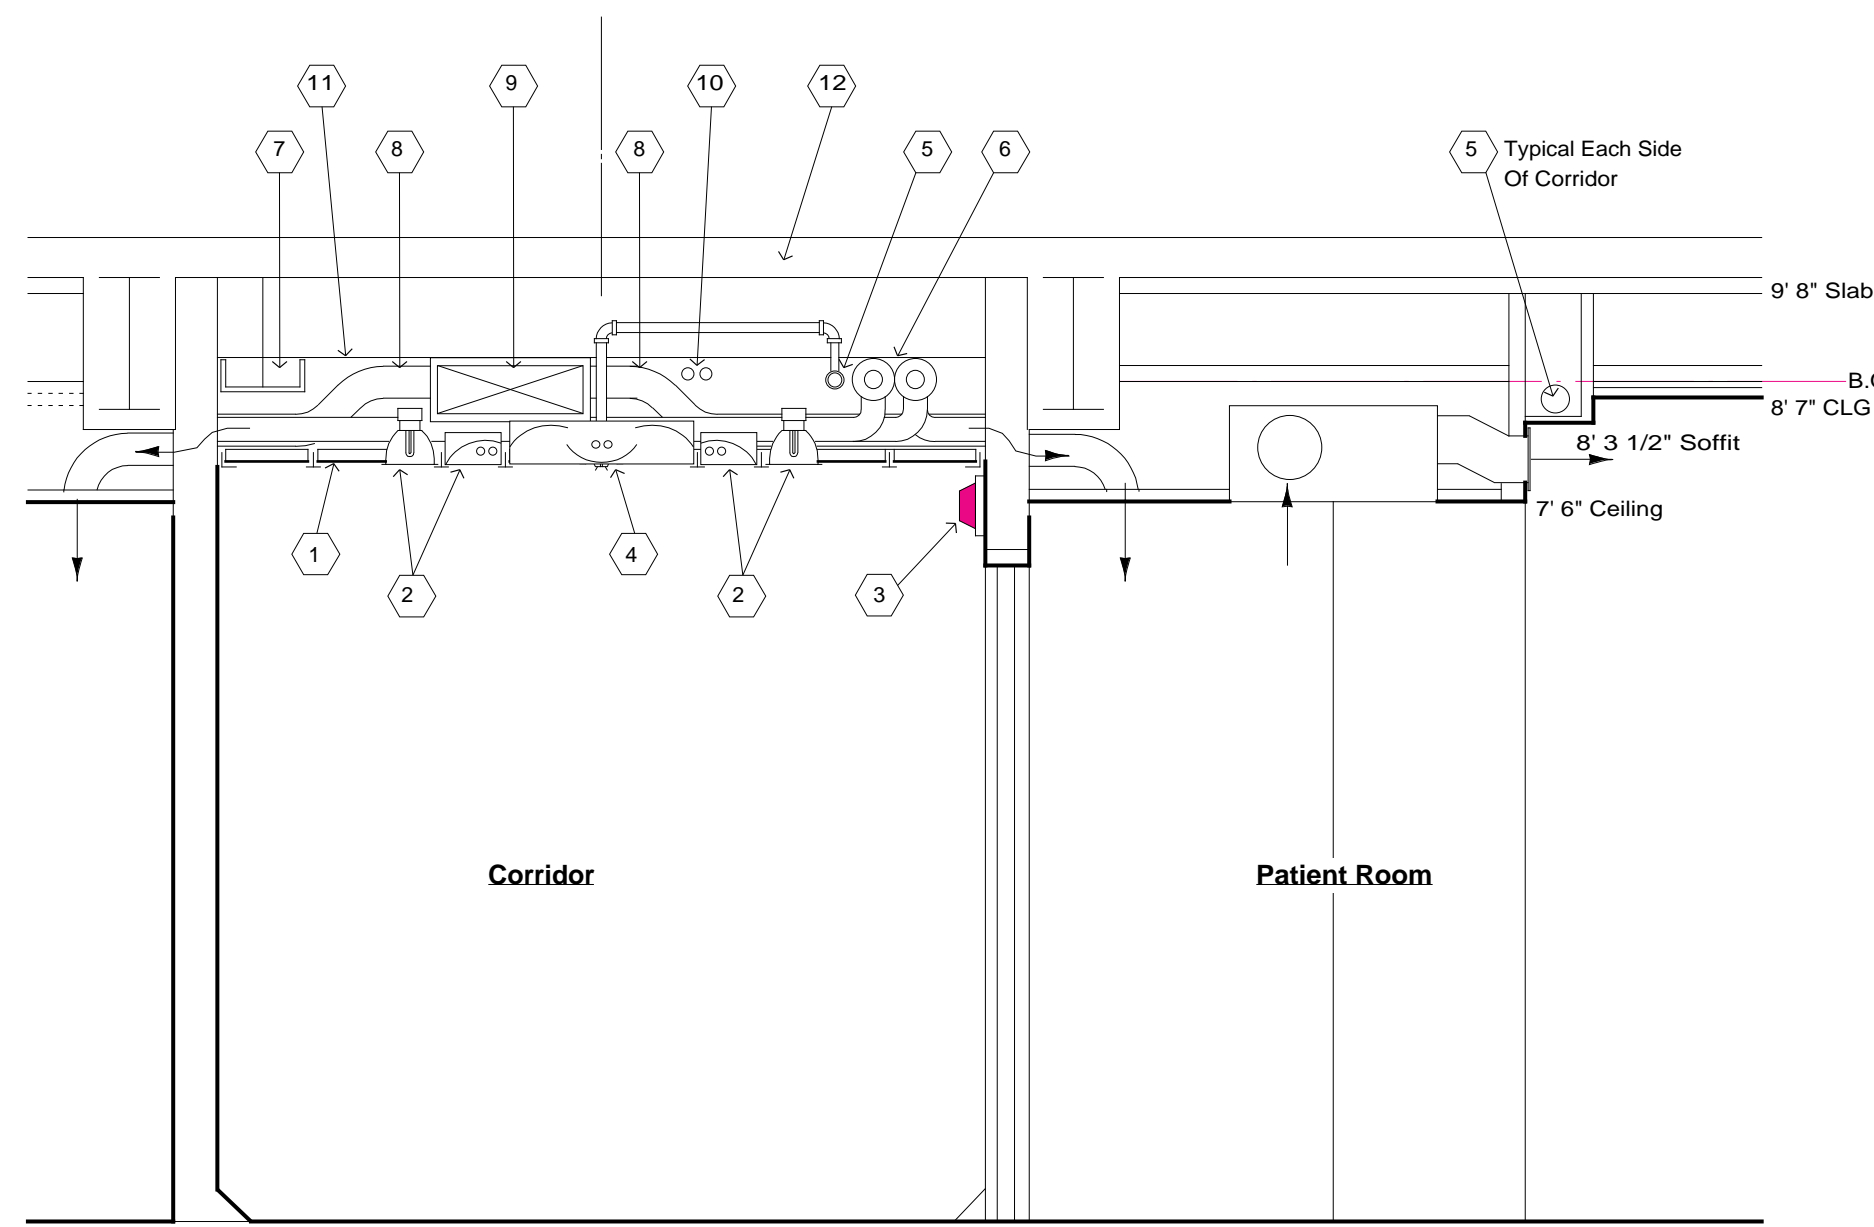


Corridor Cross Section

1/2" = 1' - 0"


Corridor Section Key Notes

- 1 ACT Ceiling
- 2 Light Fixture Where Shown
- 3 Nurse Call Annunciator
- 4 Recessed Sprinkler Head
- 5 Sprinkler Main
- 6 Chilled Water Supply and Return
- 7 Telecom Cable Tray
- 8 Proposed Duct Branch
- 9 Proposed Duct Main
- 10 Vacuum and Oxygen Mains
- 11 Bottom of Conc Encased Steel Beams
- 12 5" Conc Slab

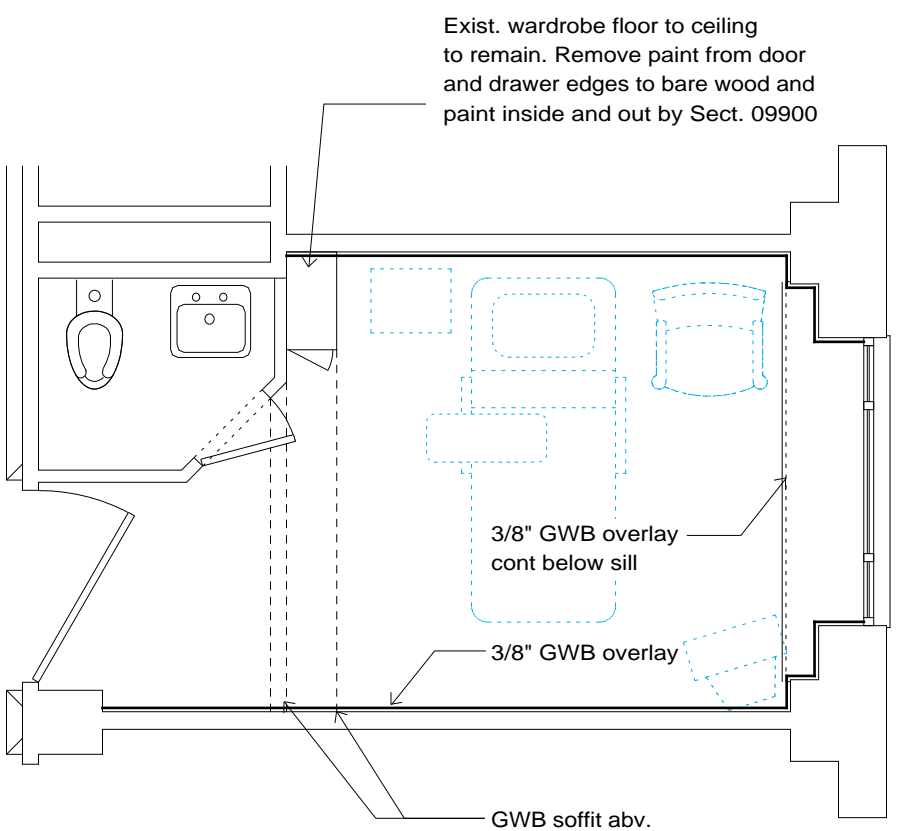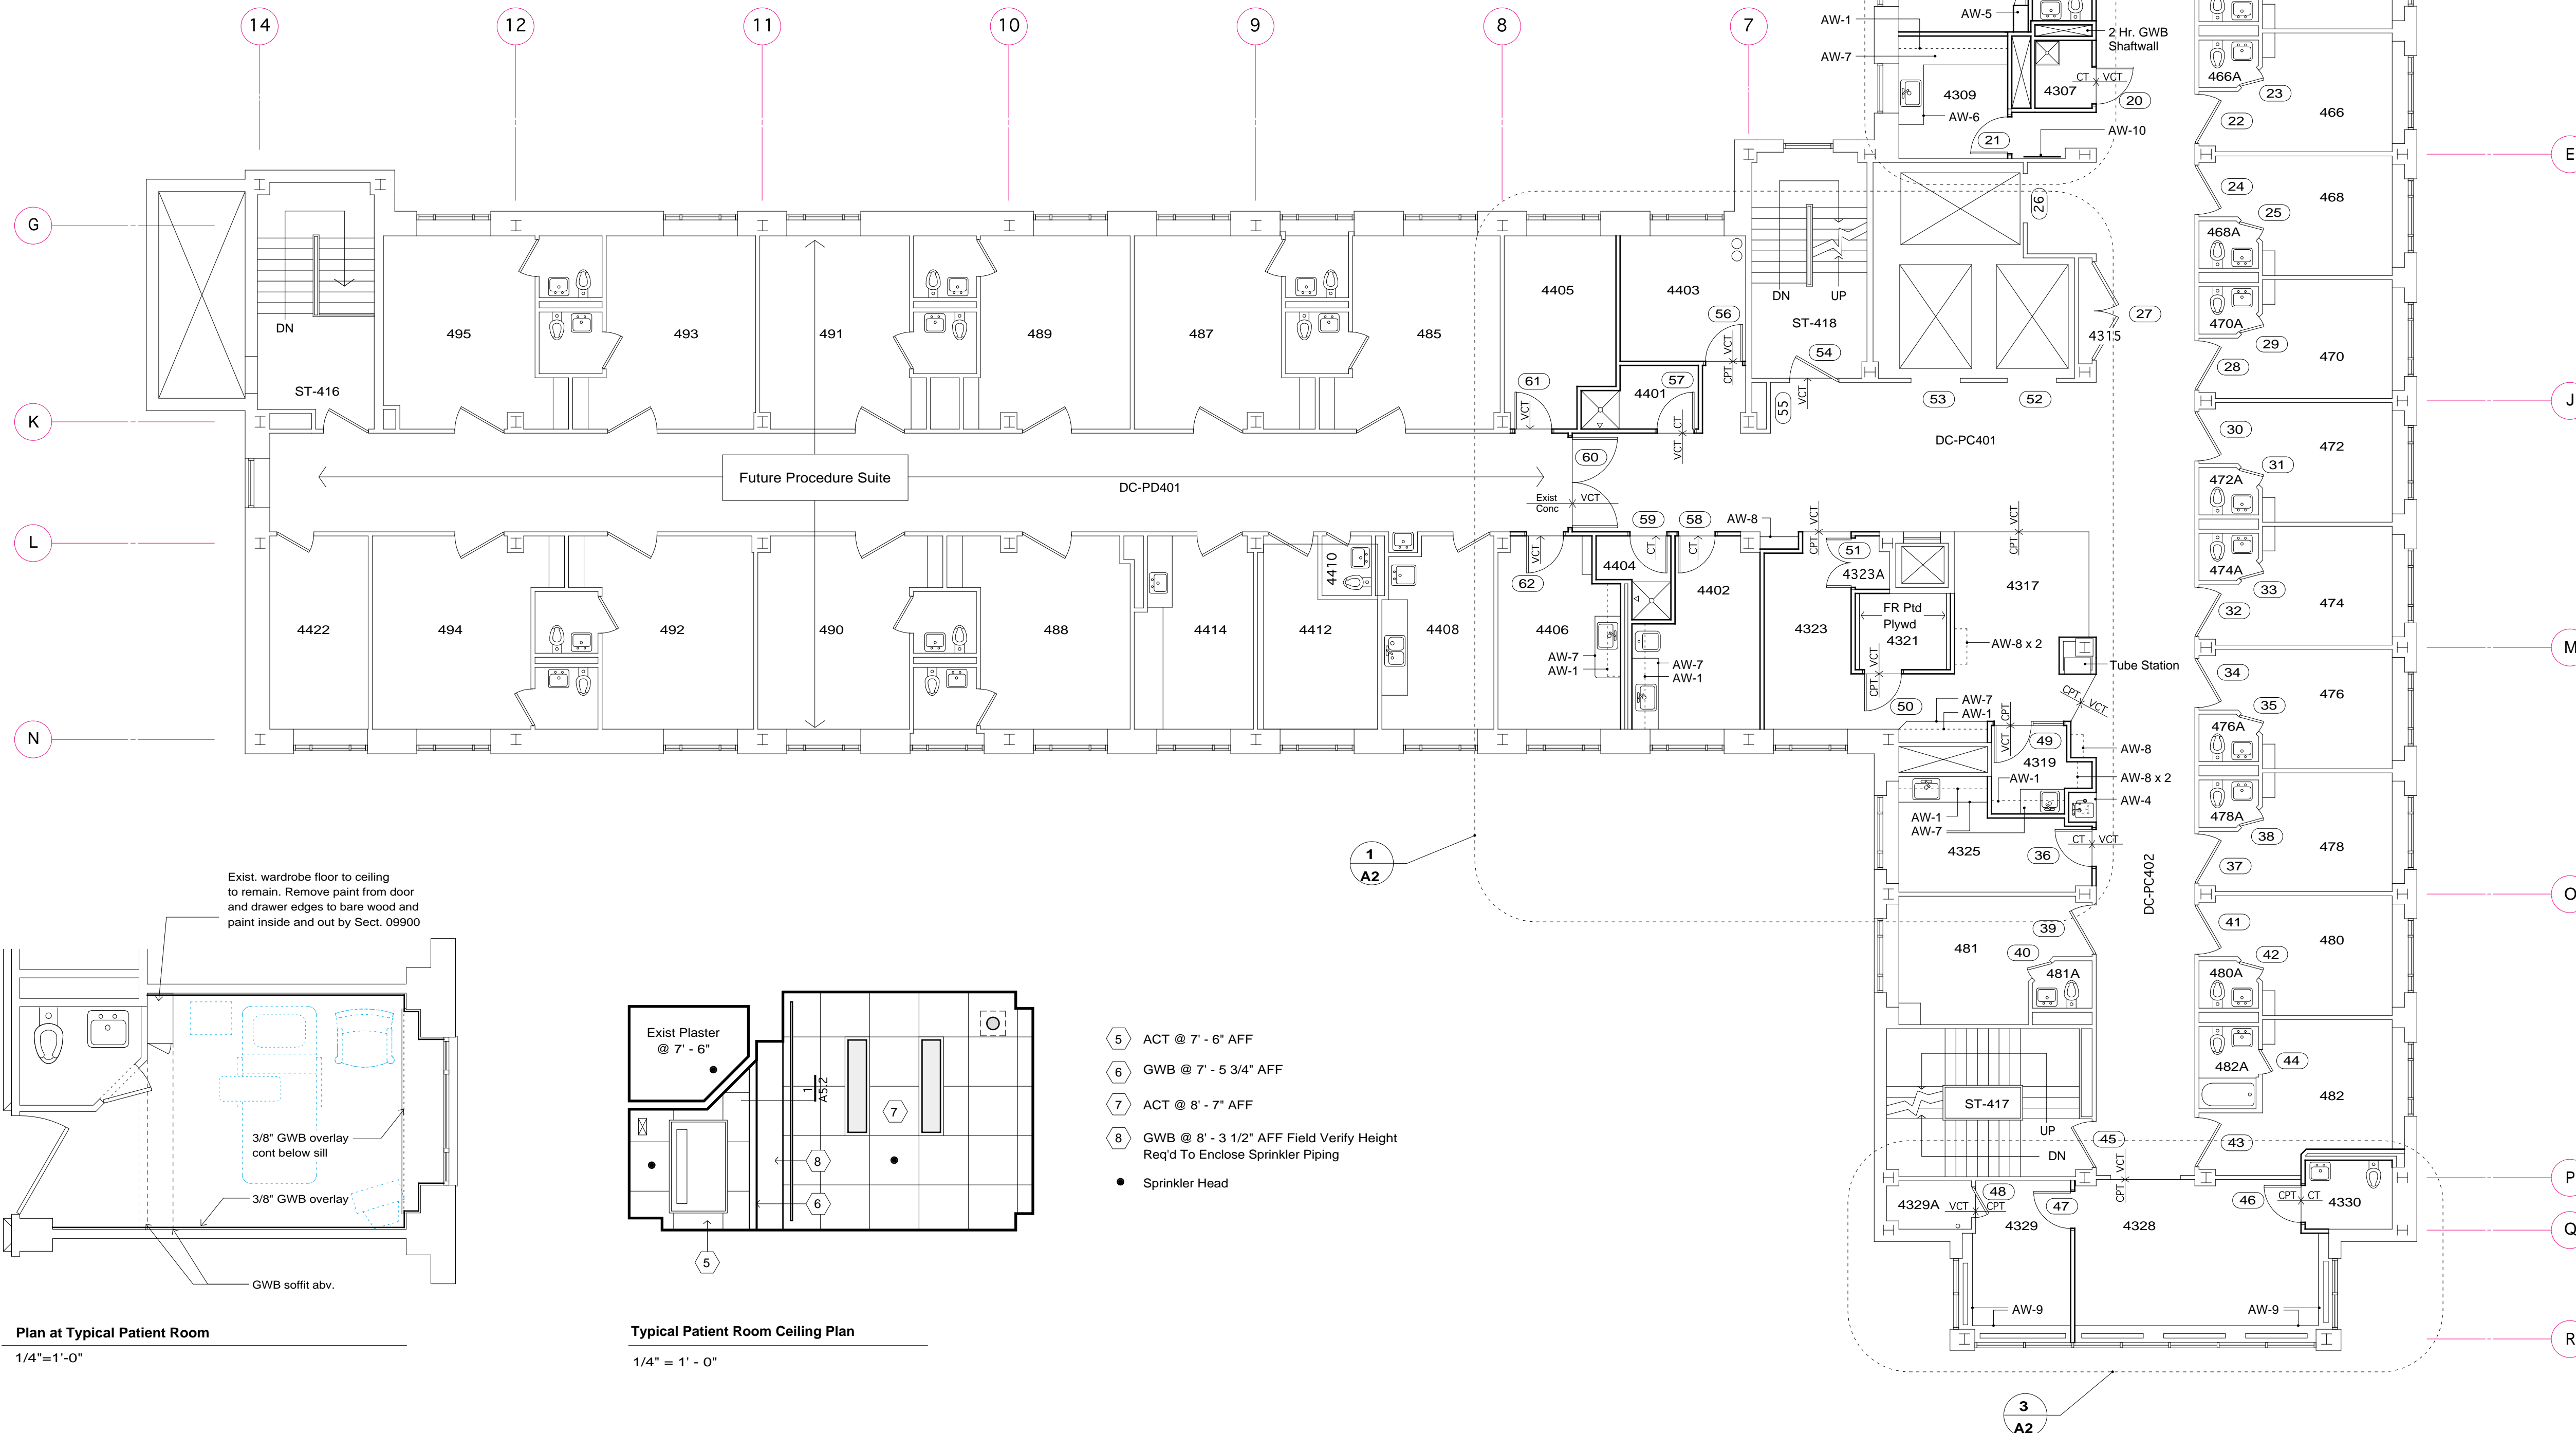

Plan at Typical Patient Room


1/4" = 1' - 0"

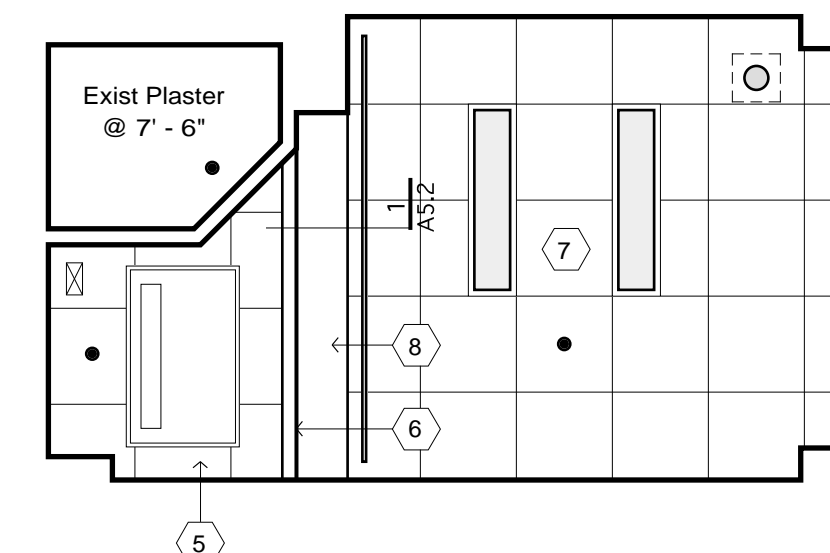

Typical Patient Room Ceiling Plan

1/4" = 1' - 0"

- 5 ACT @ 7' - 6" AFF
- 6 GWB @ 7' - 5 3/4" AFF
- 7 ACT @ 8' - 7" AFF
- 8 GWB @ 8' - 3 1/2" AFF Field Verify Height Req'd To Enclose Sprinkler Piping
- Sprinkler Head

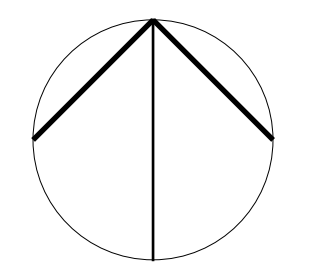

**P 4
Renovation**

Pavilion C
Fourth Floor

Maine Medical Center
Portland, Maine
04102

Architect
Winton Scott Architects
Portland, Maine

Mechanical Engineering
Mechanical Systems Engineers
Yarmouth, Maine

Electrical Engineering
Ames & Hewett
Winthrop, Maine

Floor Plan

A 1

Scale: 1/8" = 1' - 0"

October 30, 2001