

LIGHT FIXTURE SCHEDULE


TYPE	DESCRIPTION	MFR.	LAMPS	MOUNTING	NOTES
A	6" ROUND APERTURE HIGH OUTPUT DOWNLIGHT WITH 45 DEGREE FLOOD DISTRIBUTION AND CLEAR ALZAK REFLECTOR. 120V/277V	PRESCOLITE D6LED3 SERIES	15W LED 3500K	CEILING RECESSED	PROVIDE WITH LUTRON ECOSYSTEM DIMMING DRIVER FOR DIMMING DOWN TO 1%.
B	2x2 DIRECT/INDIRECT FLUORESCENT WITH METAL PERFORATE OVERLAY 120V/277V	COLUMBIA STE22 SERIES	3-F24T5HO 3500K	CEILING RECESSED	PROVIDE FIXTURE WITH TWO BALLASTS TO ALLOW DUAL LEVEL SWITCHING.
C	42" LOW PROFILE UNDER CABINET LIGHT. 120V/277V	COLUMBIA UCS42 SERIES	2-F13T5 3500K	UNDER CABINET	
D	2x2 SPECIFICATION GRADE RECESSED TROFFER W/PATTERN A12 ACRYLIC LENS. 120V/277V	EXISTING TO BE RELOCATED	2-F31U6T8 3500K	CEILING RECESSED	
E	EMERGENCY EXIT SIGN W/ WHITE THERMOPLASTIC HOUSING AND RED LETTERS.	DUAL LITE LX SERIES	LED	SURFACE CEILING	

NOTE:

1. SEE SHEET E-001 FOR LEGEND AND GENERAL NOTES.


KEYED NOTES:

- ① SEE DRAWING ED101 FOR EXISTING LOCATION OF FIRE ALARM NOTIFICATION DEVICES AND PULL STATION THAT WILL BE RELOCATED AT LOCATIONS SHOWN. EXTEND EXISTING WIRING AS REQUIRED TO ACCOMMODATE NEW DEVICE LOCATION.
- ② RELOCATE LIGHT FIXTURES AND SWITCH AS REQUIRED TO ACCOMMODATE NEW SIZE OF POWER CONDITIONER ROOM. MODIFY EXISTING WIRING AS REQUIRED.
- ③ NEW EXIT SIGN TO BE FED FROM SAME BRANCH CIRCUIT AS EXISTING CORRIDOR EMERGENCY LIGHTING ON THE LINE SIDE OF ANY SWITCHING.

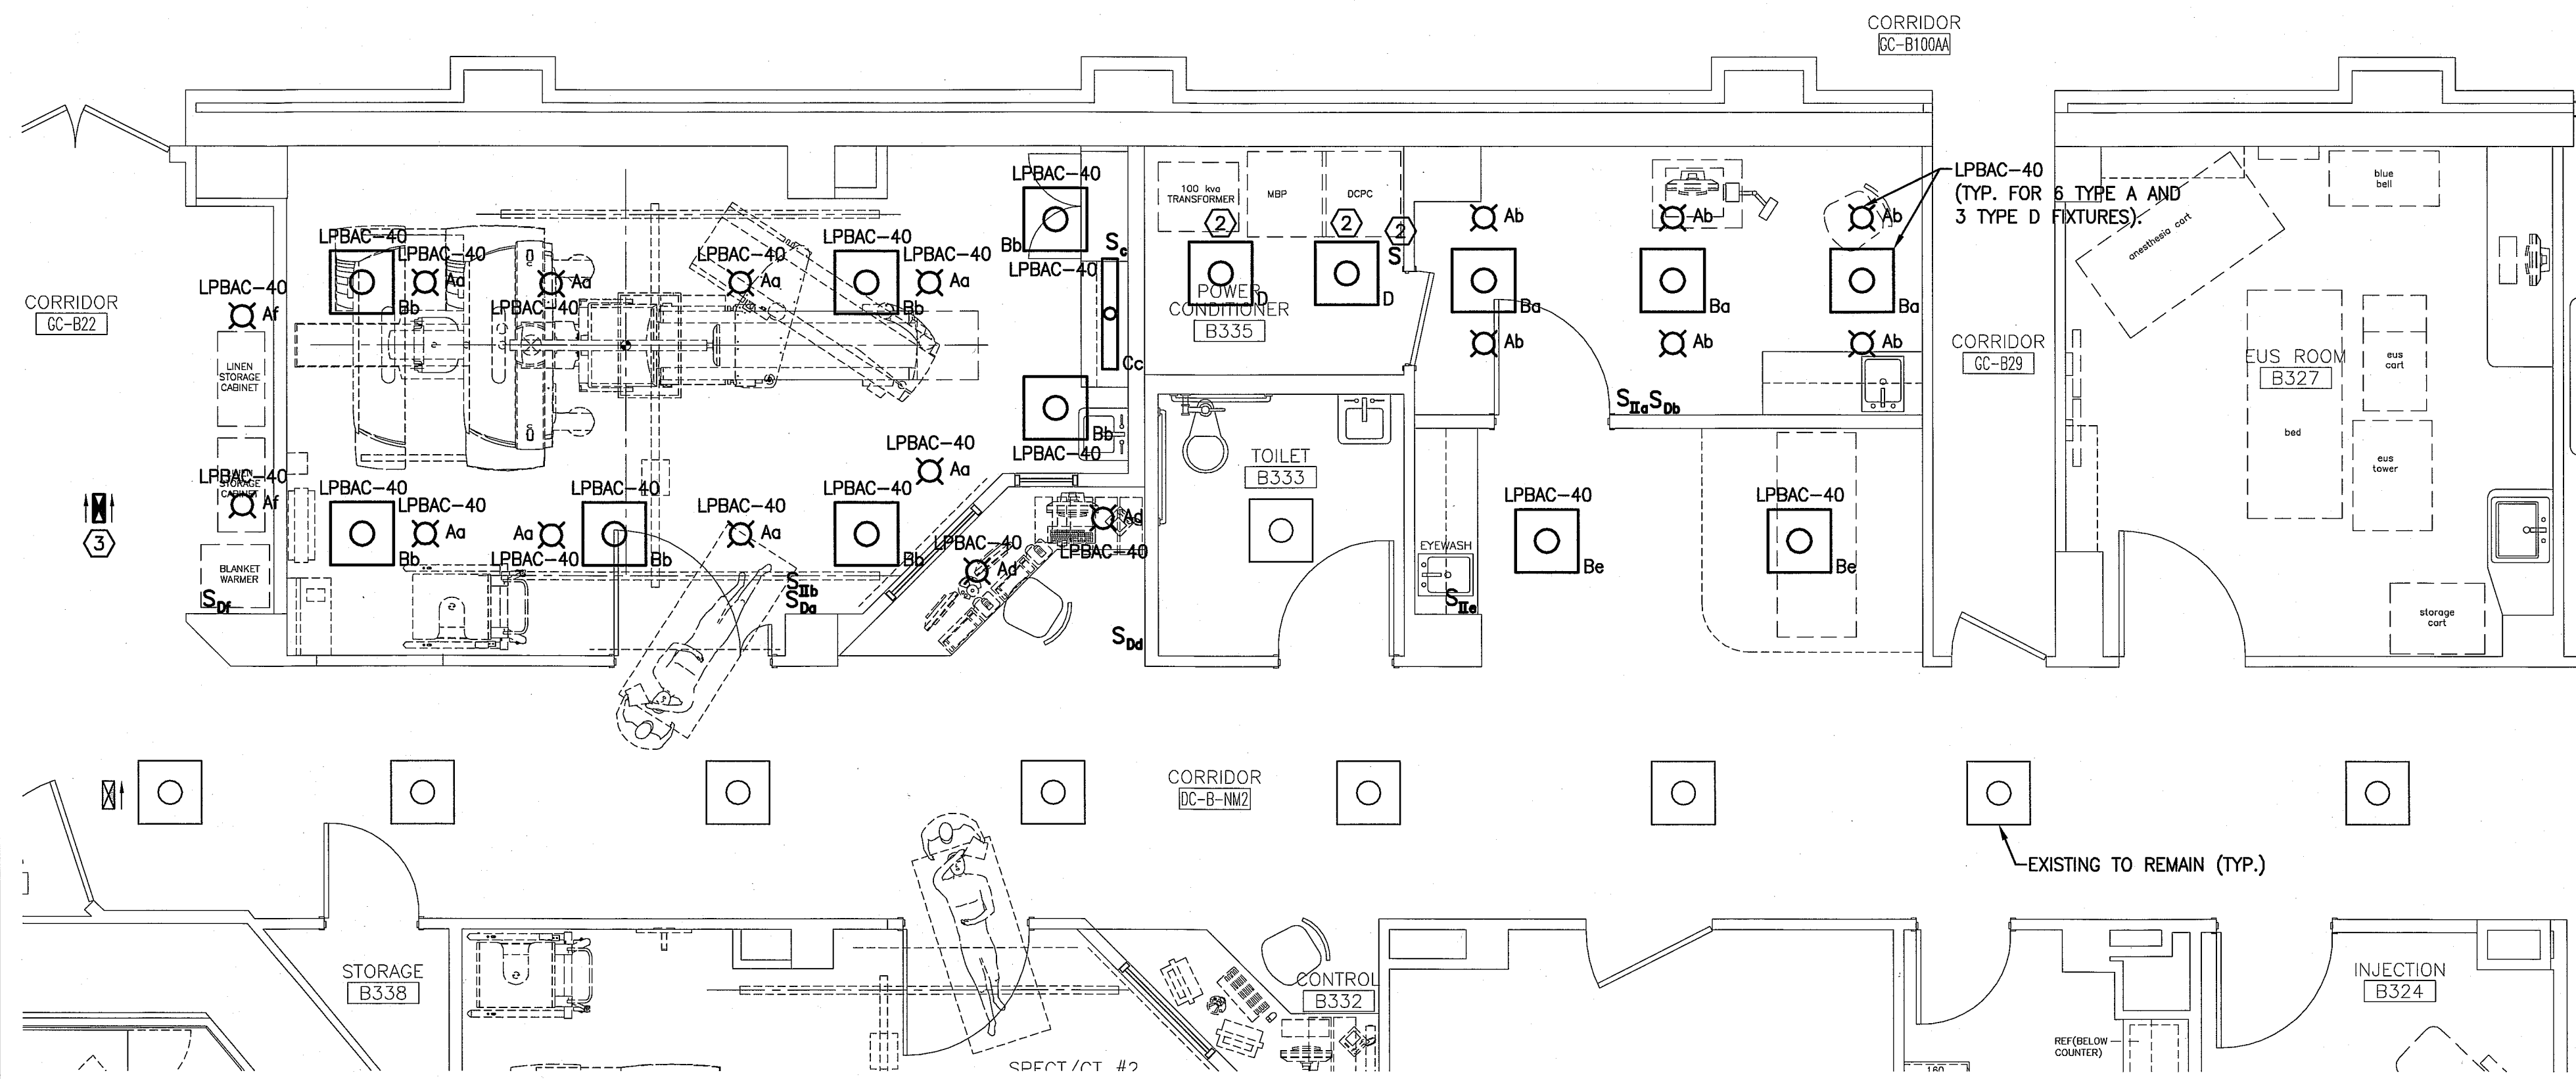

G6 REFLECTED CEILING PLAN

1/4"=1'-0"



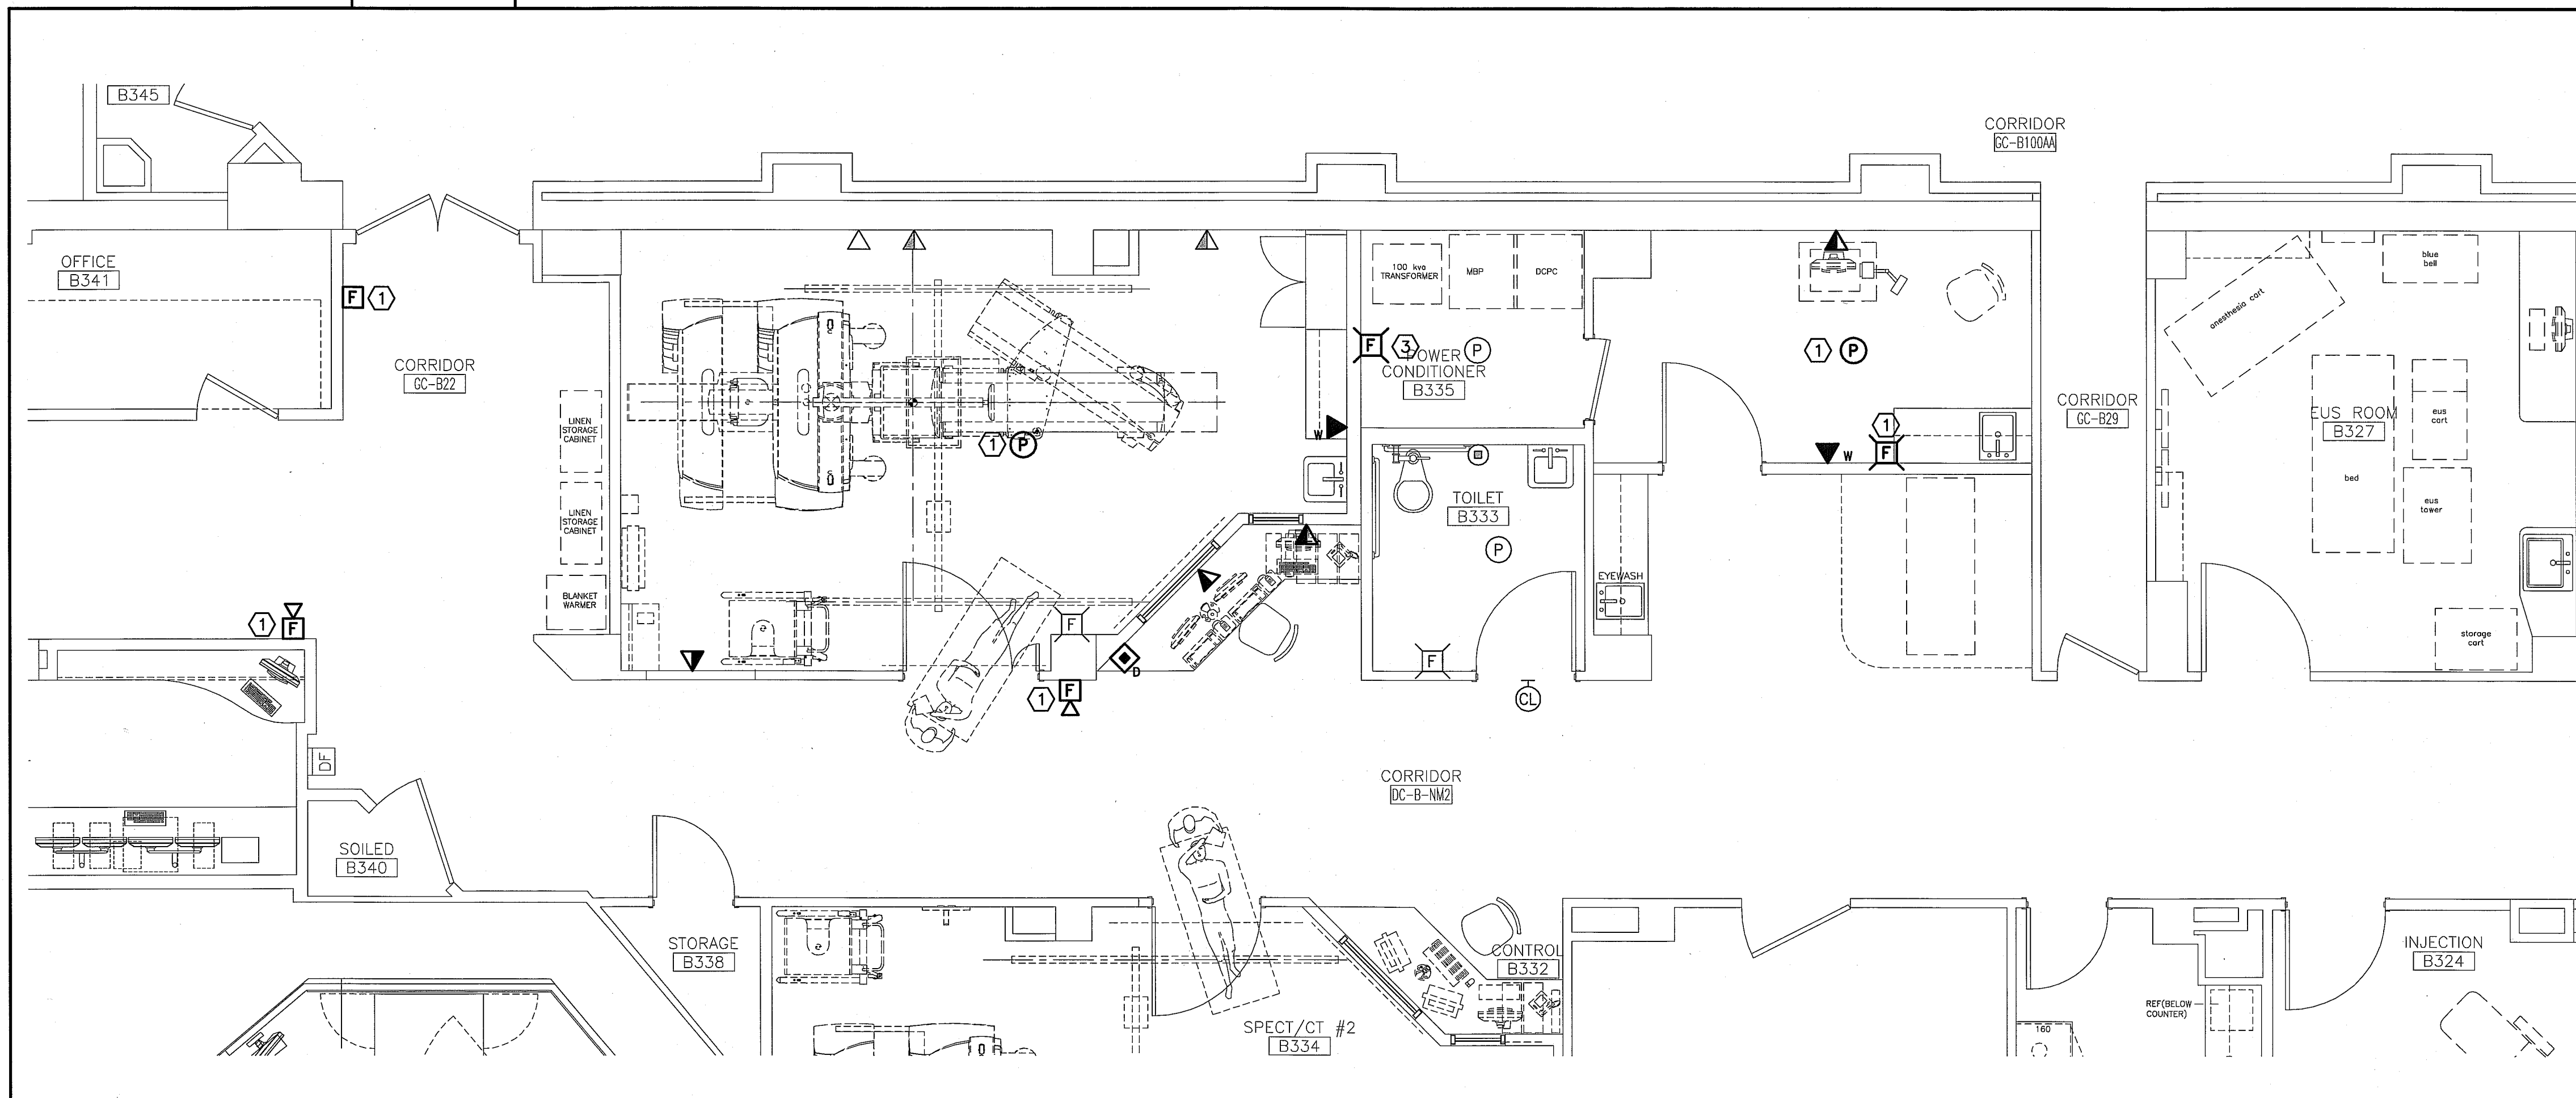


A5 FLOOR PLAN

1/4"=1'-0"

144 Fore Street, P.O. Box 618
Portland, Maine 04104
tel. (207) 772-3846
fax. (207) 772-1070
www.smtinc.com

ARCHITECTURE
ENGINEERING
PLANNING
INTERIOR DESIGN
COMMISSIONING

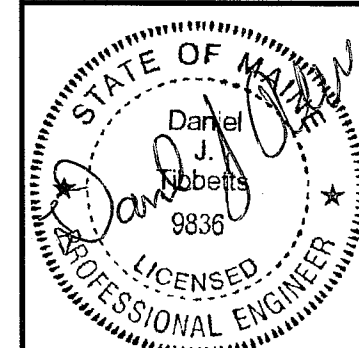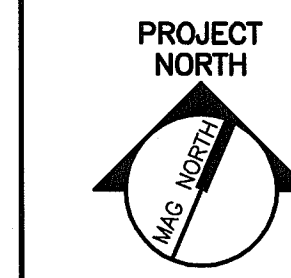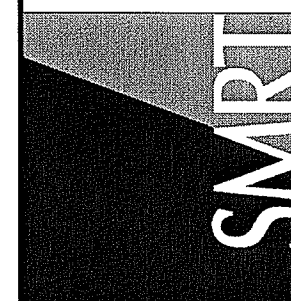

MAINE MEDICAL CENTER
NUCLEAR MEDICINE RENOVATIONS - PHASE 2
PORTLAND, MAINE

ISSUED FOR CONSTRUCTION
10-10-14

REV	DESCRIPTION	DATE
0	ISSUED FOR CONSTRUCTION	10-10-14

GRAPHIC SCALE:
0" = 1"

SCALE: 1/4"=1'-0"
PROJECT MANAGER: DJV
JC/DRAWN BY: CDS
A/E OF RECORD: DJT
CAD FILE: E-102-14113
PROJECT NO: 14113
DATE: 10-10-14

SHEET TITLE:
LIGHTING AND SYSTEMS PLANS

SHEET No.
E-102
© copyright 2013 SMT INC.