

MAINE MEDICAL CENTER NUCLEAR MEDICINE RENOVATION Phase 2 BRAMHALL CAMPUS - PORTLAND, MAINE

144 Fore Street/P.O. Box 818
Portland, Maine 04104
Tel. (207) 773-3846
Fax. (207) 773-1070
www.smrinc.com

ARCHITECTURE
ENGINEERING
PLANNING
INTERIOR DESIGN
COMMISSIONING


SMART

- A/C AIR CONDITIONING
- ACPLAS ACOUSTICAL PLASTER
- ACT ACOUSTIC CEILING TILE
- AFF ABOVE FINISHED FLOOR
- AP ACCESS PANEL
- BCE BOTTOM CHORD EXTENSION
- BD BOARD
- BLP BORROWED LIGHT PANEL
- BO BOTTOM OF
- BOF BOTTOM OF FOOTING
- BOS BOTTOM OF STEEL
- BS BOTH SIDES
- BSE BSBRICK SHELF ELEVATION
- C CHANNEL
- CB CATCH BASIN; CHALKBOARD
- CFM CUBIC FEET PER MINUTE
- CJ CONTROL JOINT; CONSTRUCTION JOINT
- CLG CEILING
- CMU CONCRETE MASONRY UNIT
- CTH CERAMIC TILE
- CUH CABINET UNIT HEATER
- DF DRINKING FOUNTAIN
- DR DISPLAY RAIL
- DW DISHWASHER
- EF EXHAUST FAN; EACH FACE
- EJ EXPANSION JOINT
- EPDM ETHYLENE PROPYLENE DIENE MONOMER
- EW EACH WAY
- EWC ELECTRIC WATER COOLER
- FB FLAT BAR
- FBO FURNISHED BY OTHERS
- FCO FLOOR CLEAN-OUT
- FD FLOOR DRAIN
- FE FIRE EXTINGUISHER
- FF FINISHED FLOOR; FAR FACE
- FO FRAMED OPENING
- FS FAR SIDE
- GB GRAB BAR
- GC GENERAL CONTRACTOR
- GDT GYPSUM DROP-IN TILE
- GWB GYPSUM WALL BOARD
- H HORIZONTAL
- HC HANDICAPPED; HOLLOW CORE
- HM HOLLOW METAL
- HRU HEAT RECOVERY UNIT
- HT HEIGHT
- H&V HEATING AND VENTILATING
- HVAC HEATING, VENTILATING AND AIR CONDITIONING
- IF INSIDE FACE
- IJ ISOLATION JOINT
- INV INVERT
- JS JOIST SUBSTITUTE
- L ANGLE
- LLH LONG LEG HORIZONTAL
- LLV LONG LEG VERTICAL
- LP LIGHTING PANEL; LIQUIFIED PROPANE
- MB MARKER BOARD
- MDO MEDIUM DENSITY OVERLAY
- MO MASONRY OPENING
- MR MOISTURE-RESISTANT
- MUA MAKE-UP AIR
- N NOSING
- NIC NOT IN CONTRACT
- NS NEAR SIDE
- NTS NOT TO SCALE
- OC ON CENTER
- OF OUTSIDE FACE
- OH OVERHEAD
- PA PUBLIC ADDRESS
- PAF POWDER-ACTUATED FASTENER
- PL PLATE
- PLAM PLASTIC LAMINATE
- PLF POUNDS PER LINEAR FOOT
- PP POWER PANEL
- PSF POUNDS PER SQUARE FOOT
- PSI POUNDS PER SQUARE INCH
- PT PRESSURE-TREATED
- PVC POLYVINYL CHLORIDE
- PWP PLASCORE WALL PANEL
- R RISER; RADIUS
- RB RESILIENT BASE
- RD ROOF DRAIN
- RO ROUGH OPENING
- RR RUB-RAIL
- ACT SUSPENDED ACOUSTIC TILE CEILING
- SBO IBC SUPPLIED BY OWNER
- SC SOLID CORE
- SCHD SCHEDULE
- SF SQUARE FOOT; SUPPLY FAN
- SK SHEAR KEY
- SN SANITARY NAPKIN (DISPENSER)
- SP SPACES
- SS STAINLESS STEEL

GRID LOCATION	TITLE
SCALE	REFERENCE SHEET
DRAWING TITLE BLOCK	



- BUILDING SECTION
- WALL SECTION
- DETAIL
- LEVEL LINE
- REVISION
- WINDOW TYPE
- DOOR NUMBER
- LOBBY
- ROOM NAME
- ROOM NUMBER
- INTERIOR ELEVATION
- WALL TYPE
- BACKER ROD AND SEALANT
- EXTERIOR ELEVATION

SITE LOCATION MAP: NDF BASEMENT

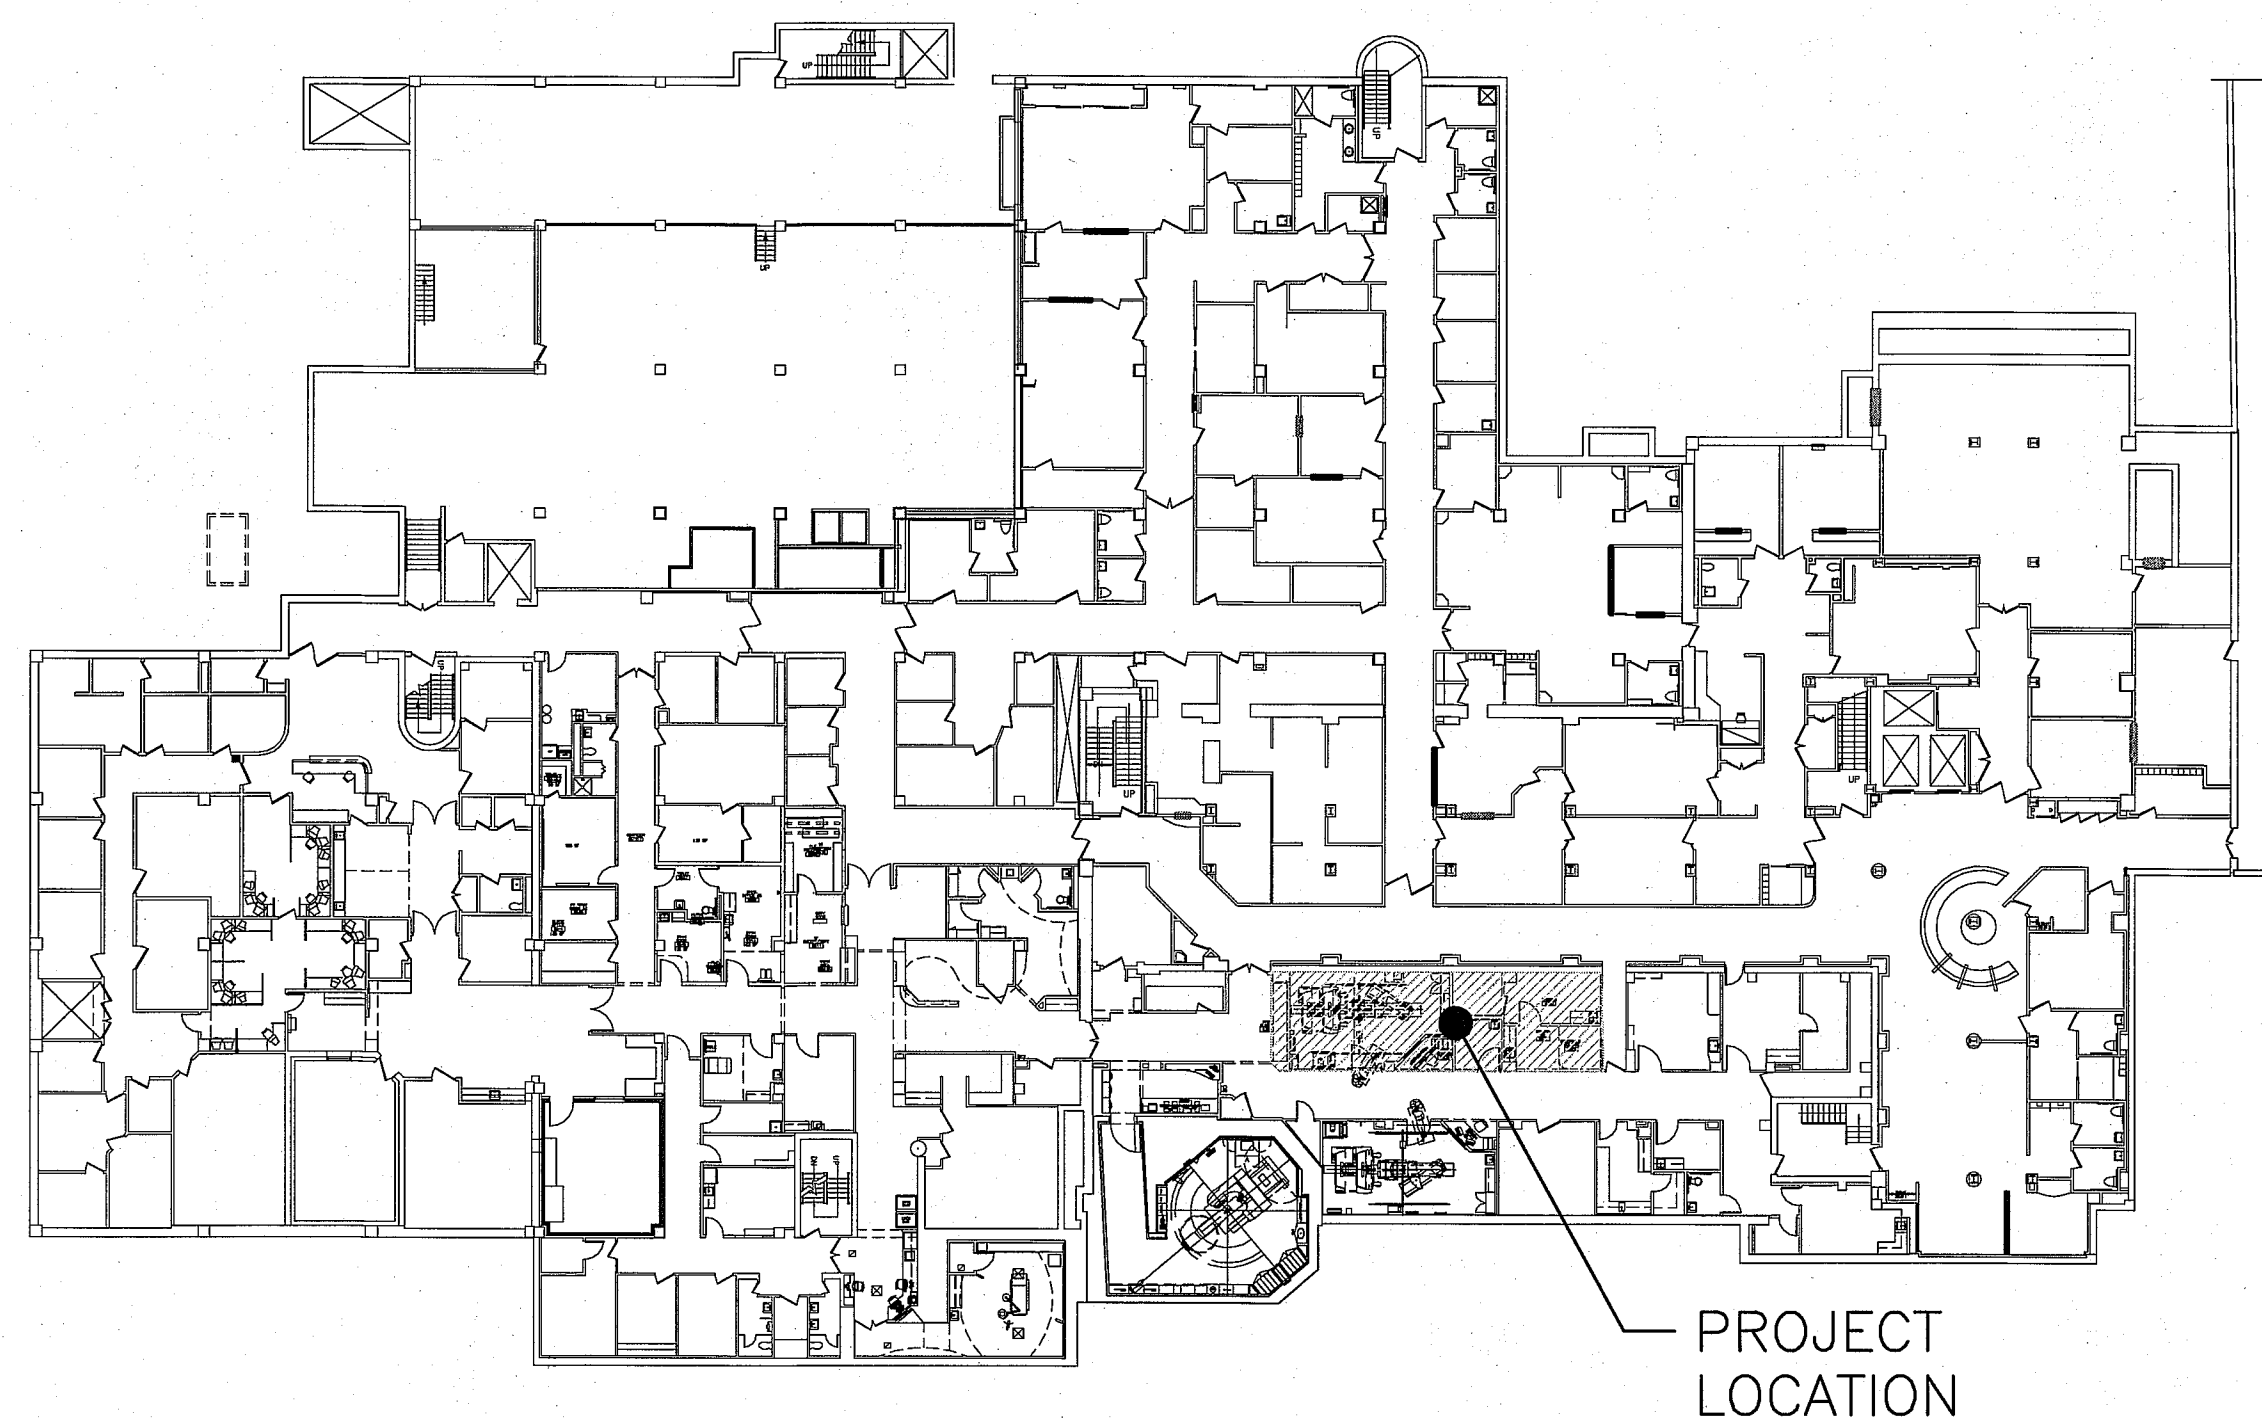

DRAWING LIST

- GENERAL**
- G1001 COVER SHEET
- G1002 PARTITION TYPES AND TYPICAL MOUNTING HEIGHTS
- ARCHITECTURAL**
- A-100 PARTIAL FACILITY AND CODE COMPLIANCE PLAN
- AD101 DEMOLITION FLOOR PLAN
- AE101 FLOOR PLAN AND REFLECTED CEILING PLAN
- AE210 INTERIOR ELEVATIONS
- AE601 SCHEDULES
- AF101 ARCHITECTURAL FINISHES PLAN
- FIRE PROTECTION**
- FP101 FIRE PROTECTION LEGEND, PLAN AND SPECIFICATION
- MECHANICAL**
- M-001 LEGEND & ABBREVIATIONS
- M-002 SPECIFICATIONS
- MD101 HVAC DUCTWORK DEMOLITION
- MH101 HVAC DUCTWORK NEW WORK PLAN
- MP101 HVAC PIPING NEW WORK PLAN
- M-501 DETAILS
- M-502 DETAILS
- M-601 SCHEDULES AND SEQUENCES OF OPERATION
- PLUMBING**
- P-001 LEGEND & ABBREVIATIONS
- P-002 SPECIFICATIONS
- PD101 PLUMBING DEMOLITION PLAN
- PL101 PLUMBING PLAN
- PL601 SCHEDULES AND DETAILS
- ELECTRICAL**
- E-001 LEGEND AND GENERAL NOTES
- E-002 SPECIFICATIONS
- ED101 ELECTRICAL DEMOLITION PLAN
- E-100 OVERALL PLAN
- E-101 POWER PLANS
- E-102 LIGHTING AND SYSTEMS PLANS
- E-601 PANEL SCHEDULES AND DETAIL
- SIEMENS EQUIPMENT DRAWINGS - SYMBIA INTEVO 2 (REFERENCE ONLY)**
- A-101 EQUIPMENT PLAN - LEGEND, DETAILS AND NOTES
- A-102 SAFETY SERVICE CLEARANCE PLAN, DETAILS AND NOTES
- S-101 STRUCTURAL PLAN - DETAILS AND NOTES
- S-501 DETAILS AND NOTES
- E-101 ELECTRICAL PLAN(S) - LEGEND AND NOTES
- E-102 ELECTRICAL PLAN - LEGEND AND NOTES

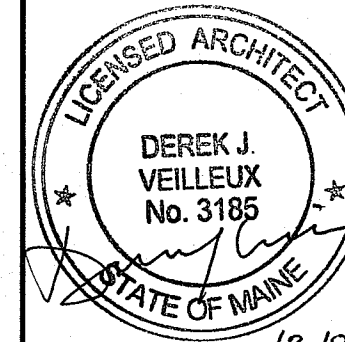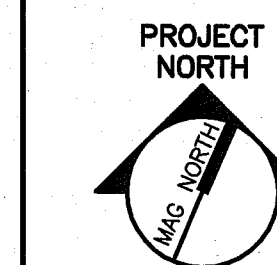

MAINE MEDICAL CENTER
NUCLEAR MEDICINE RENOVATIONS - PHASE 2
PORTLAND, MAINE

ISSUED FOR CONSTRUCTION
10-10-14

CURRENT ISSUE STATUS:

REV	DESCRIPTION	DATE
0	ISSUED FOR CONSTRUCTION	10-10-14

GRAPHIC SCALE:
0" 1"

SCALE: 1/4"=1'-0"
PROJECT MANAGER: DJV
JC/DRAWN BY: MDR
A/E OF RECORD: DJV
CAD FILE: G1001-14113
PROJECT NO: 14113
DATE: 10-10-14

SHEET TITLE:
COVER SHEET

SHEET No.
G1001
© COPYRIGHT 2013 SMR INC.