


**F1 REFLECTED CEILING PLAN**

1/4"=1'-0"

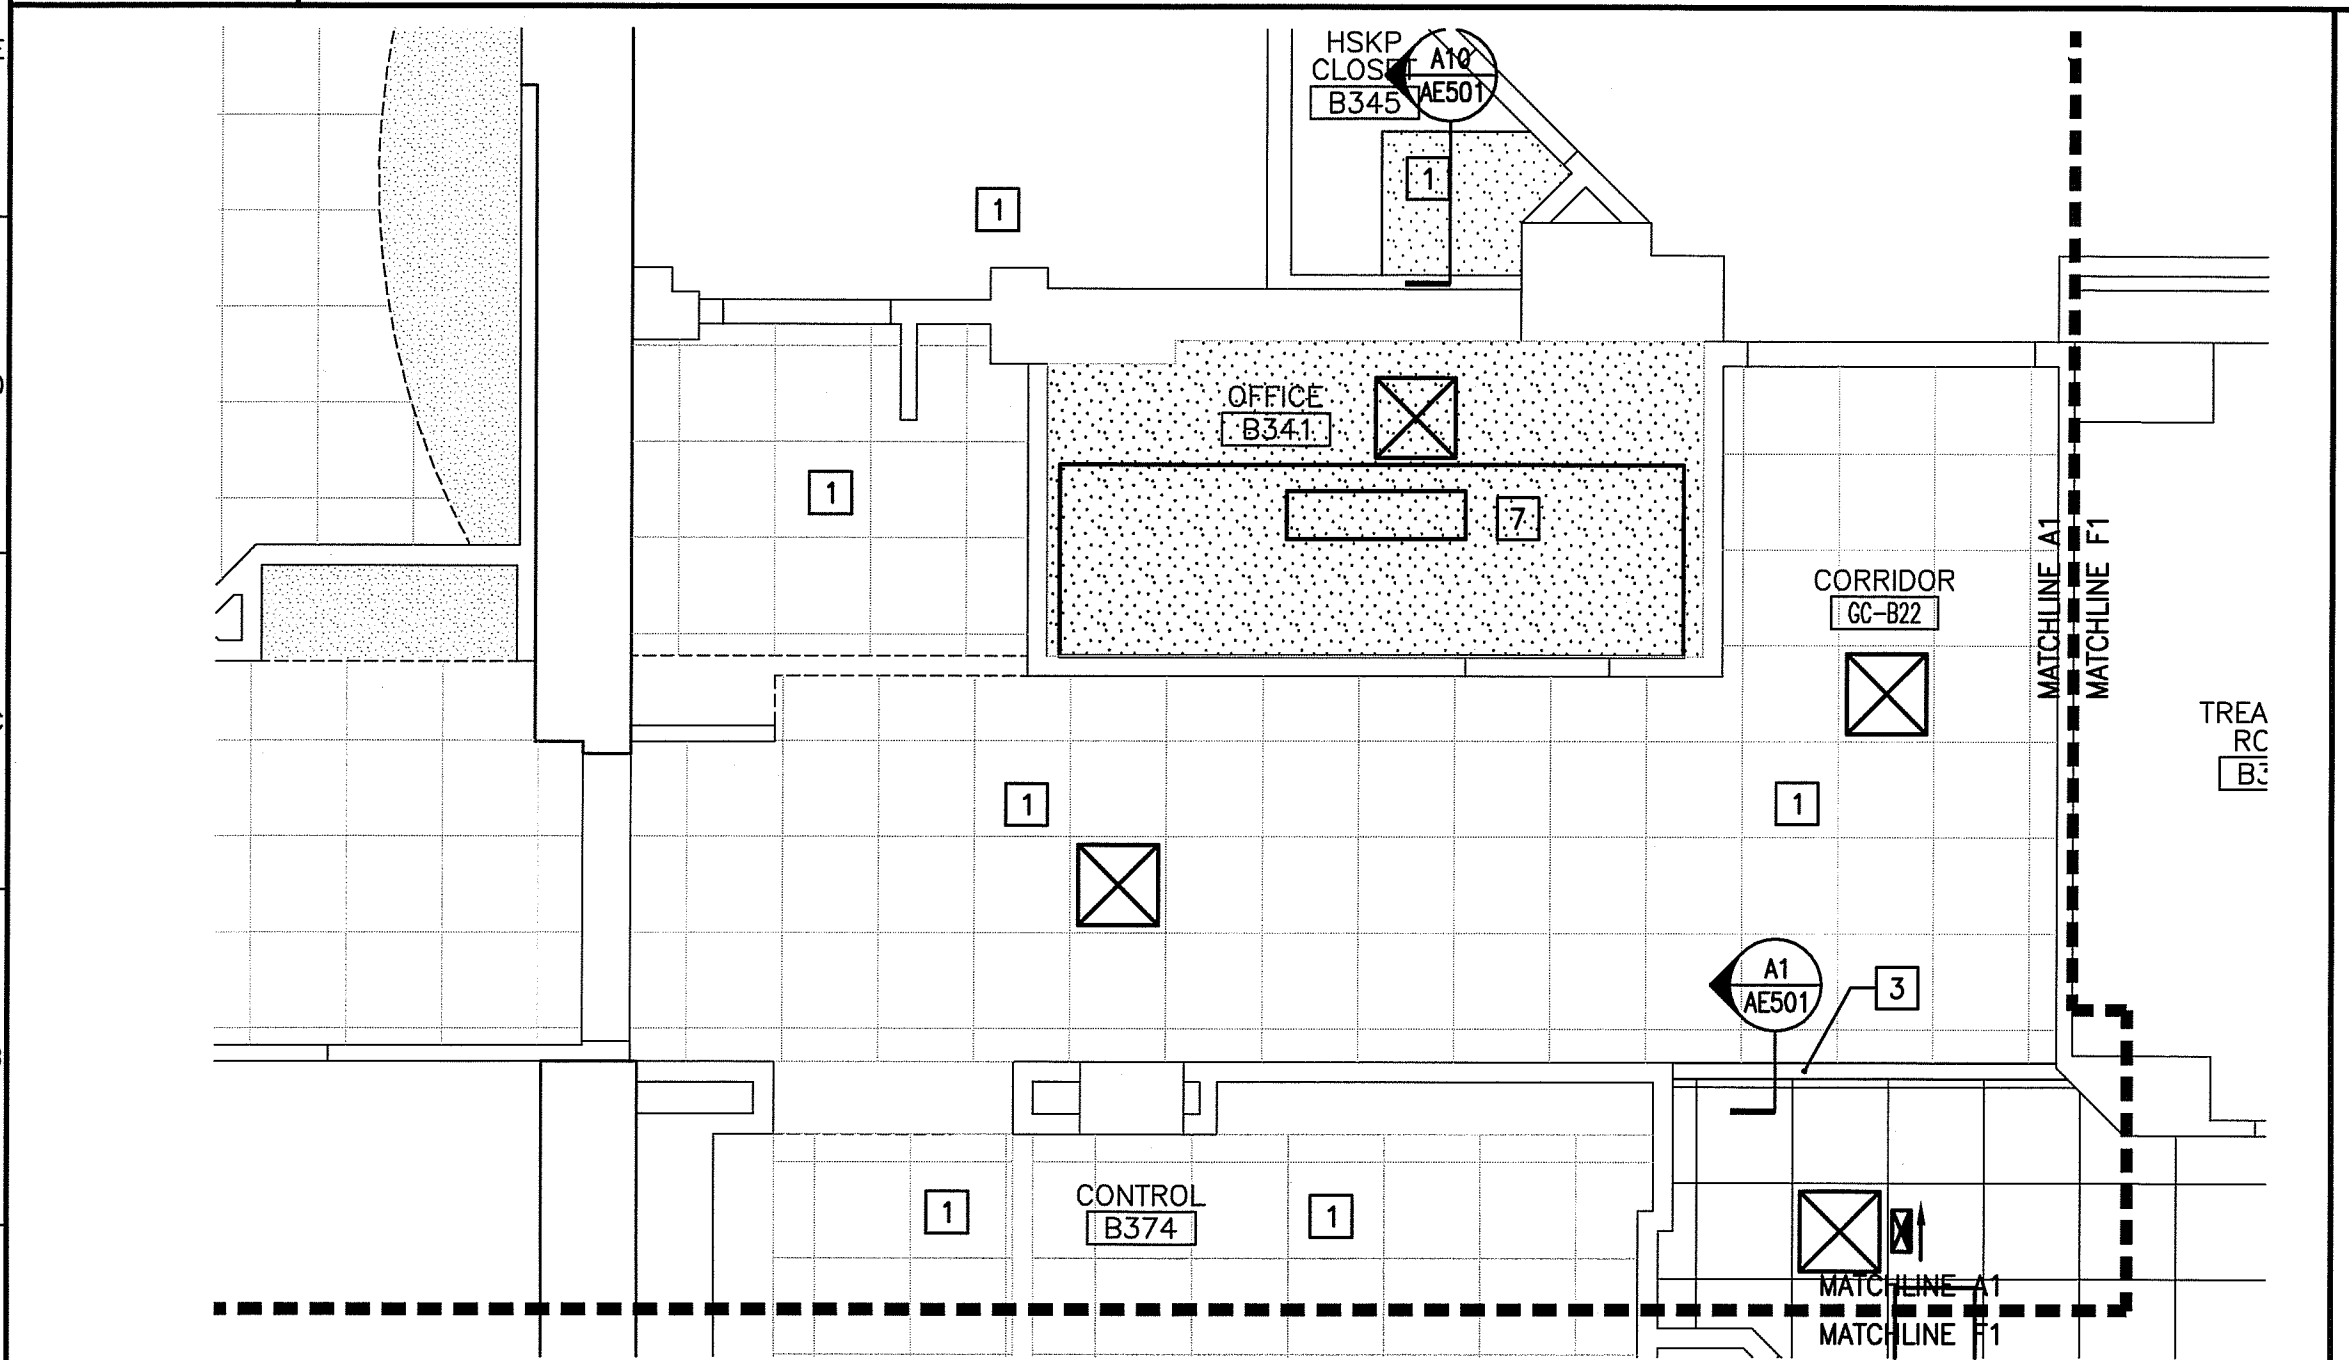

**A1 REFLECTED CEILING PLAN**

1/4"=1'-0"

**REFLECTED CEILING NOTES**



1. ALIGN CEILING ITEMS AS SHOWN, WITH COMMON CENTERLINES, TYPICALLY. CENTER ITEMS IN CEILINGS, OR IN AREAS UNLESS INDICATED OTHERWISE.
  2. MATCH EXISTING CEILING HEIGHTS.
  3. EXCEPT WHERE INDICATED, CENTER CEILING GRIDS IN ROOMS. USE HALF TILES OR GREATER @ PERIMETERS AS POSSIBLE.
  4. PROVIDE ACCESS PANELS AS REQUIRED IN GWB CEILINGS FOR ACCESS TO MECHANICAL VALVES/ CONTROLS. REFERENCE MECHANICAL.
- KEYED NOTES:**
- 1 EXISTING ACT CEILING TO BE REMOVED AND REINSTALLED FOLLOWING MECHANICAL WORK. REPAIR AND/OR REPLACE ANY GRID OR TILES AS NECESSARY.
  - 2 MODIFY EXISTING ACT CEILING AS REQUIRED TO ACCOMMODATE PROPOSED WALL LAYOUT.
  - 3 BOTTOM OF SOFFIT 2" BELOW LOWEST ADJACENT CEILING.
  - 4 CEILING MOUNTED PATIENT LIFT SYSTEM
  - 5 CEILING MOUNTED CURTAIN TRACK AND CURTAIN
  - 6 EXISTING CEILING TO REMAIN.
  - 7 PROVIDE GWB CEILING ON MTL. STUD FRAMING. ACOUSTICAL BATT INSULATION OVER ENTIRE ROOM.
  - 8 OWNER PROVIDED TV MOUNTED HORIZONTALLY ON POLE MOUNTED TO ROOF DECK ABOVE. CONTRACTOR INSTALLED.

**SYMBOL LEGEND**

- 2x2 SUSPENDED CEILING PANEL AND GRID ASSEMBLY.
- 2x4 SUSPENDED CEILING PANEL AND GRID ASSEMBLY.
- GWB CEILING.
- 2x4 LAY-IN LIGHT FIXTURE.
- 1x4 PENDANT LIGHT FIXTURE.
- DOWN LIGHT.
- CEILING MOUNTED EXIT LIGHT.
- RETURN AIR GRILLE.
- SUPPLY AIR GRILLE.
- EXHAUST AIR GRILLE.

144 Fore Street/P.O. Box 618  
Portland, Maine 04104  
Tel. (207) 772-3846  
Fax. (207) 772-1070  
www.smrtd.com

ARCHITECTURE  
ENGINEERING  
PLANNING  
INTERIOR DESIGN  
COMMISSIONING

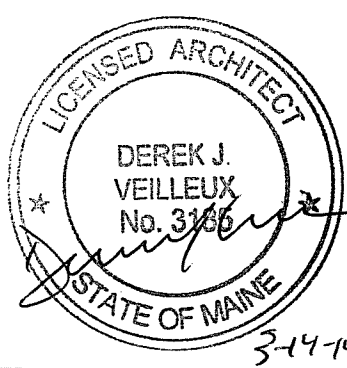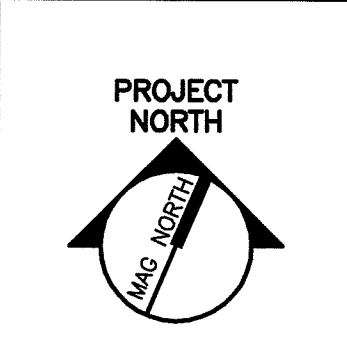

MAINE MEDICAL CENTER  
NUCLEAR MEDICINE RENOVATIONS  
PORTLAND, MAINE

ISSUED FOR CONSTRUCTION  
3-13-14

CURRENT ISSUE STATUS:

REV	DESCRIPTION	DATE
0	ISSUED FOR CONSTRUCTION	3-13-14

GRAPHIC SCALE:  
0" 1"

SCALE: 1/4"=1'-0"

PROJECT MANAGER: DJV  
JC/DRAWN BY: MDR  
A/E OF RECORD: DJV  
CAD FILE: AE111-13128  
PROJECT NO: 13128  
DATE: 3-13-14

SHEET TITLE:  
**REFLECTED CEILING PLAN**

SHEET No.  
**AE111**  
© COPYRIGHT 2013 SMRT INC.