



ARCHITECTS  
INTERIORS  
PLANNERS

55 GREEN STREET  
PORTSMOUTH, NH 03801  
T 603.436.2551  
F 603.436.6973  
www.jsainc.com

NEILL & GUNTER, Inc.  
Design and Consulting Engineers  
Scarborough, Maine

RENOVATIONS TO  
RICHARD'S 3rd FLOOR


MAINE MEDICAL CENTER  
Portland, Maine

Scale: 1/4" = 1'-0"  
Project Number: 03-103  
Date: MAY 25, 2004  
Revisions:




CONSTRUCTION  
DOCUMENTS

E-3A

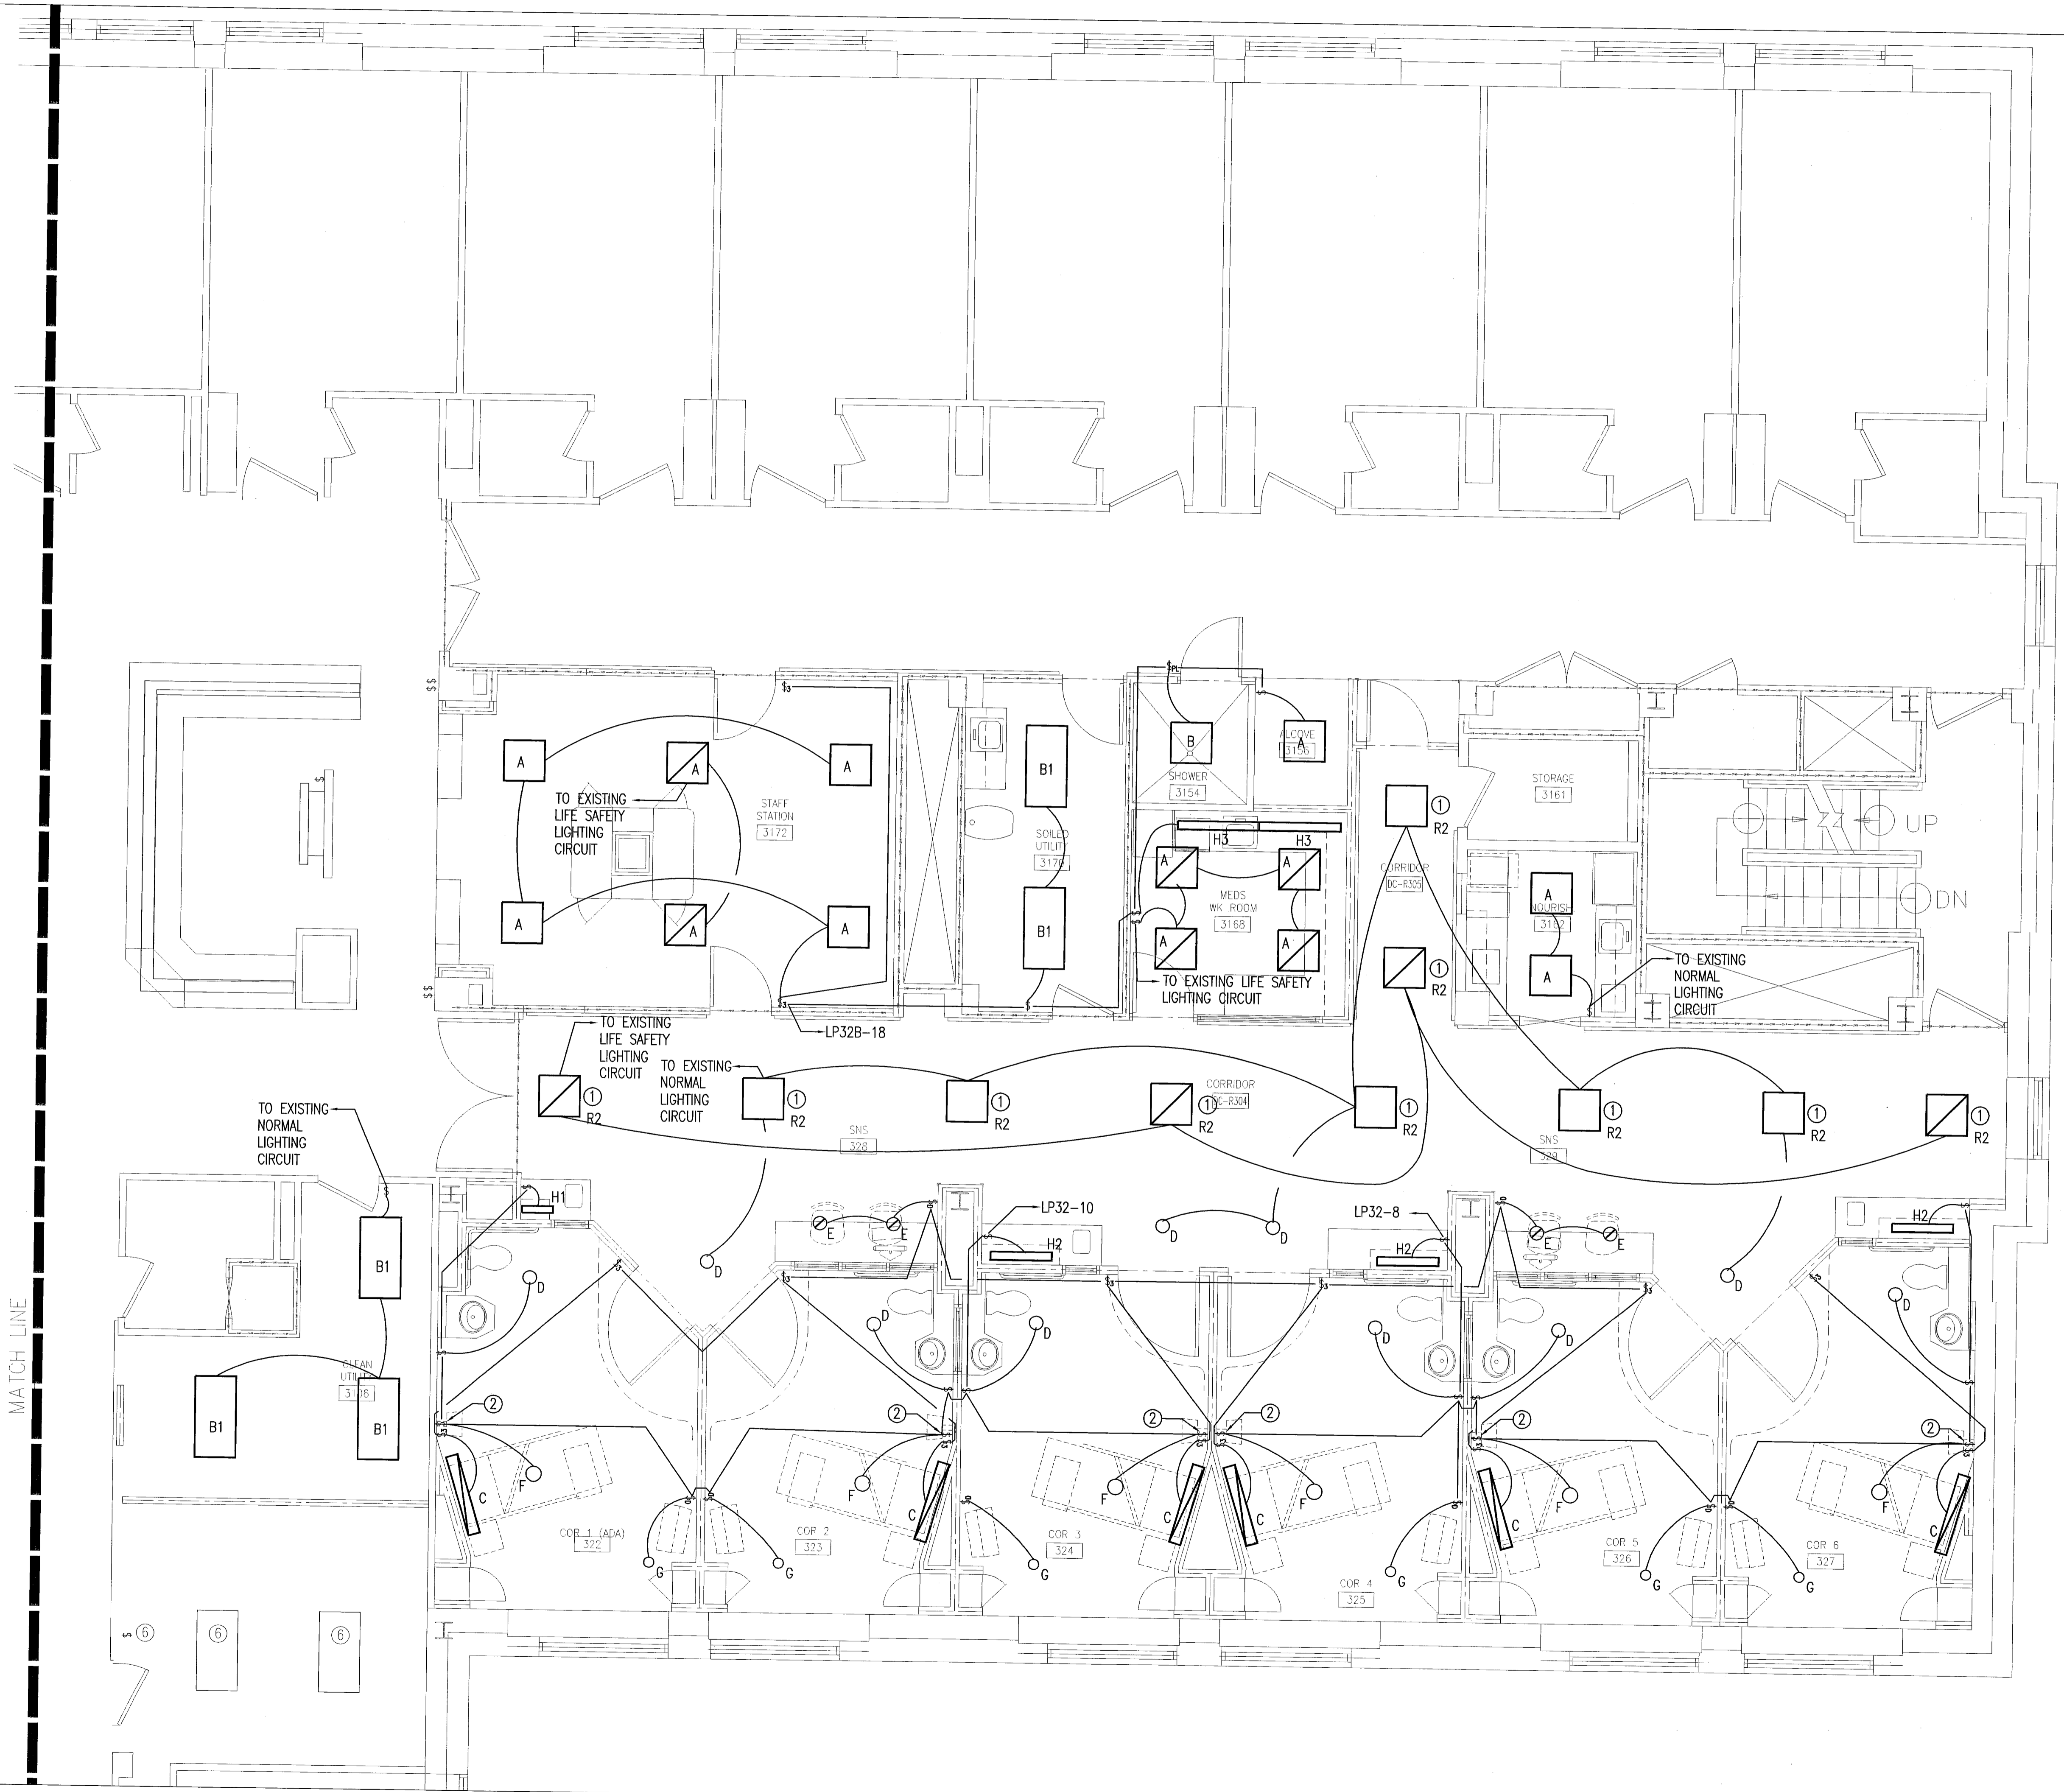

LIGHTING NOTES:

- ① RE-INSTALL EXISTING FIXTURE.
- ② USE LISTED BACK BOX (2-GANG) AND LIGHTING CONTROL PANEL PROVIDED BY PATIENT LIGHT FIXTURE MANUFACTURER. MOUNT SWITCH AT NO MORE THAN 30' FROM FIXTURE (35' CABLE PROVIDED) AT 48" A.F.F.

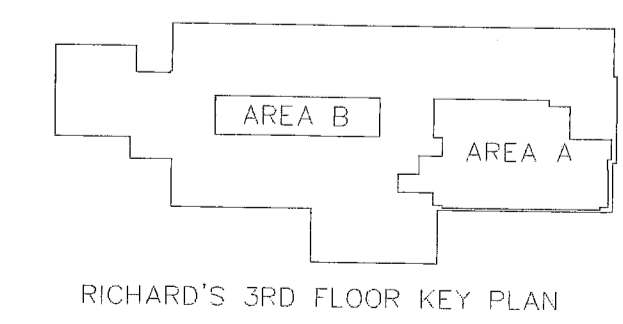

Neill and Gunter

LIGHTING PLAN  
CAD FILE 25485E002

L:\25485\Cadd\25485E002.dwg May 24, 2004 - 1:45pm

MATCH LINE