



ARCHITECTS  
INTERIORS  
PLANNERS


55 GREEN STREET  
PORTSMOUTH, NH 03801  
T 603.436.2551  
F 603.436.6973  
www.jsainc.com

NEILL & GUNTER, Inc.  
Design and Consulting Engineers  
Scarborough, Maine

RENOVATIONS TO  
RICHARD'S 3RD FLOOR

MAINE MEDICAL CENTER  
Portland, Maine



Scale: 1/4" = 1'-0"  
Project Number: 03-103  
Date: MAY 25, 2004  
Revisions:

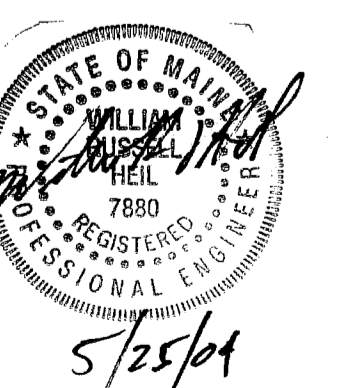

CONSTRUCTION  
DOCUMENTS

E-3B

© Copyright 2002, JSA, Inc

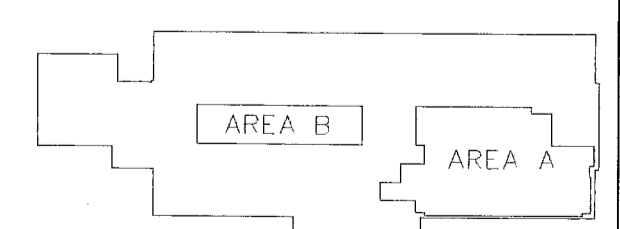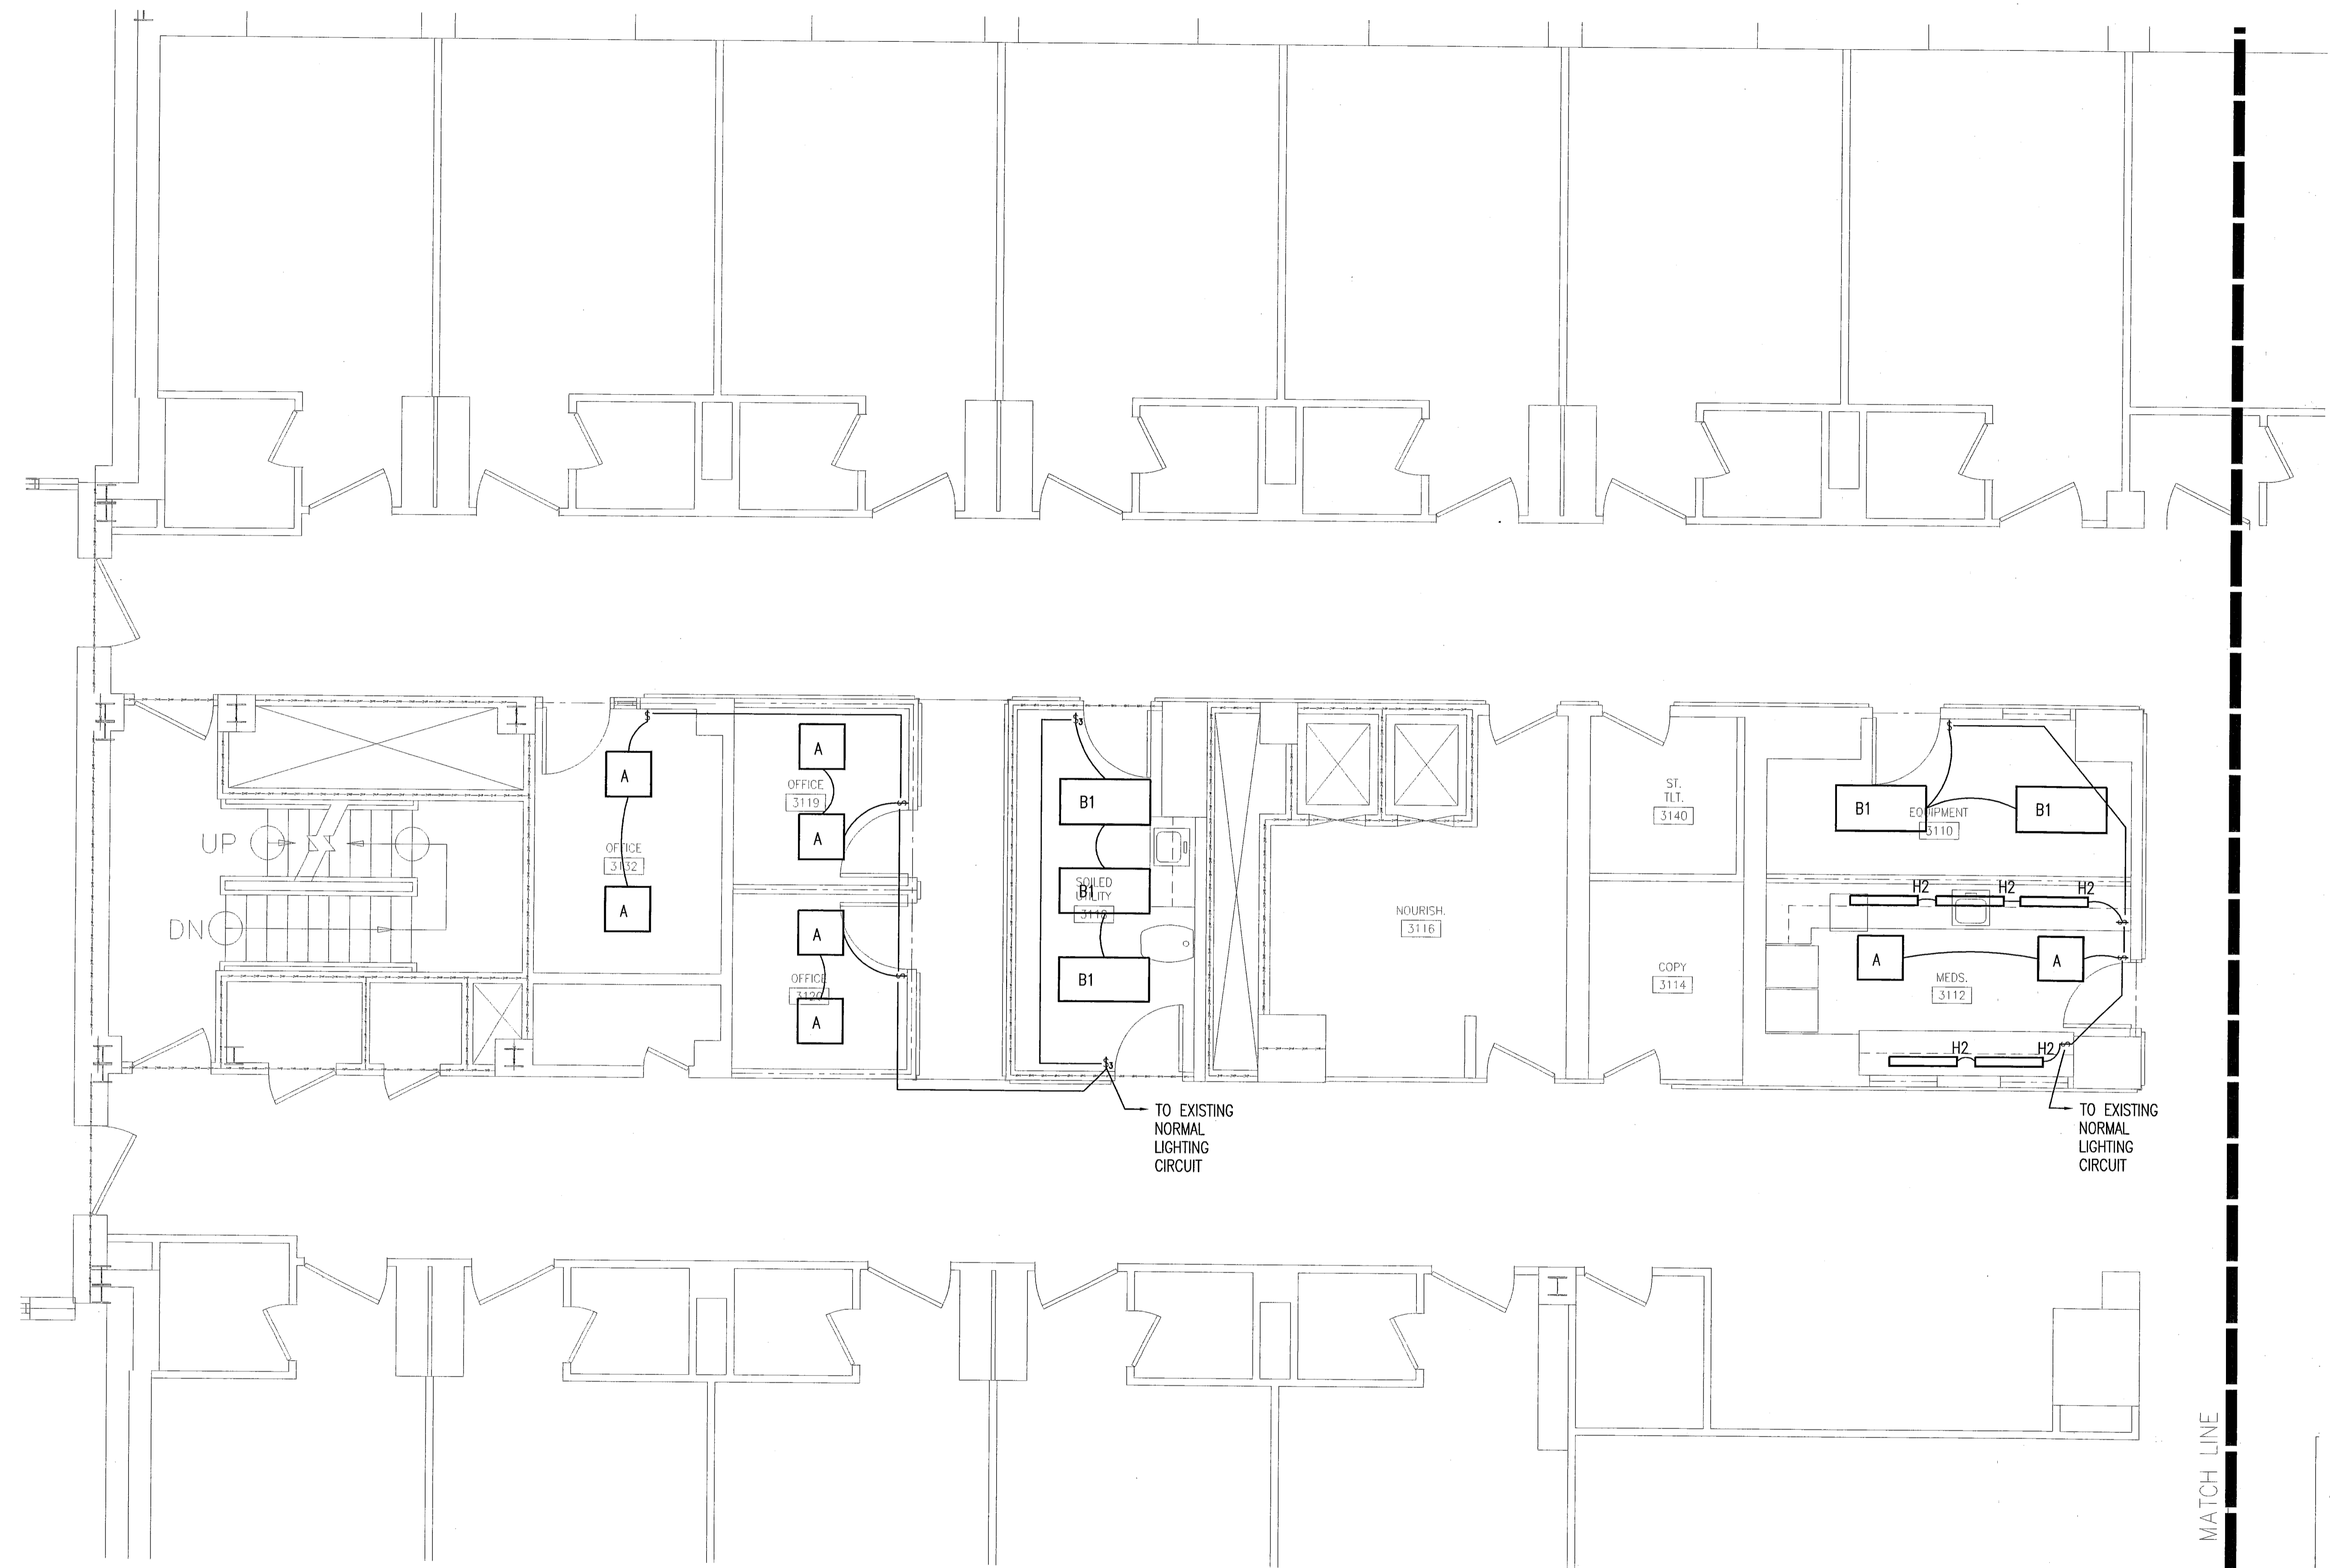

LIGHTING PLAN  
CAD FILE 25485E002

L:\25485\Cad\25485E002.dwg May 24, 2004 - 1:45pm